

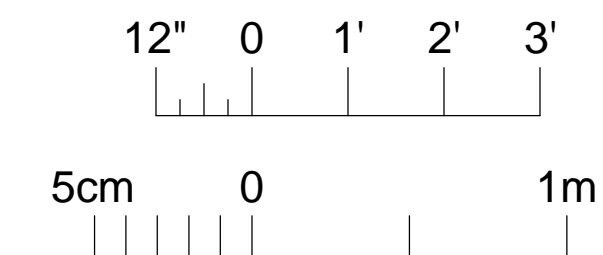
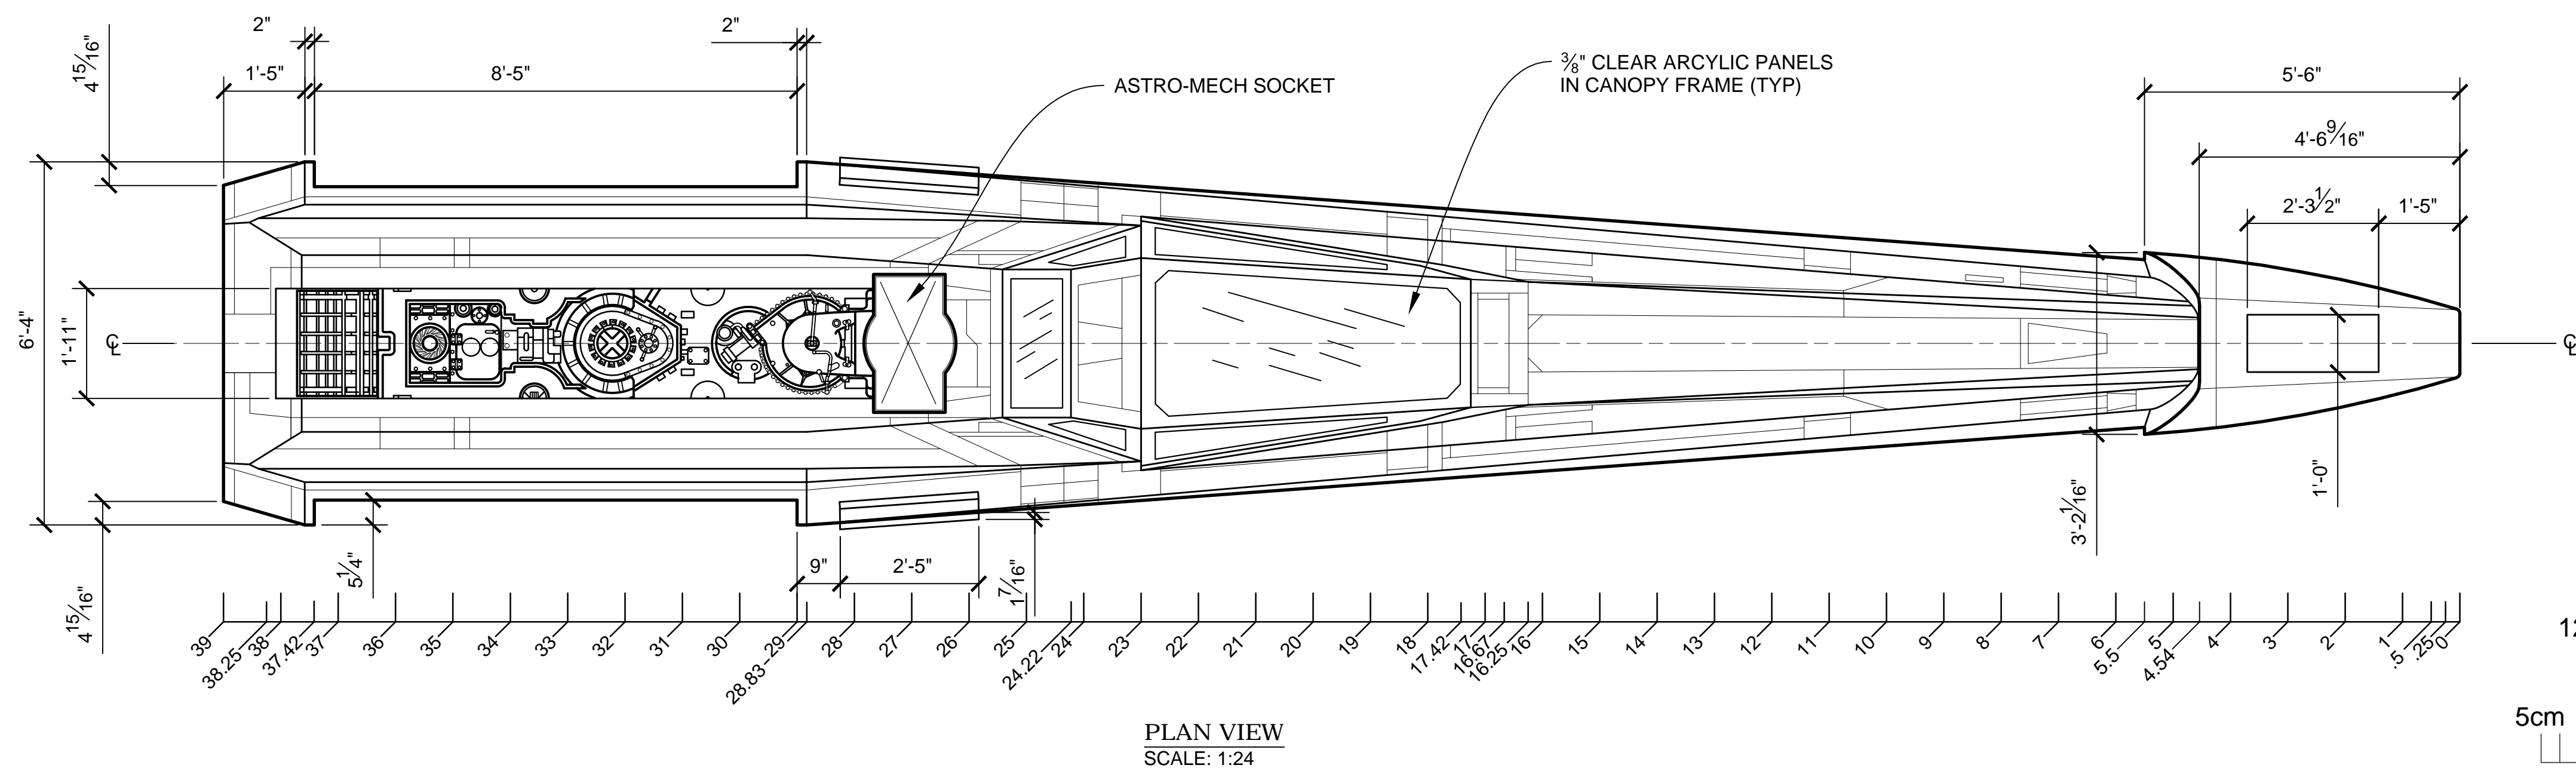
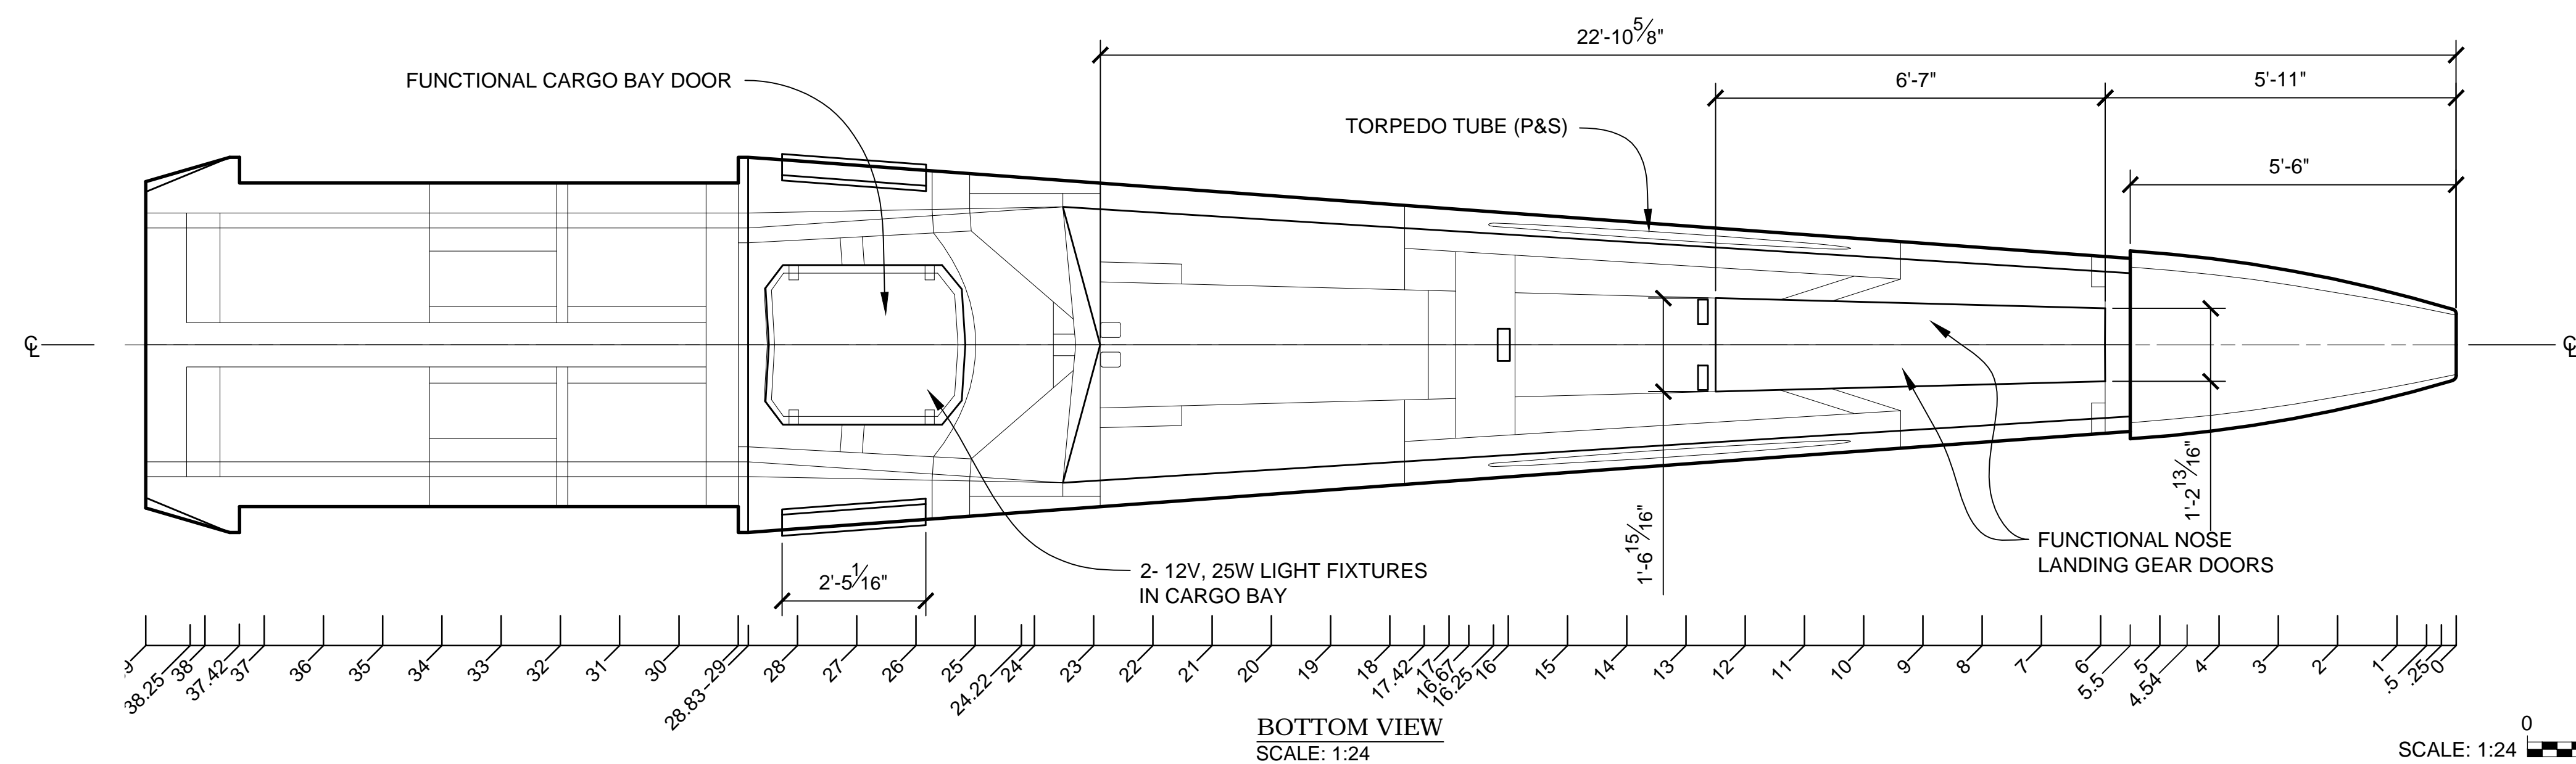
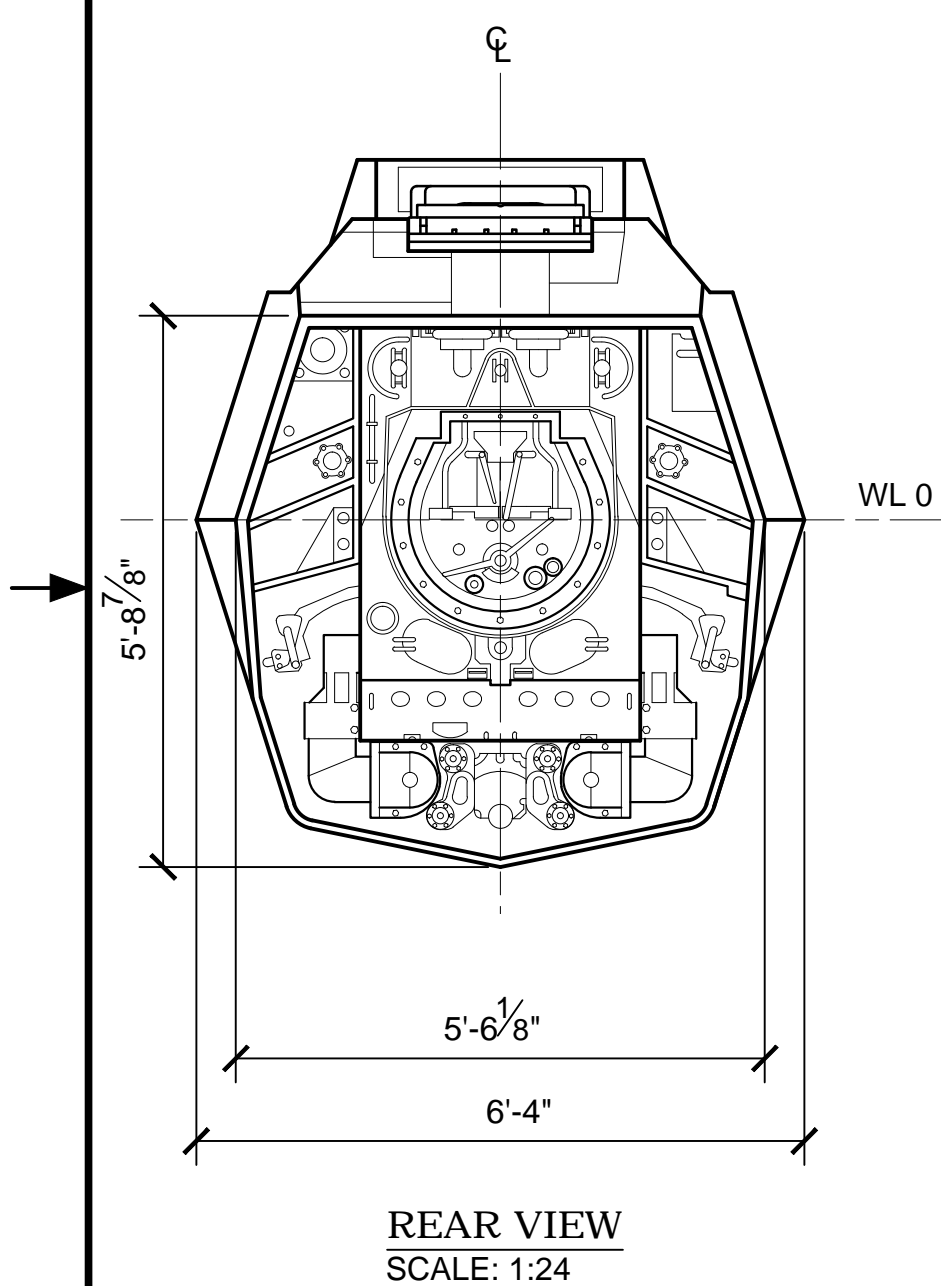


PROJECT		THE X-WING BUILD	
		1:1 SCALE STAGE PROP	
SET		SET NO.	
TITLE		REV	
GENERAL PLAN AND ELEVATIONS		--	
PROD DESIGNER		DATE DRAWN 3/SEP/2012	
DRAWN BY B.J.S.	APPROVED BY	DATE ISSUED DD/MMM/YYYY	
STAGE	LOCATION	DWG NO.	
		1.01	
FILE	SHEET	OF	
X-WING LINES_MASTER.DWG	1	XX	

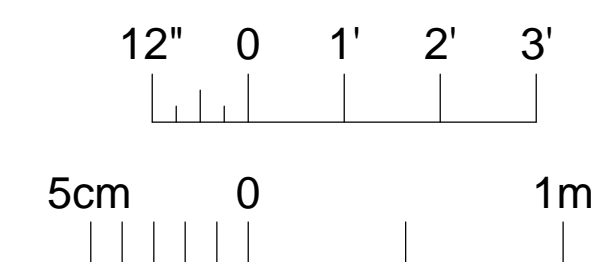










NOTES:

1. PREEXISTING MATERIAL COPYRIGHTED BY THE STAR WARS CORPORATION AND LUCASFILM LTD.
2. FOR NOSE LANDING GEAR DOORS INCLUDE A LATCH OR FASTENERS TO HOLD DOORS CLOSED.
3. DESIGN CARGO BAY DOOR HINGE AND LATCH ASSEMBLY FOR A LIVE LOAD OF 250 POUNDS.
4. TORPEDO TUBES ARE ALUMINUM 5" DIA SCH 40 PIPE. OD: 5.563", WALL: 0.258", ID: 5.047".

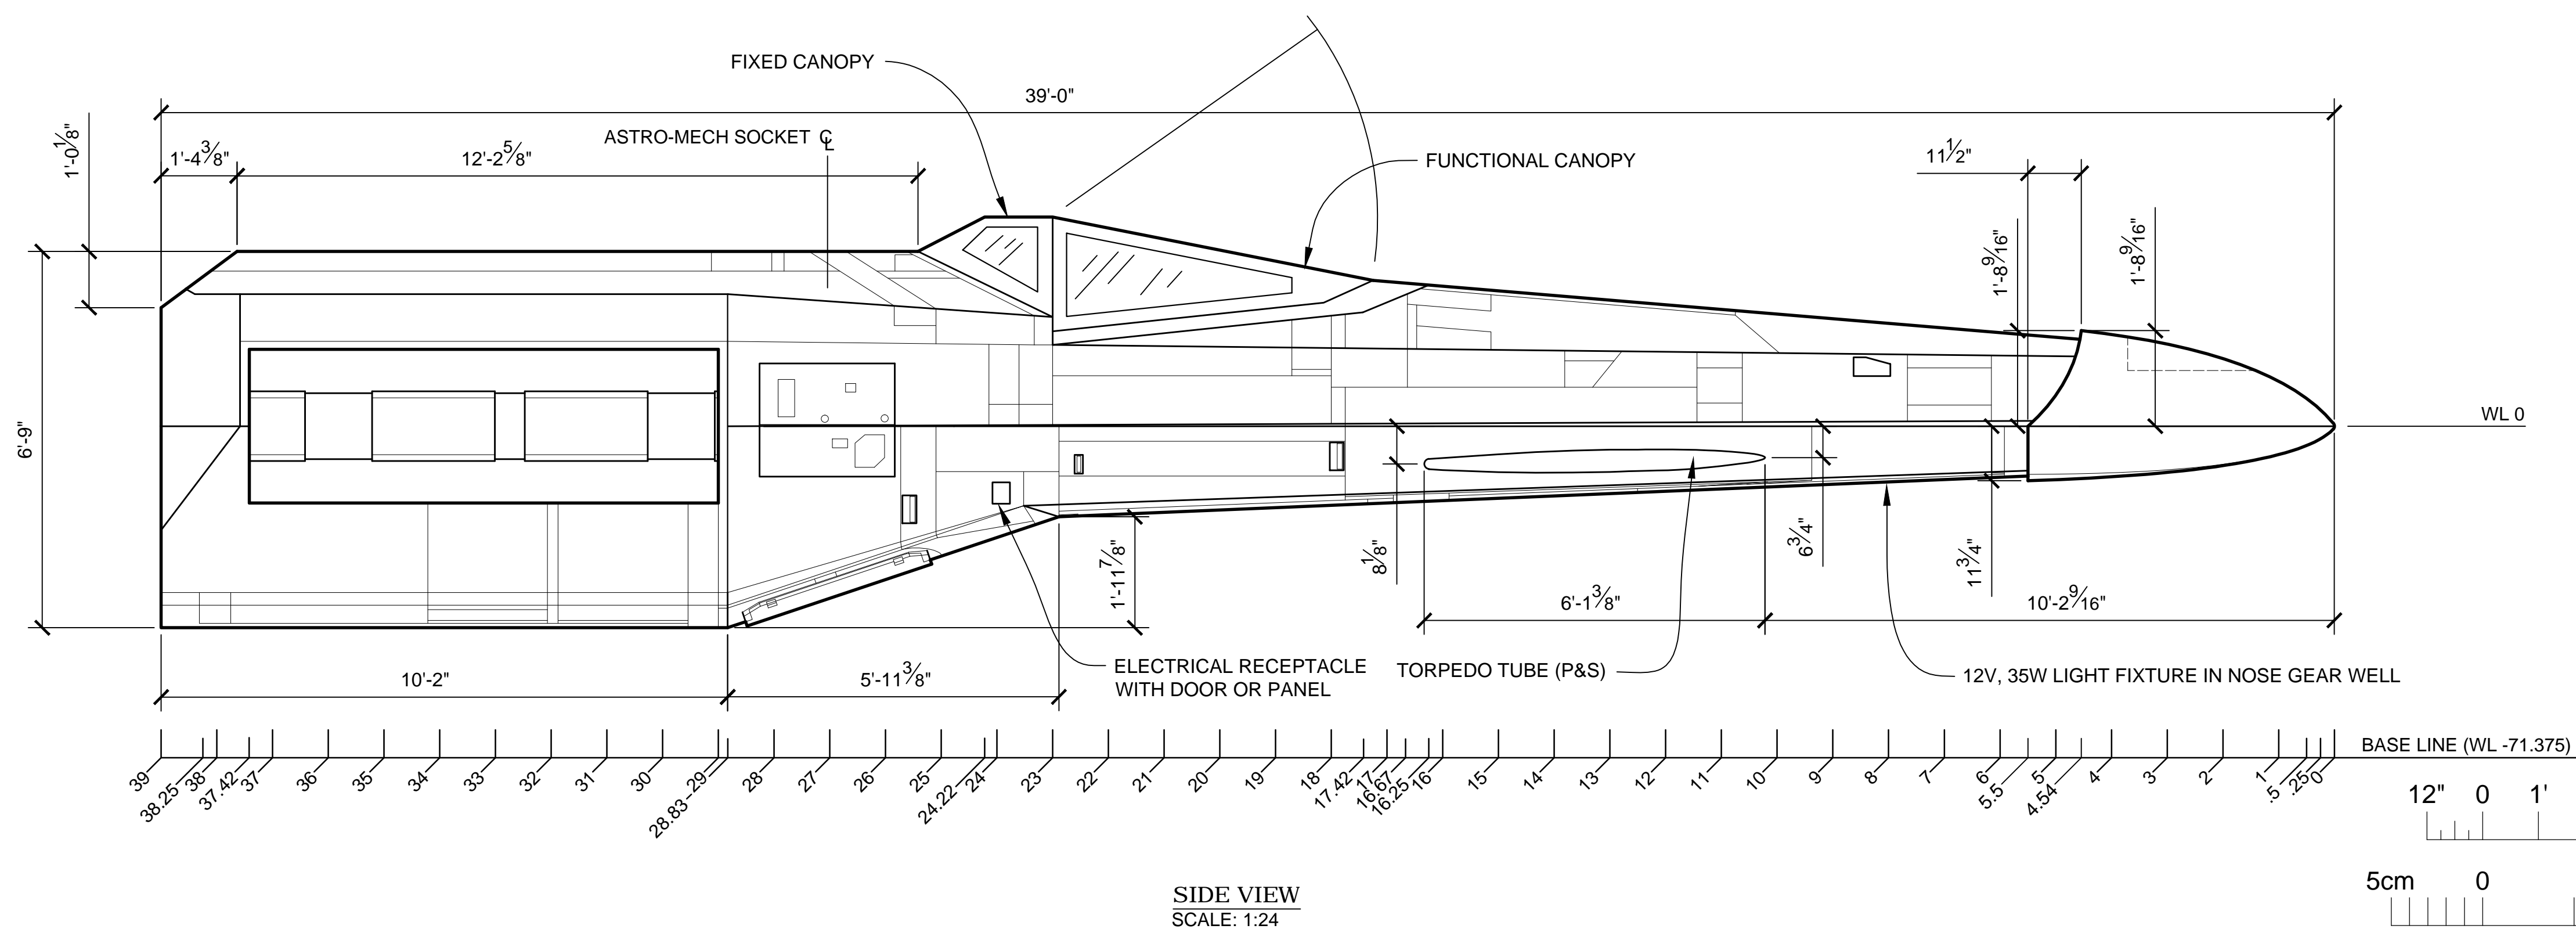

PRODUCTION	D.O.P.	ART DIRECTOR	CAMERA
ART DEPT.	SET DESIGNER	SCULPTOR	GRAPHICS
SET DEC.	DRAPES	PROPS	MODEL SHOP
CONST. COORD.	CARPENTER	PLASTER	PAINT
GREENS	SCENIC	METALS	SFX
GRIP	ELECTRICAL	VFX	CGI

PROJECT		THE X-WING BUILD	
		1:1 SCALE STAGE PROP	
SET		SET NO.	
TITLE FUSELAGE PLAN AND ELEVATIONS		REV --	
PROD DESIGNER		DATE DRAWN 3/SEP/2012	
DRAWN BY B.J.S.	APPROVED BY	DATE ISSUED DD/MMM/YYYY	
STAGE	LOCATION	DWG NO.	
FILE	X-WING LINES	MASTER.DWG	SHEET 3 OF XX
2.01			

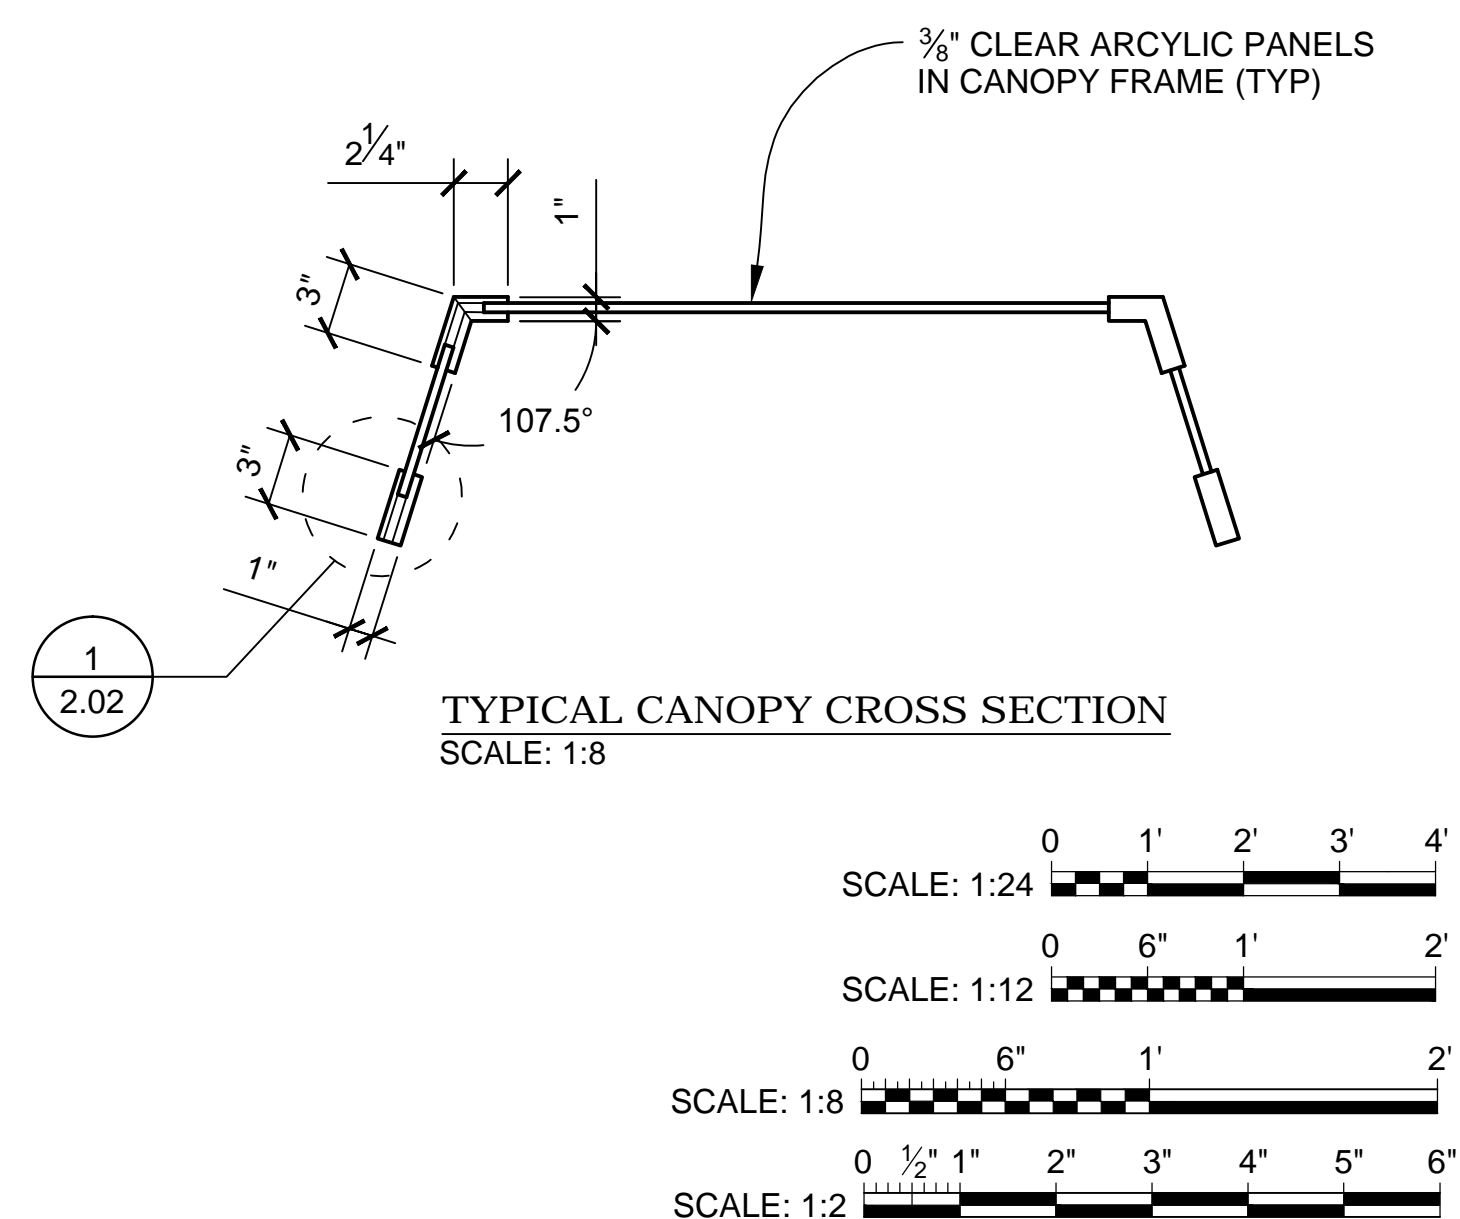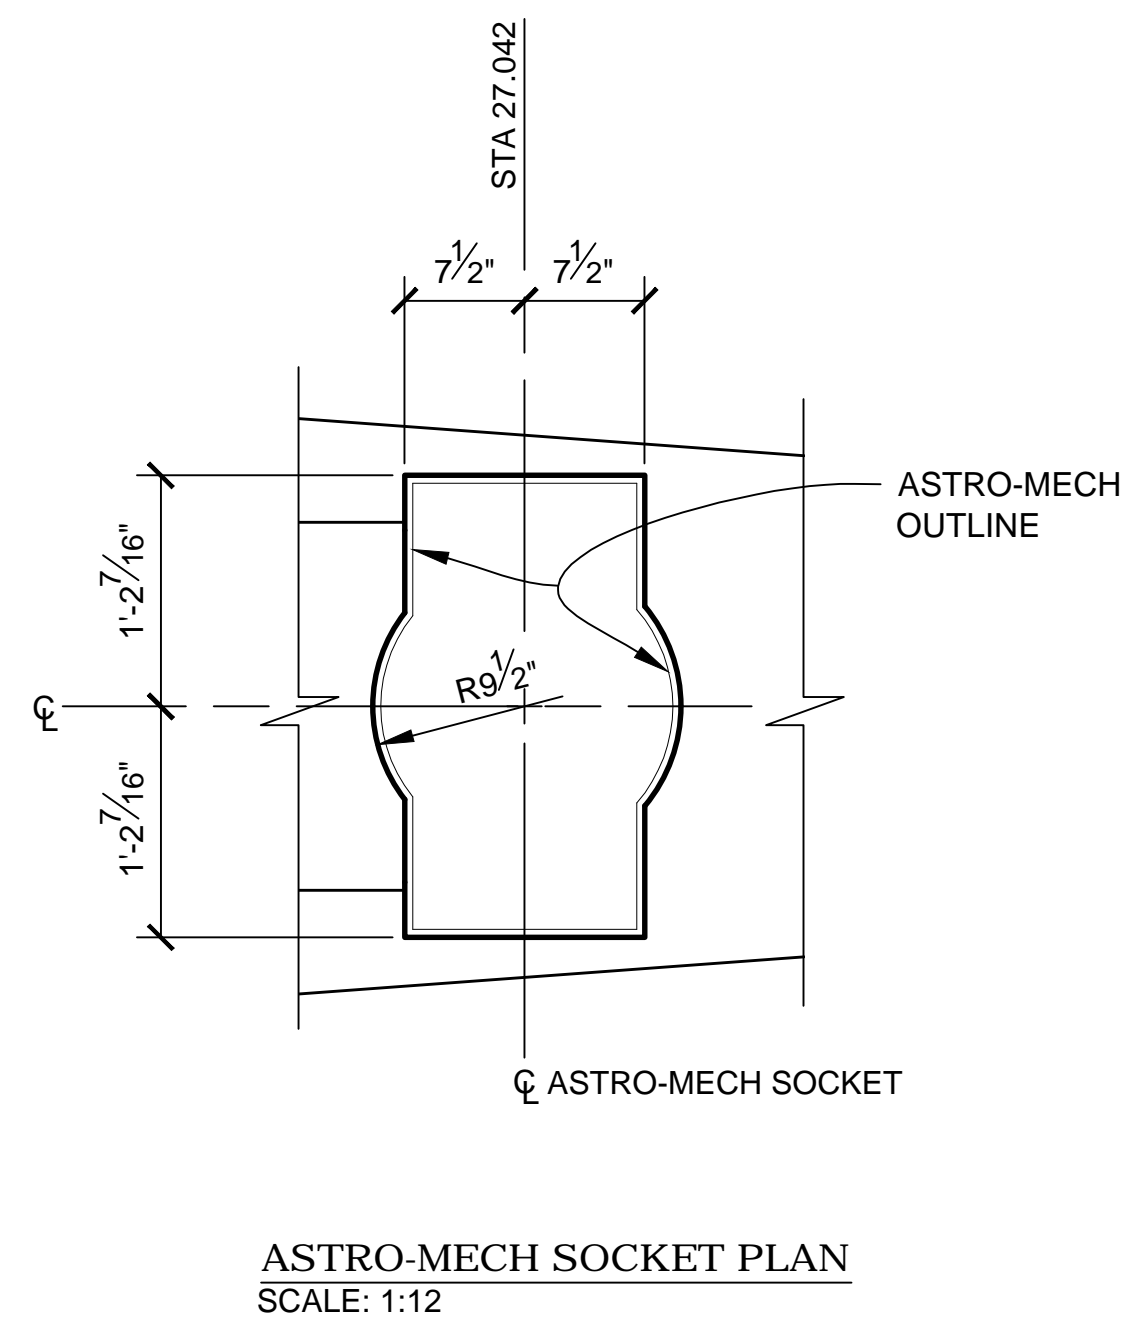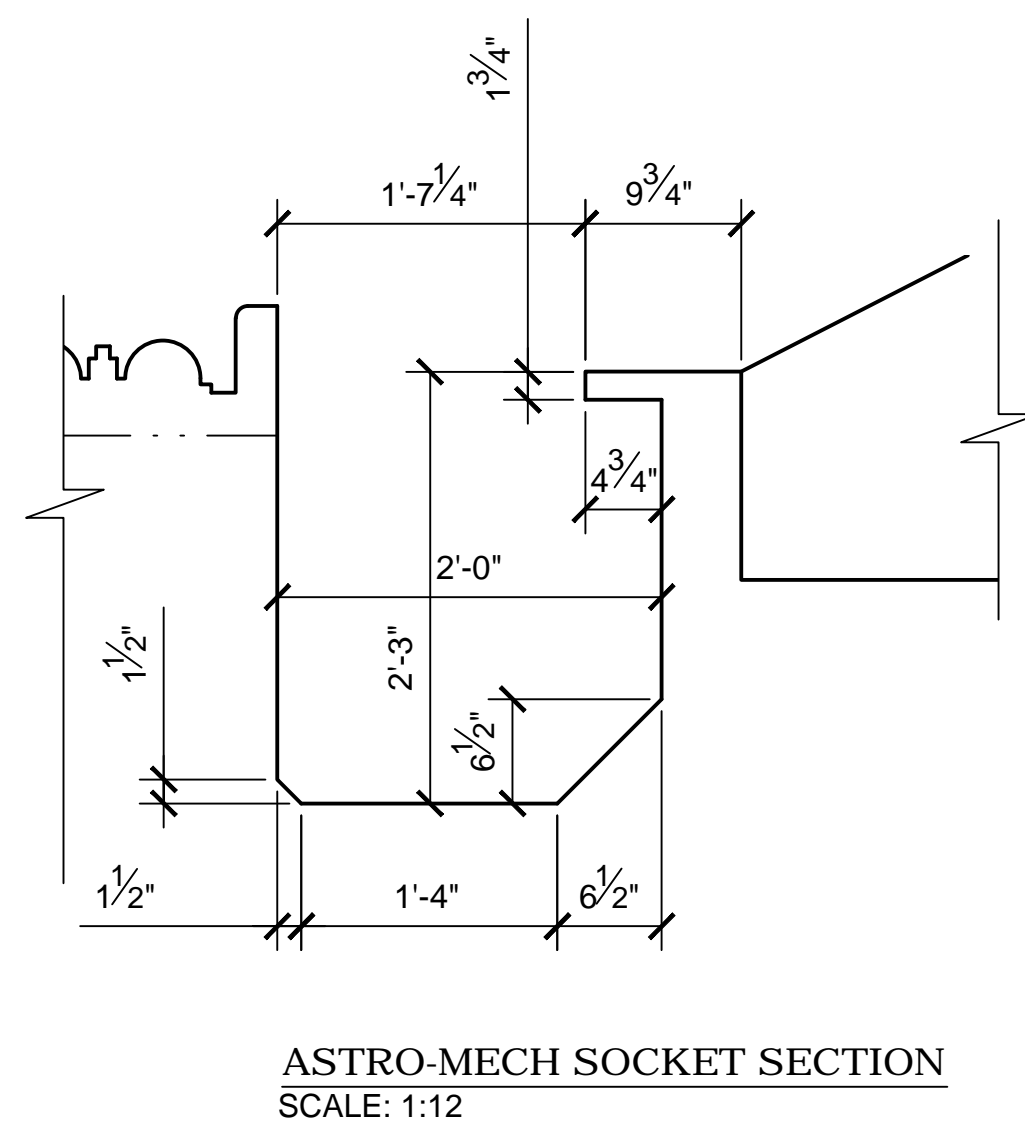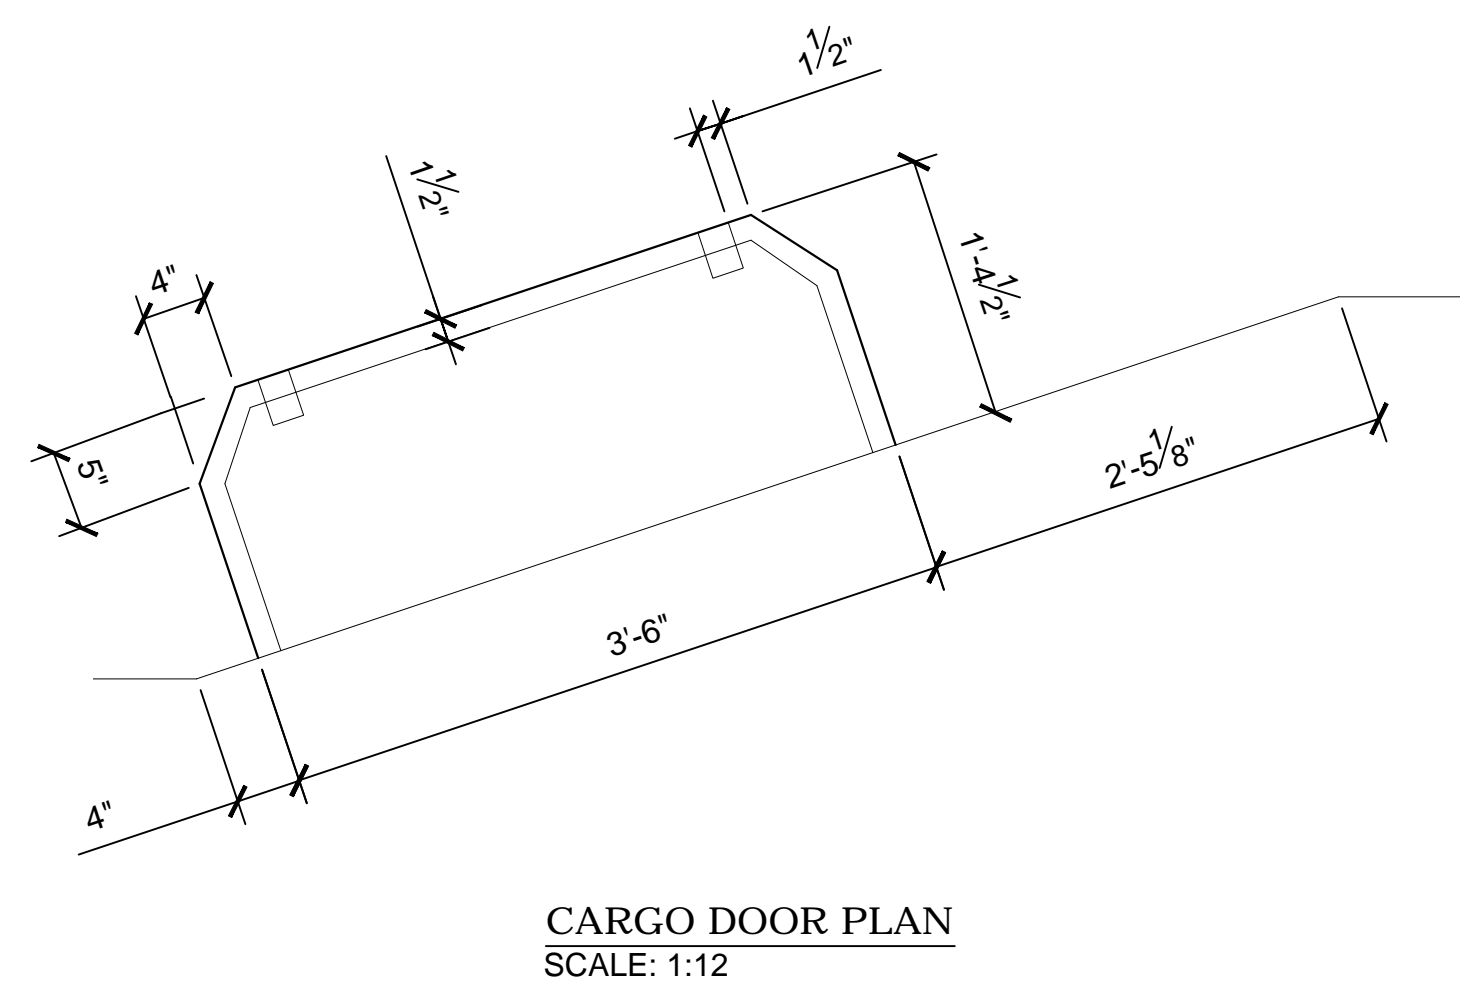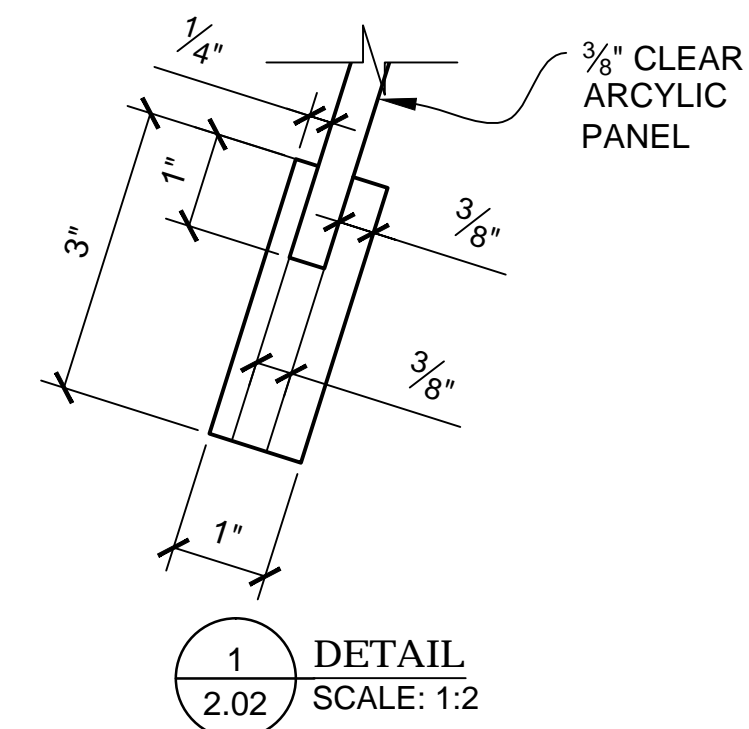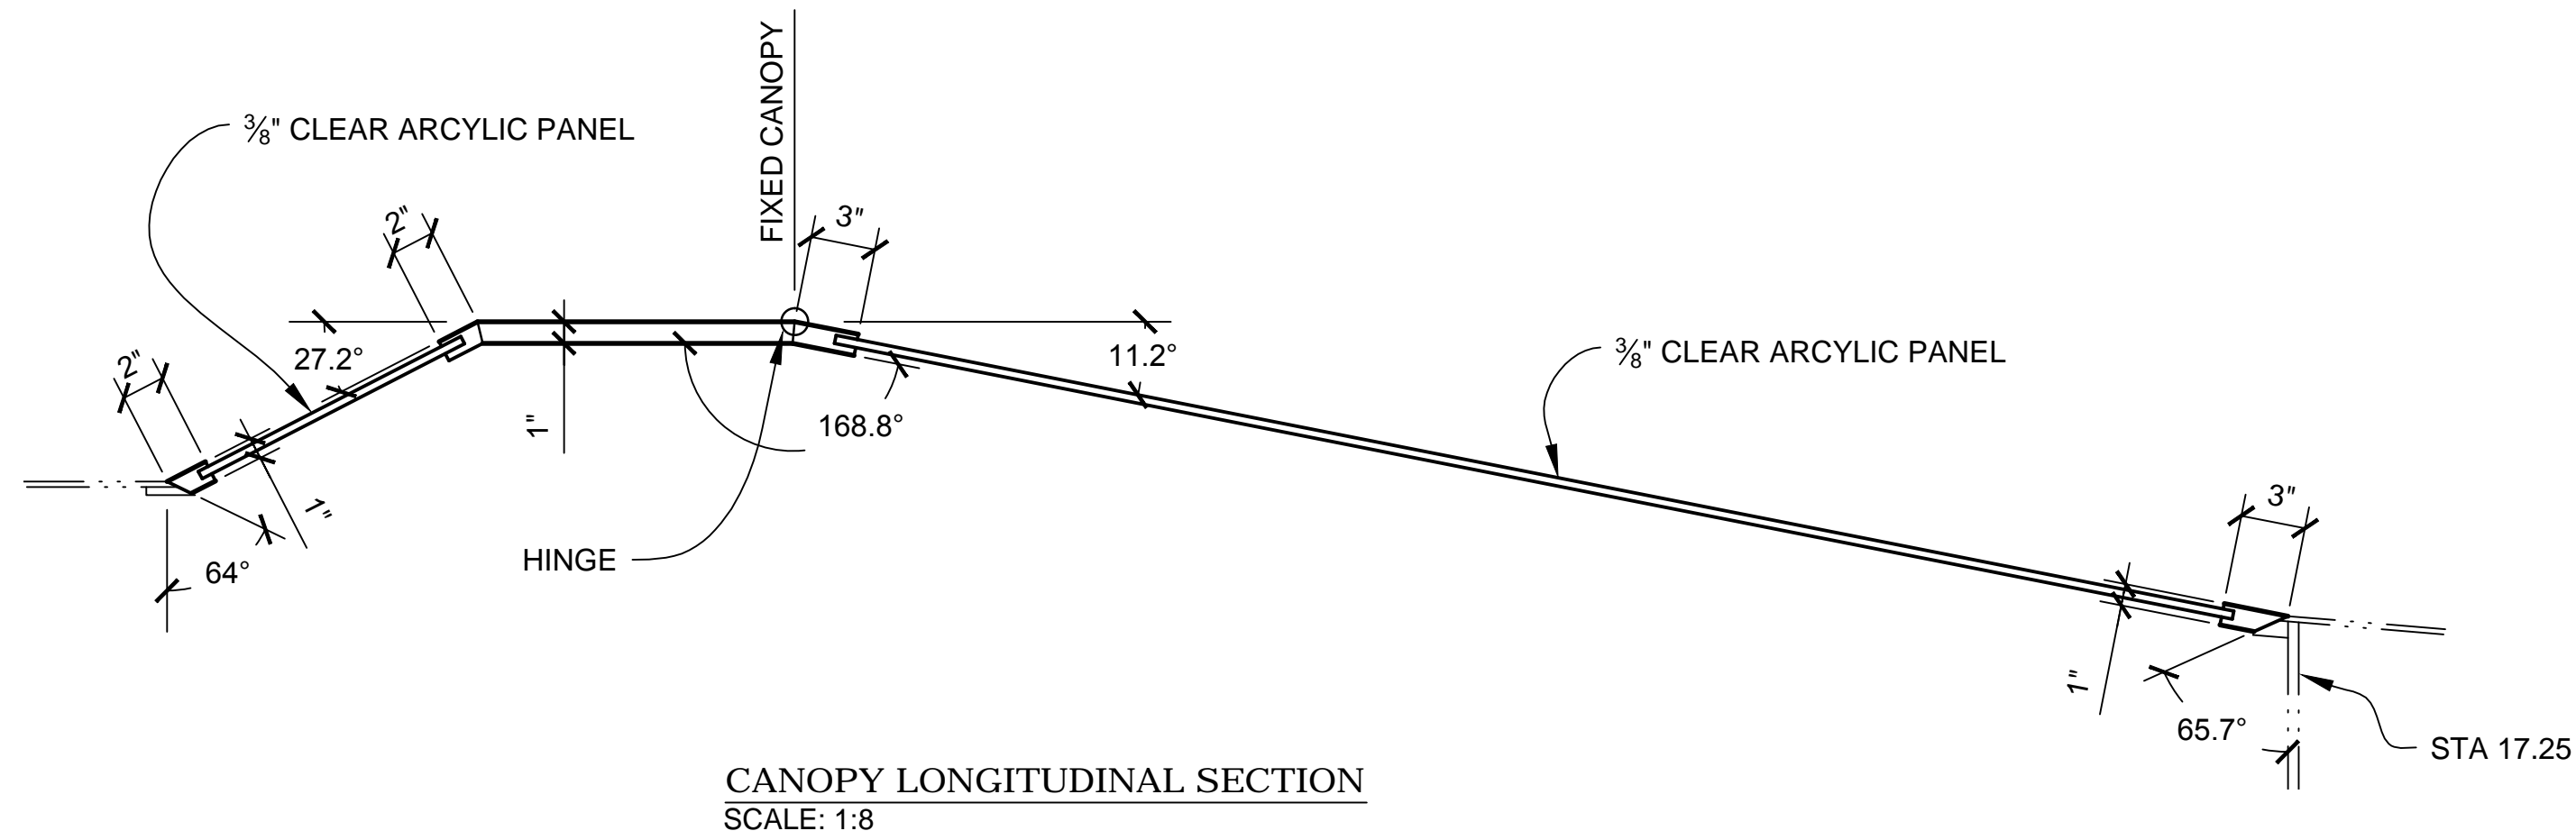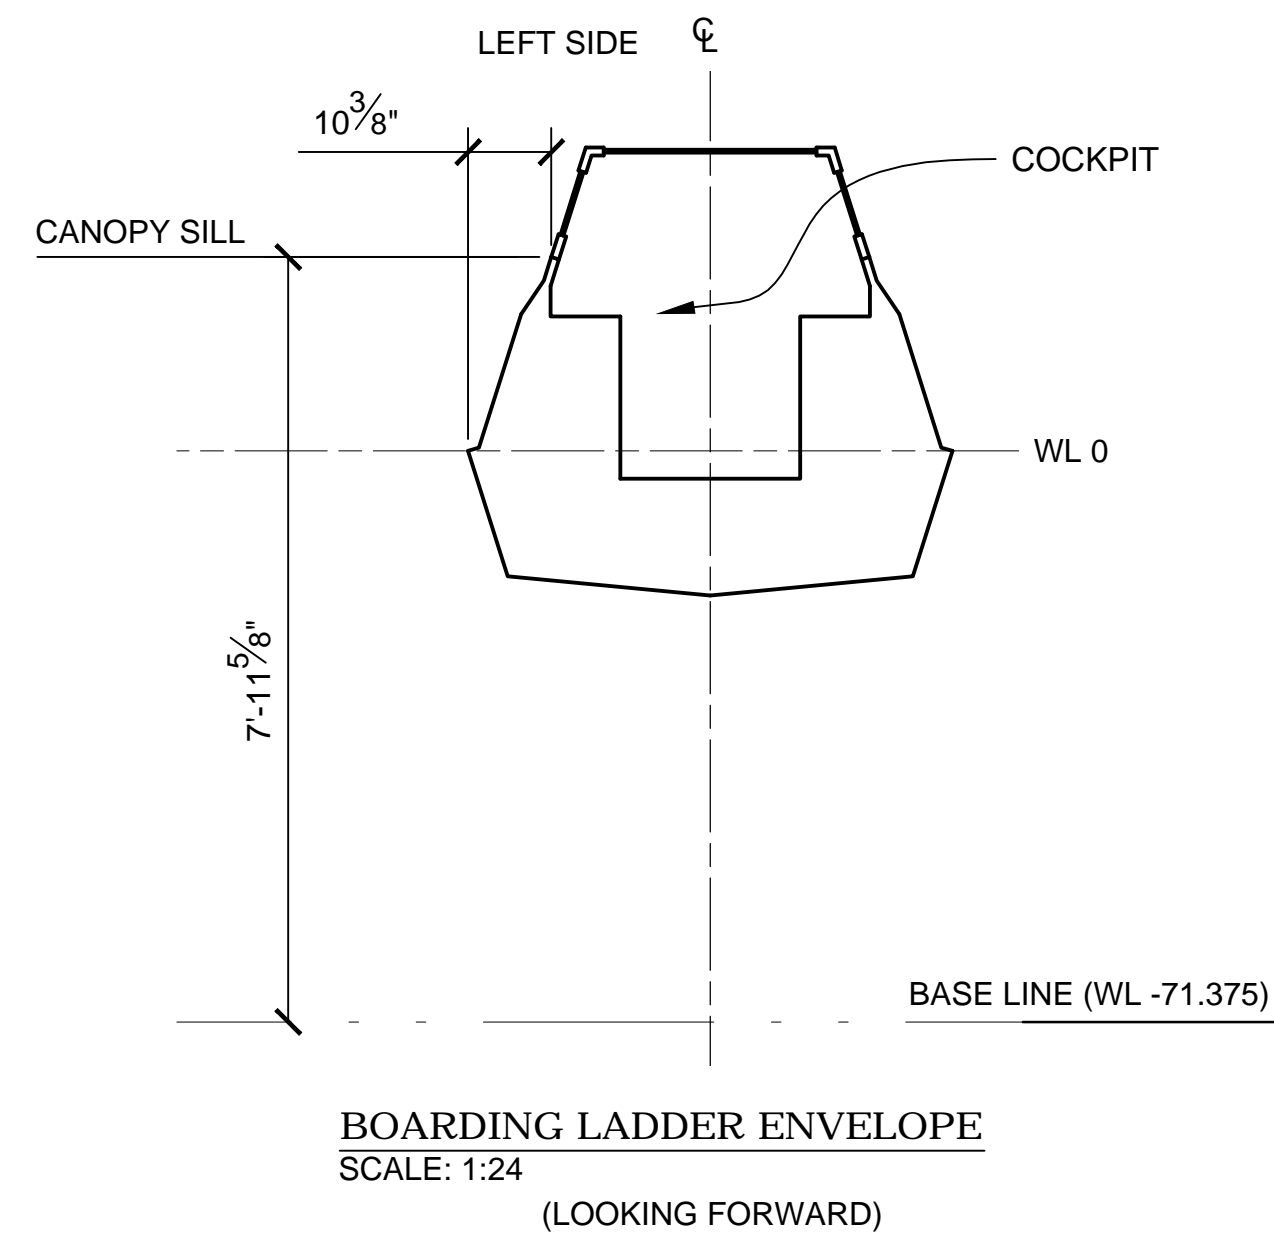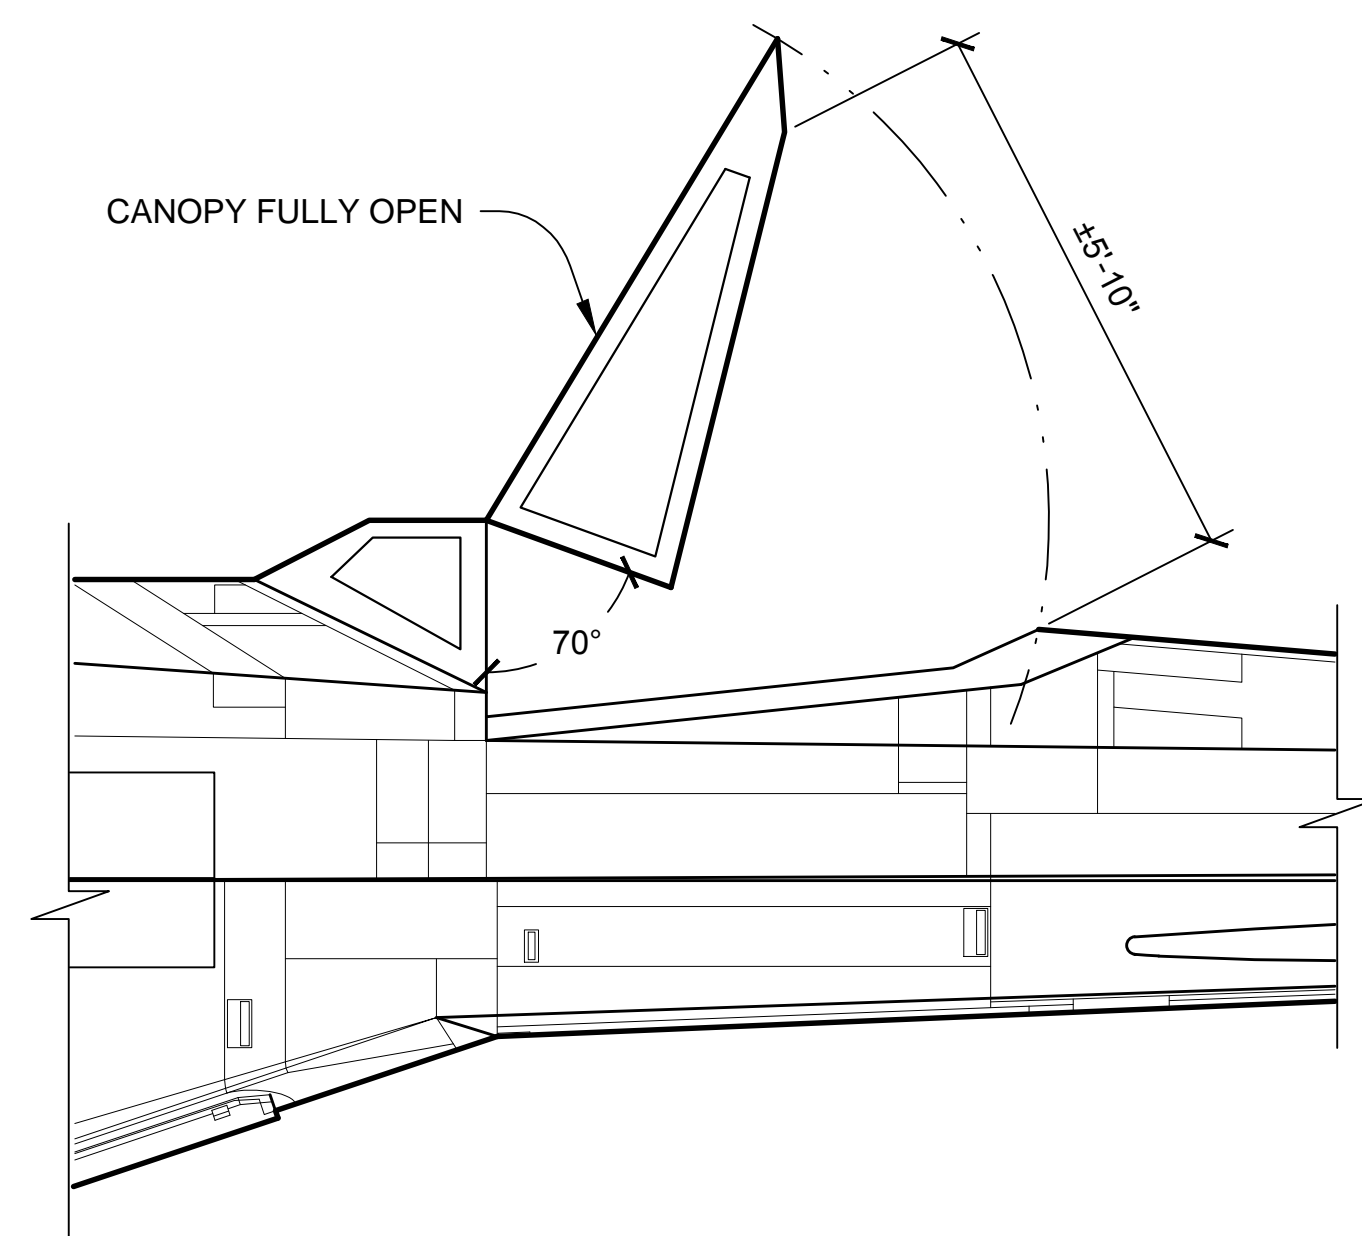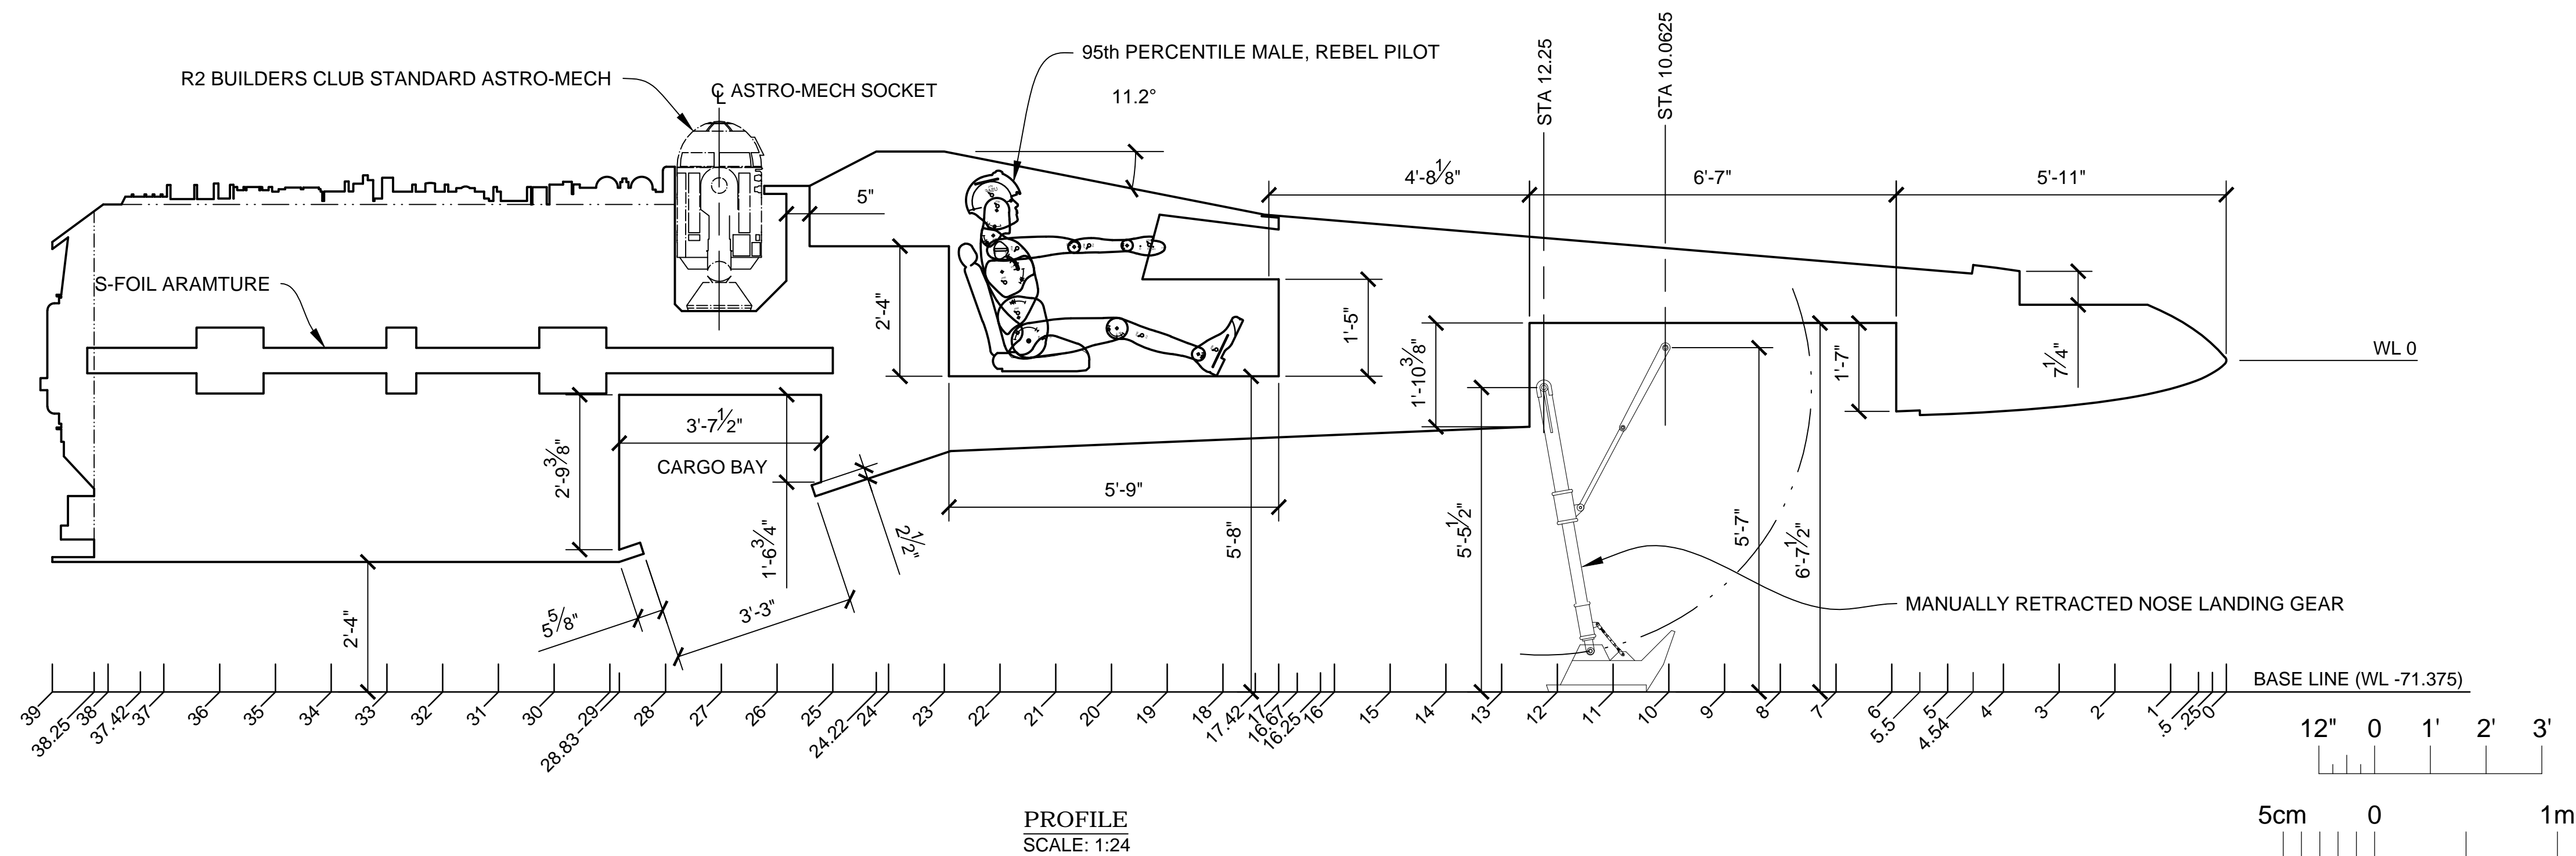


NOTES:

1. PREEXISTING MATERIAL COPYRIGHTED BY THE STAR WARS CORPORATION AND LUCASFILM LTD.

PRODUCTION	D.O.P.	ART DIRECTOR	CAMERA
ART DEPT.	SET DESIGNER	SCULPTOR	GRAPHICS
SET DEC.	DRAPES	PROPS	MODEL SHOP
CONST. COORD.	CARPENTER	PLASTER	PAINT
GREENS	SCENIC	METALS	SFX
GRIP	ELECTRICAL	VFX	CGI


PROJECT		<h1>THE X-WING BUILD</h1> <h2>1:1 SCALE STATE PROP</h2>	
SET		SET NO.	
TITLE		<h3>FUSELAGE DETAILS</h3>	
PROD DESIGNER		DATE DRAWN 3/SEP/2012	
DRAWN BY B.J.S.	APPROVED BY	DATE ISSUED DD/MMM/YYYY	
STAGE	LOCATION	DWG NO. 2.02	
FILE	X-WING LINES MASTER.DWG	SHEET	4 OF XX

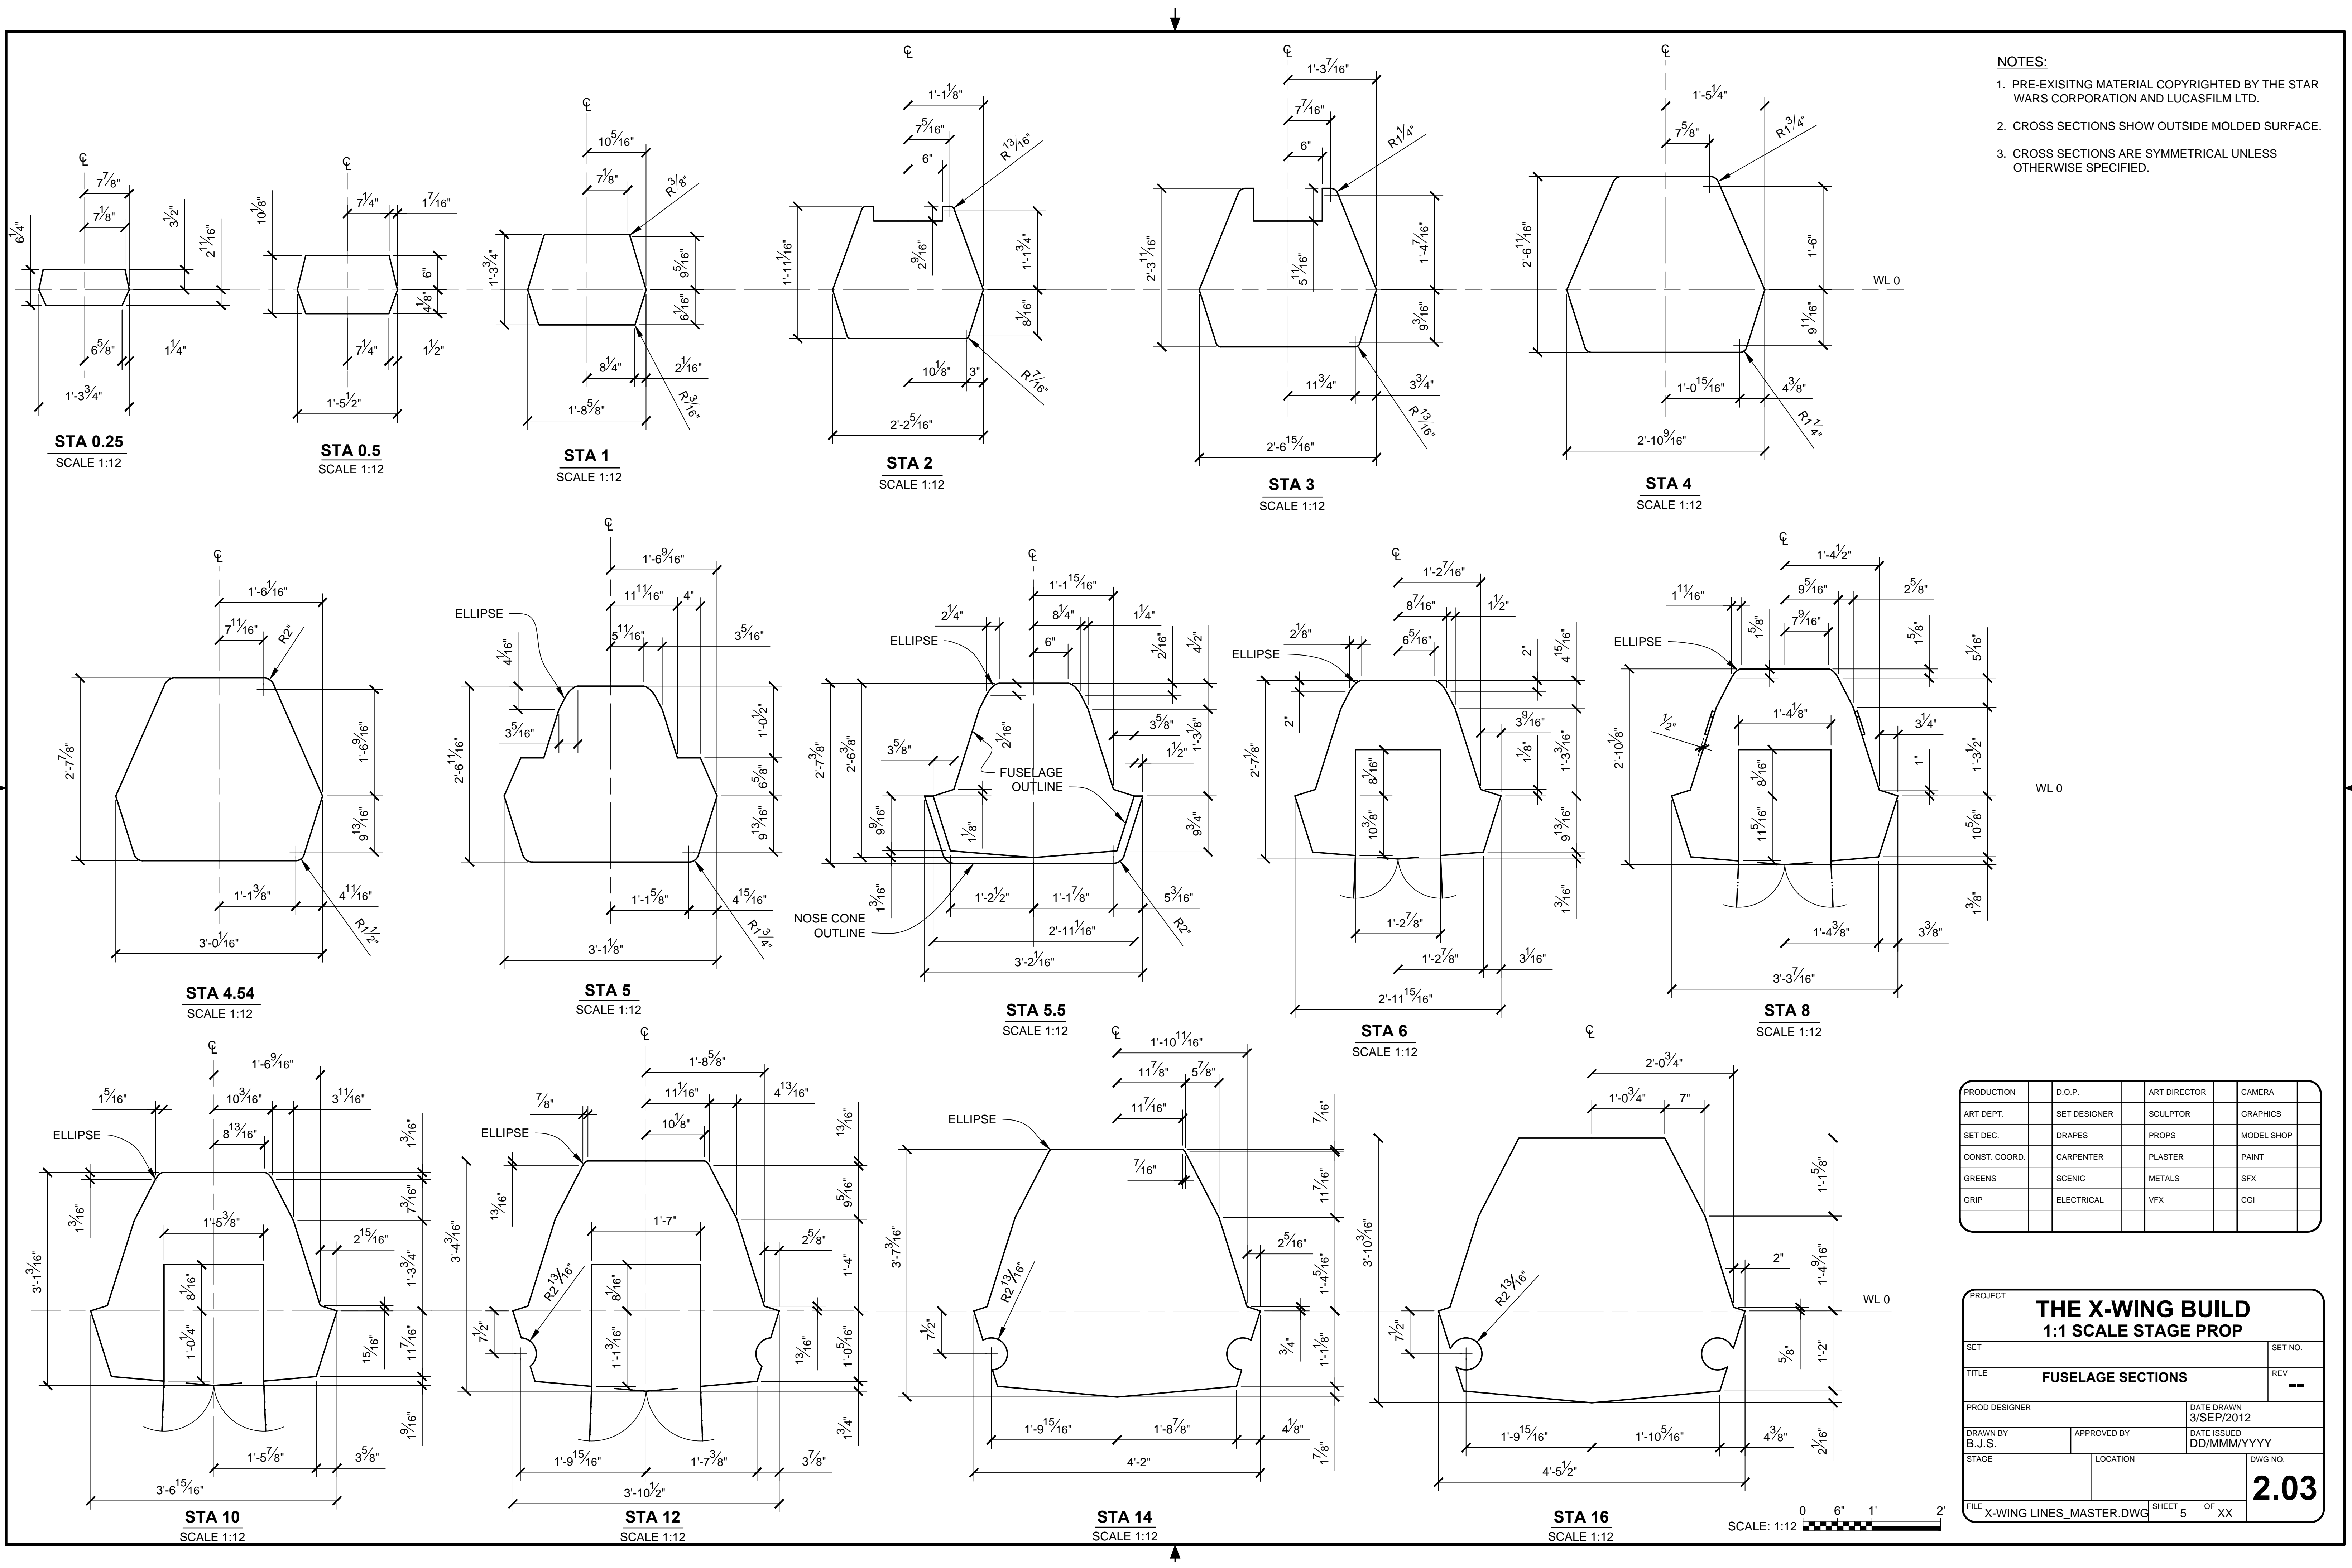


- NOTES:
- PRE-EXISTING MATERIAL COPYRIGHTED BY THE STAR WARS CORPORATION AND LUCASFILM LTD.
 - CROSS SECTIONS SHOW OUTSIDE MOLDED SURFACE.
 - CROSS SECTIONS ARE SYMMETRICAL UNLESS OTHERWISE SPECIFIED.

PRODUCTION	D.O.P.	ART DIRECTOR	CAMERA
ART DEPT.	SET DESIGNER	SCULPTOR	GRAPHICS
SET DEC.	DRAPES	PROPS	MODEL SHOP
CONST. COORD.	CARPENTER	PLASTER	PAINT
GREENS	SCENIC	METALS	SFX
GRIP	ELECTRICAL	VFX	CGI


PROJECT			
THE X-WING BUILD			
1:1 SCALE STAGE PROP			
SET			SET NO.
TITLE			REV
FUSELAGE SECTIONS			--
PROD DESIGNER		DATE DRAWN	
		3/SEP/2012	
DRAWN BY	APPROVED BY	DATE ISSUED	
B.J.S.		DD/MM/YYYY	
STAGE	LOCATION		DWG NO.
			2.03
FILE	X-WING LINES_MASTER.DWG	SHEET	5 OF XX

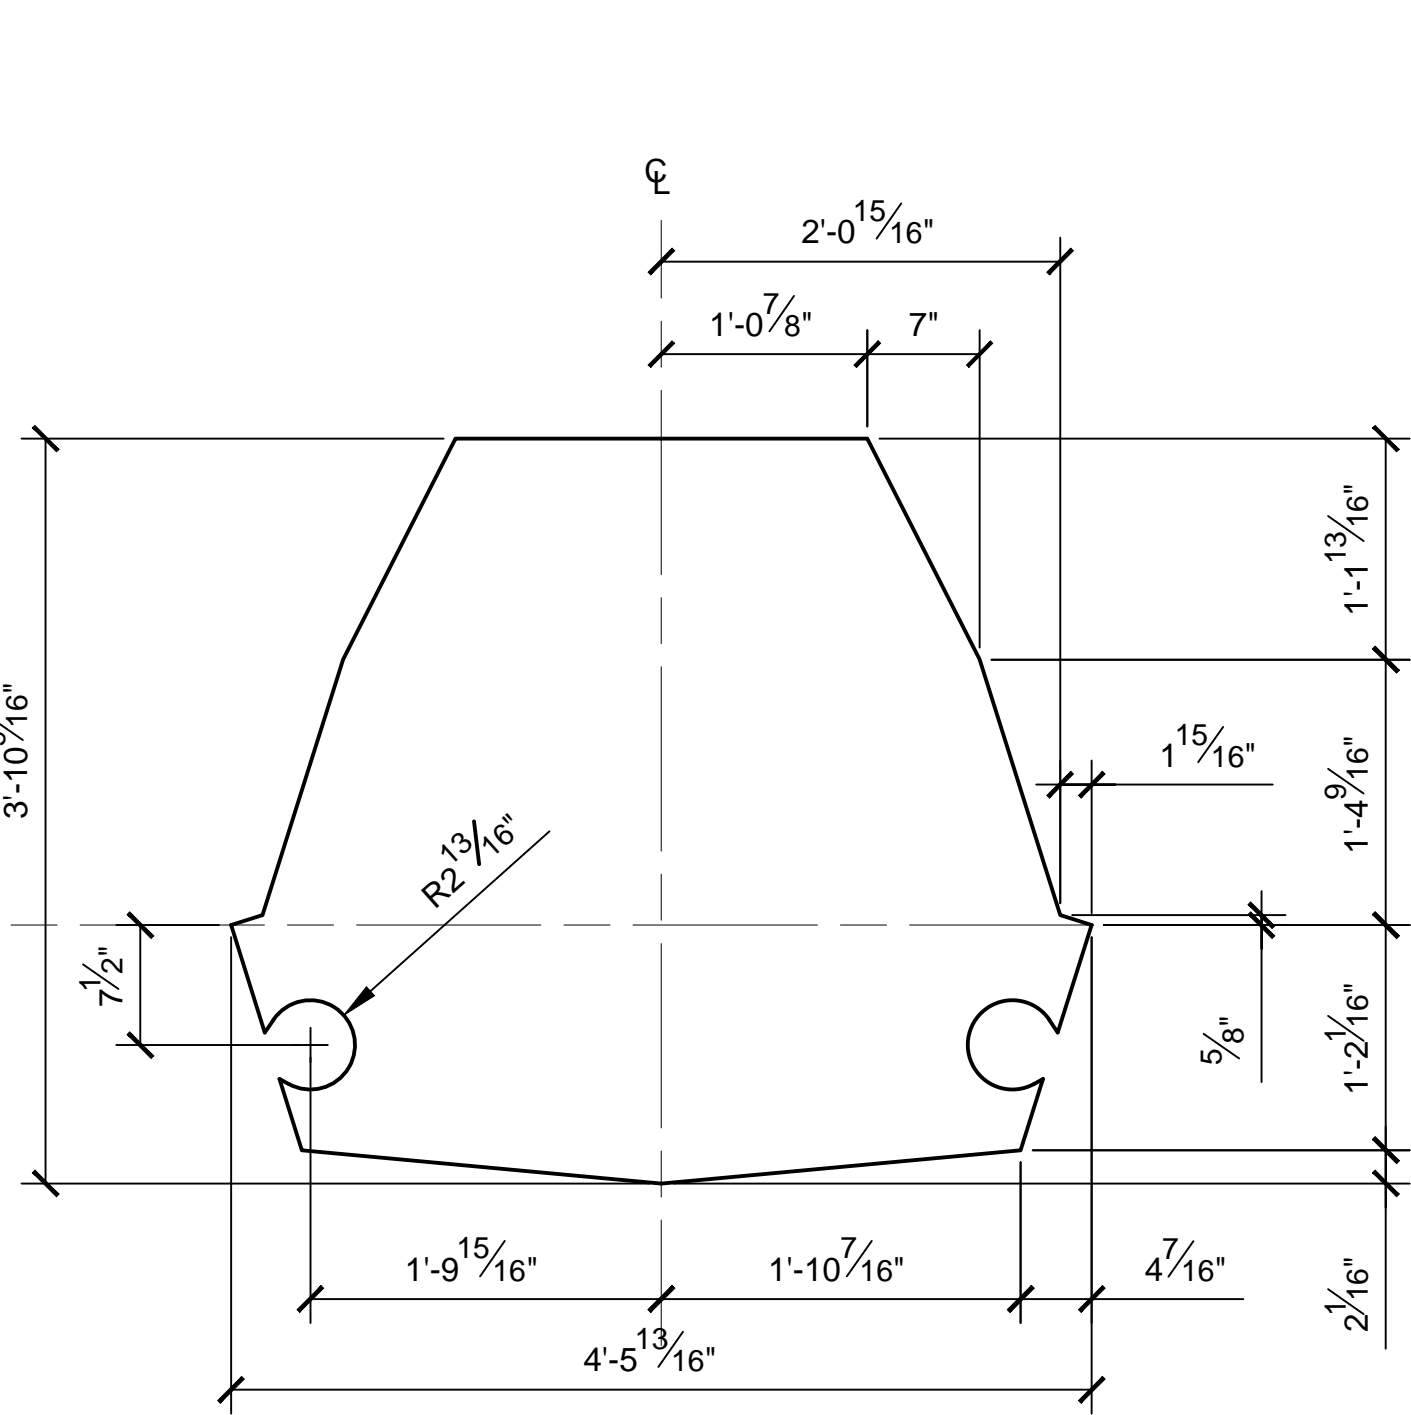


STA 16.25
SCALE 1:12

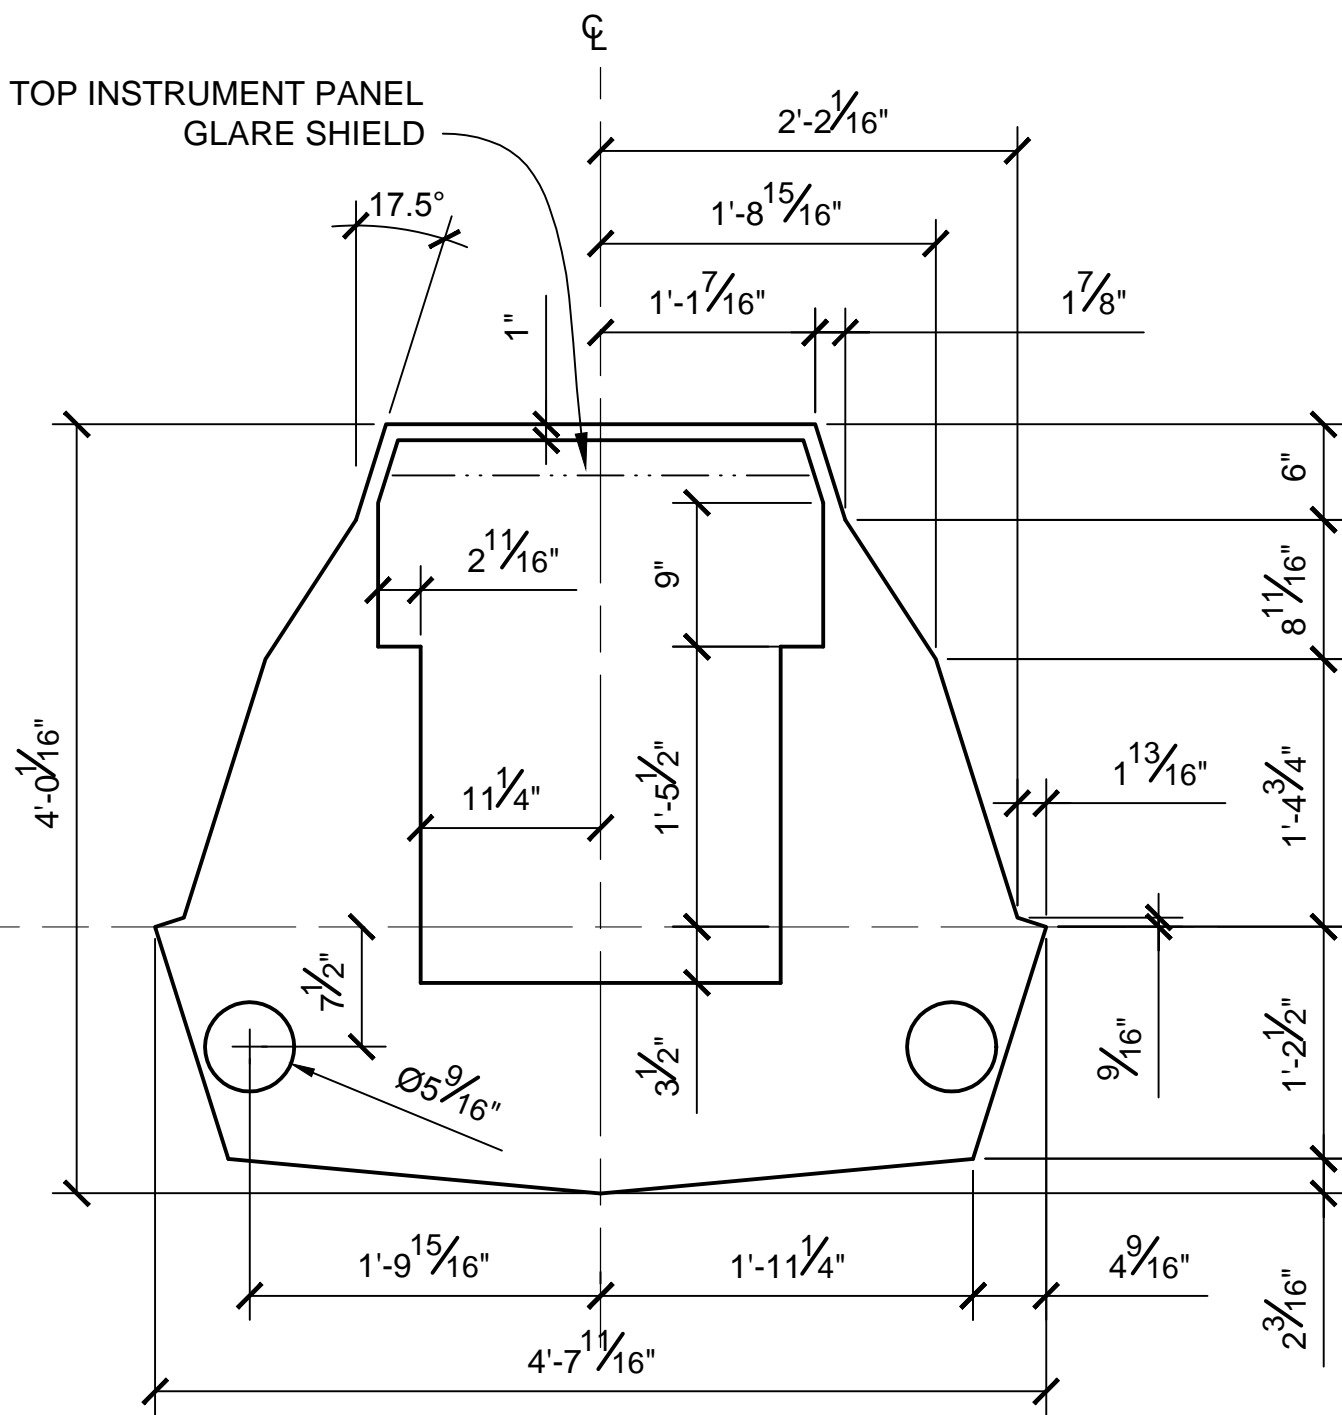


STA 17.25
SCALE 1:12

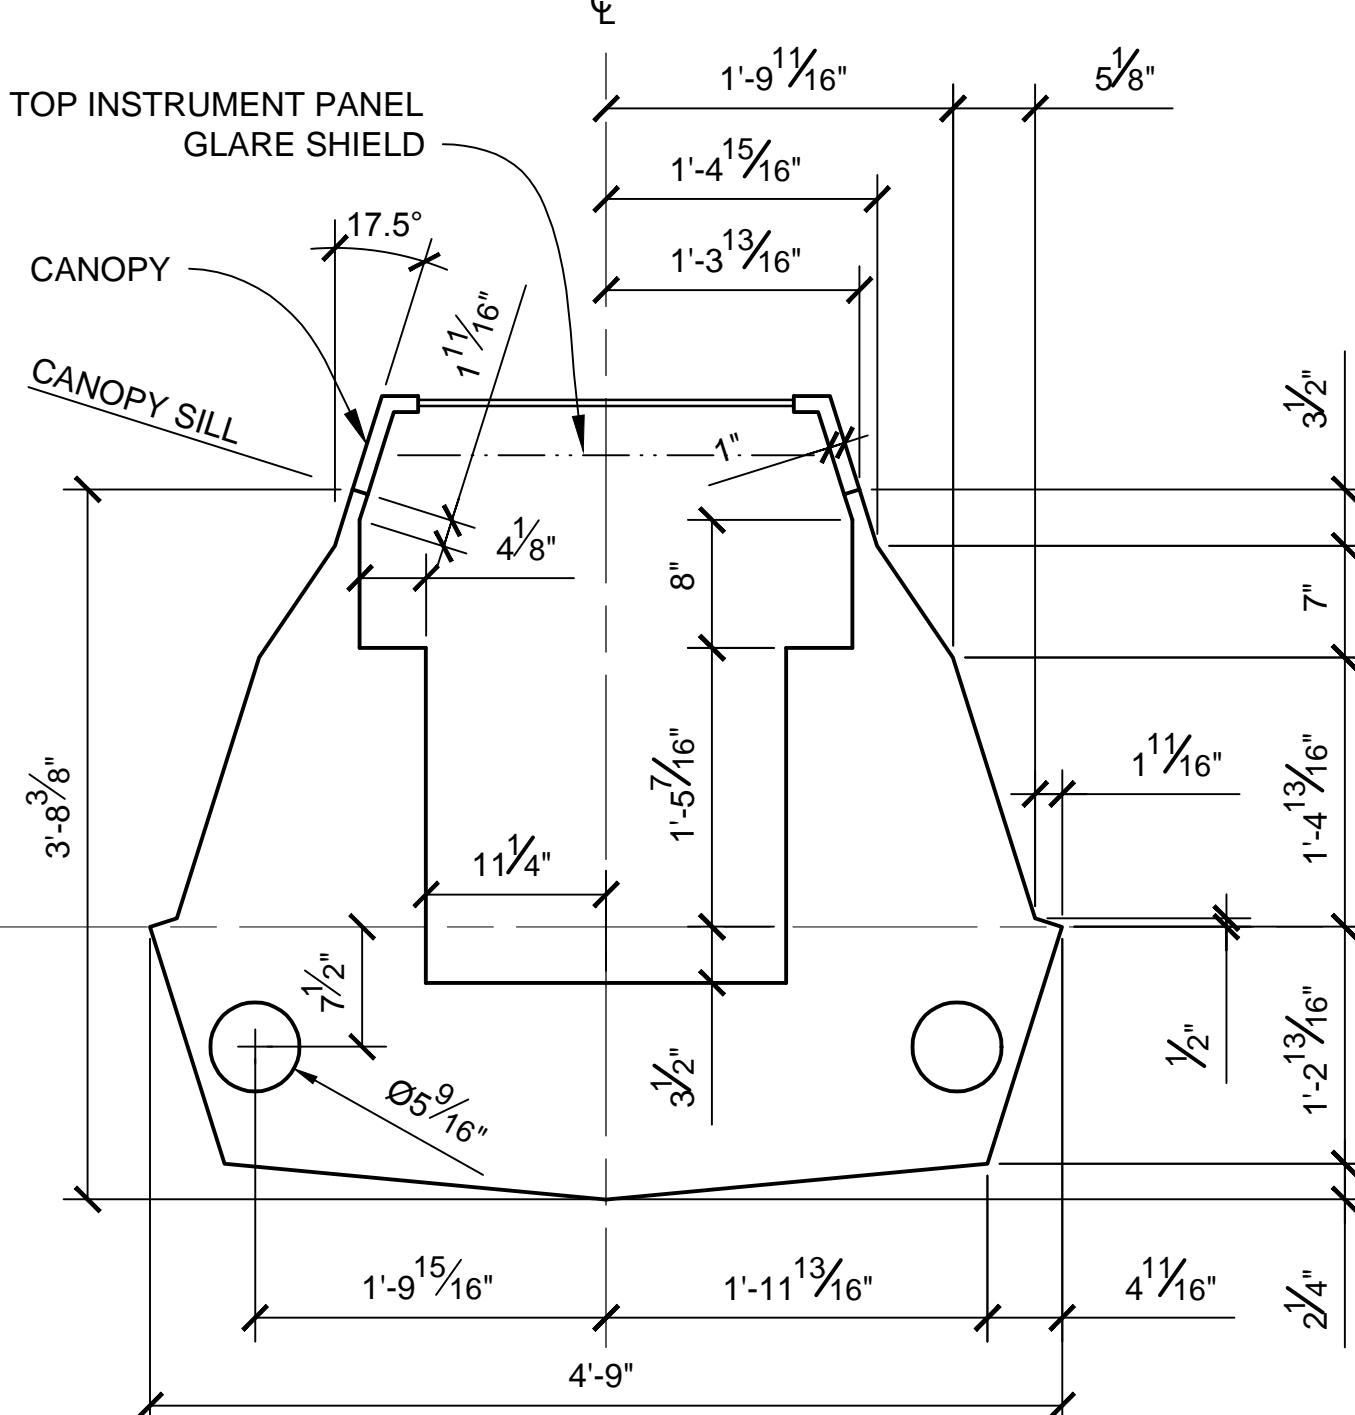


STA 18
SCALE 1:12

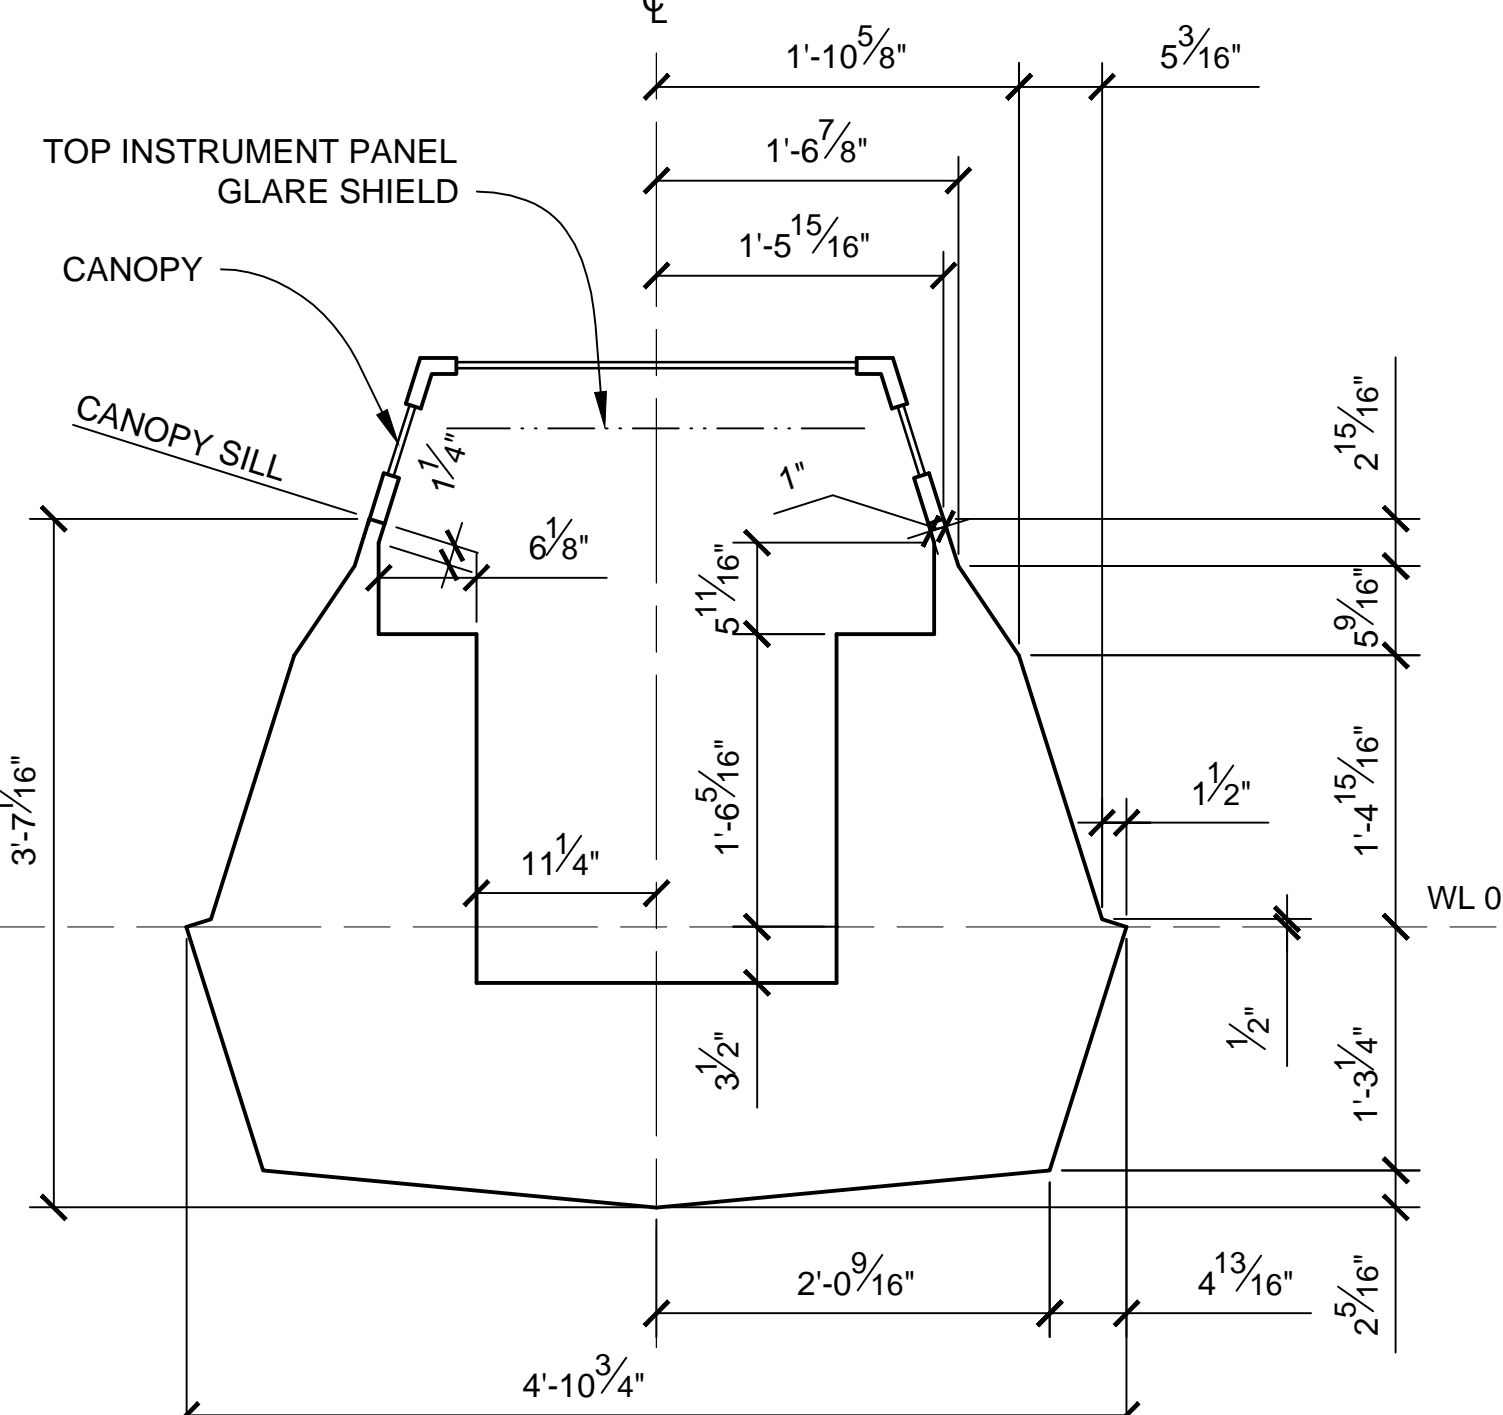


STA 19
SCALE 1:12

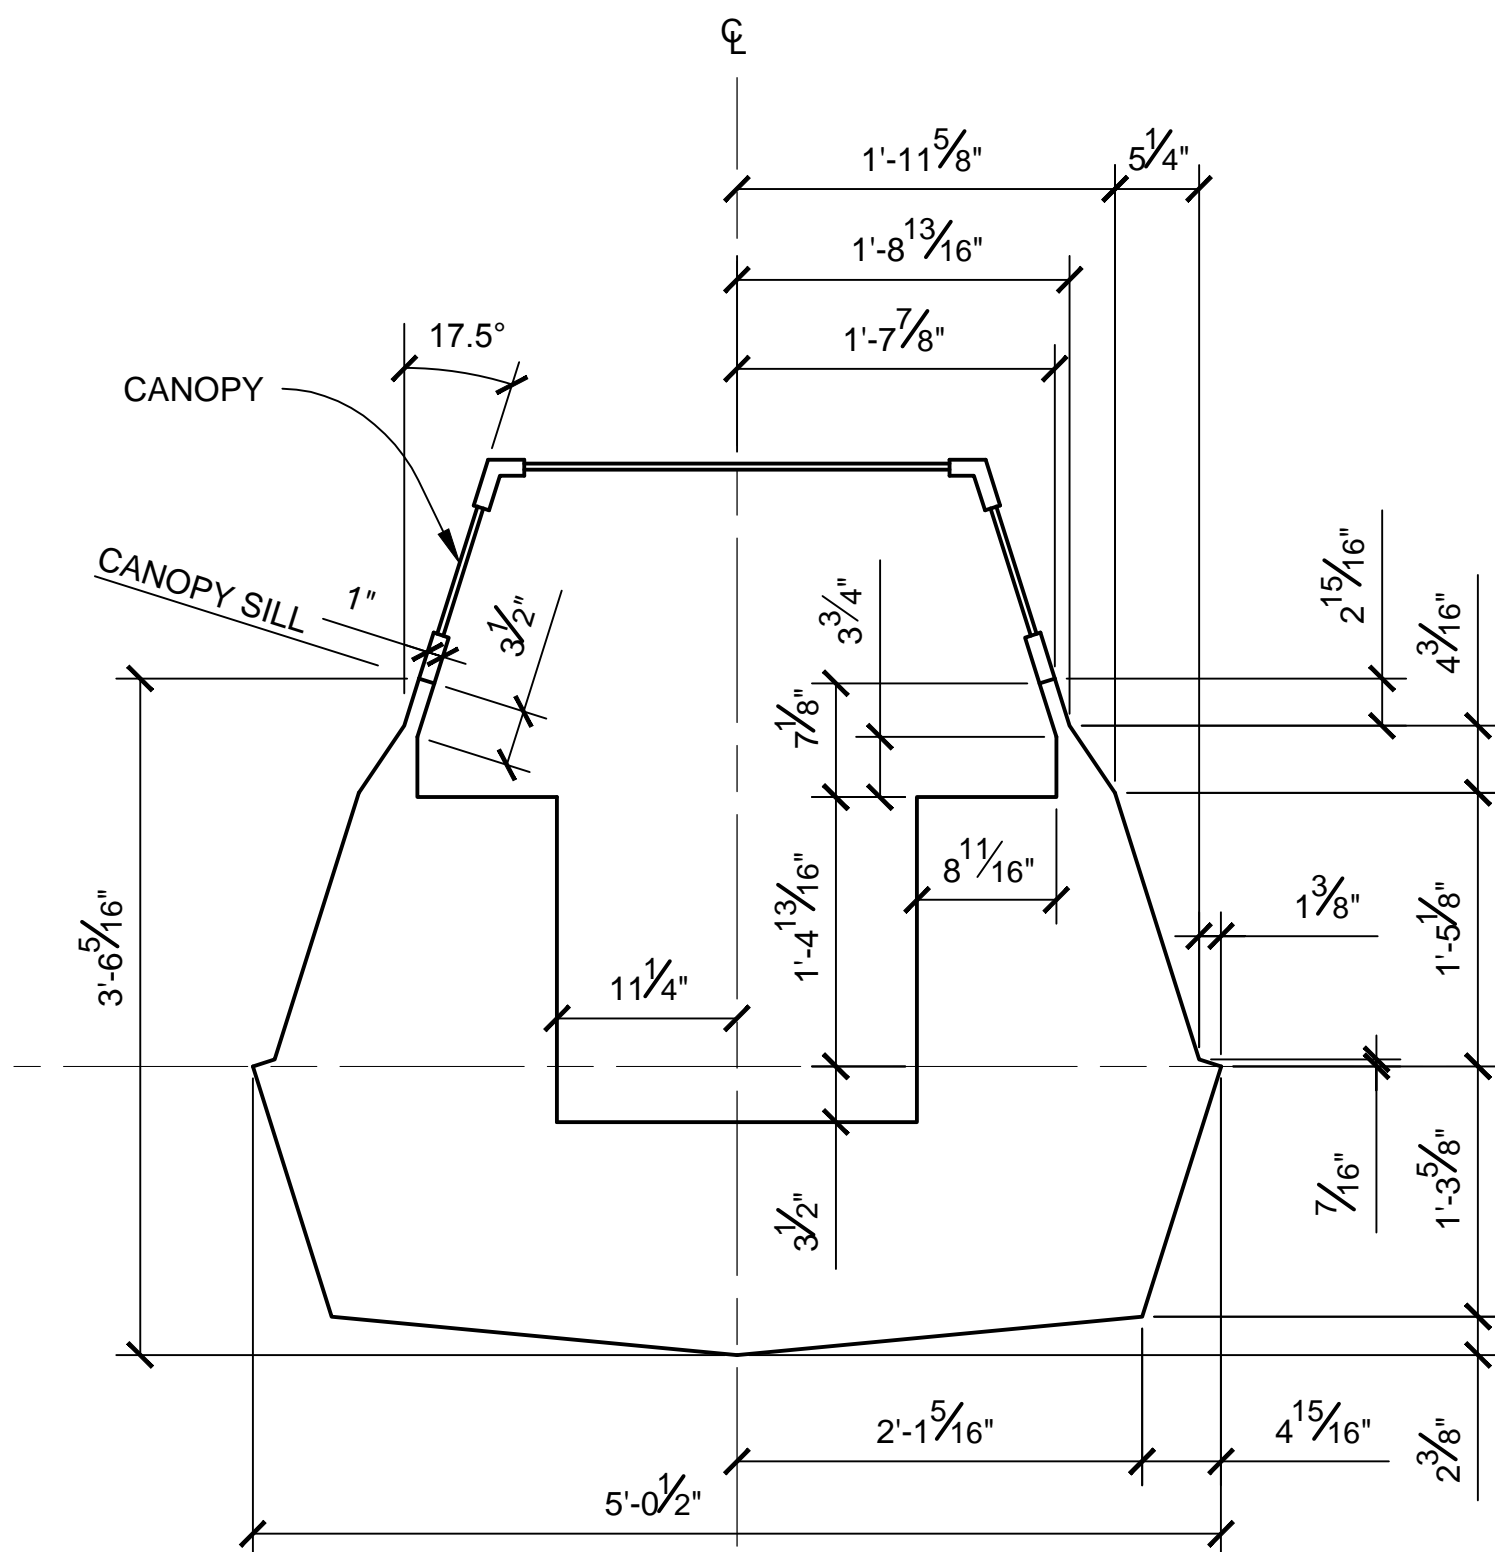


STA 20
SCALE 1:12

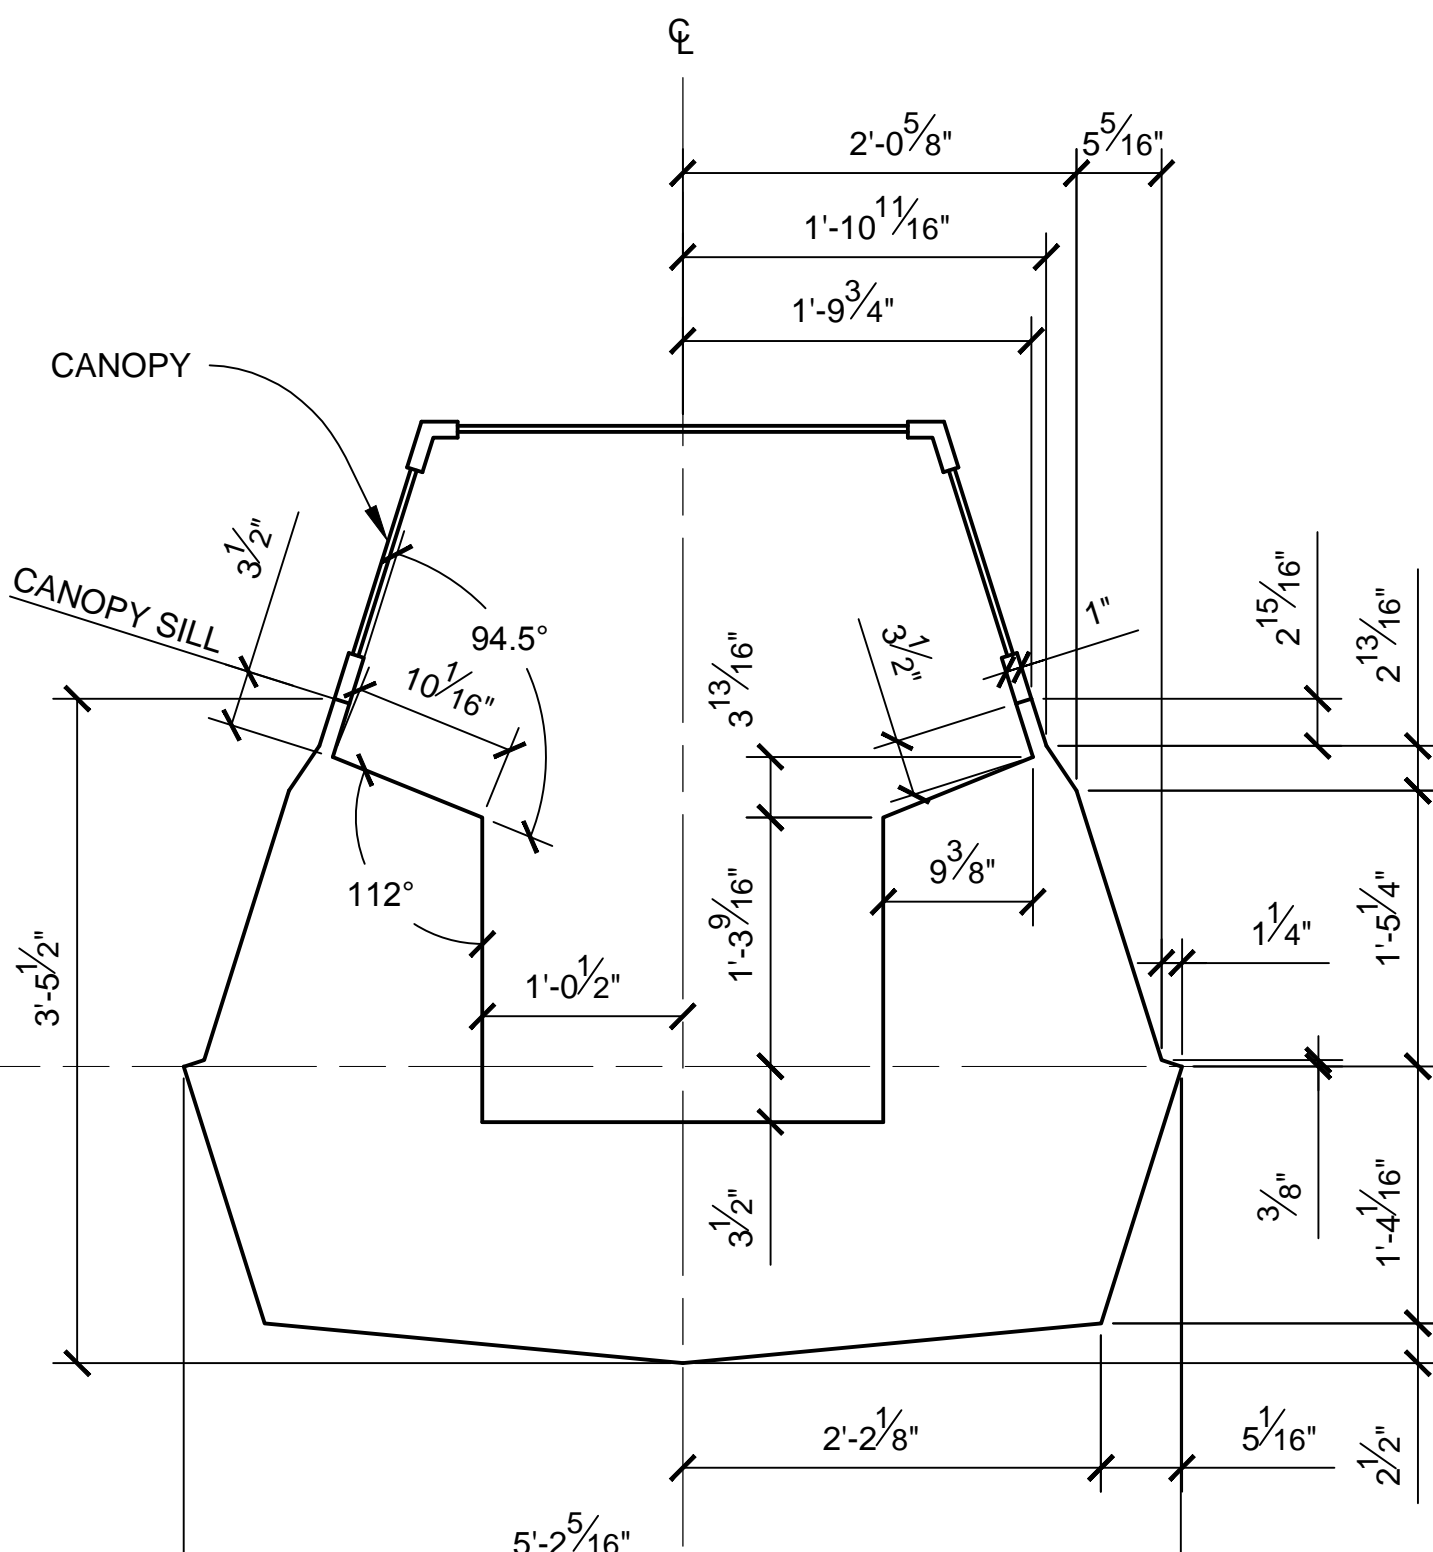

STA 21
SCALE 1:12

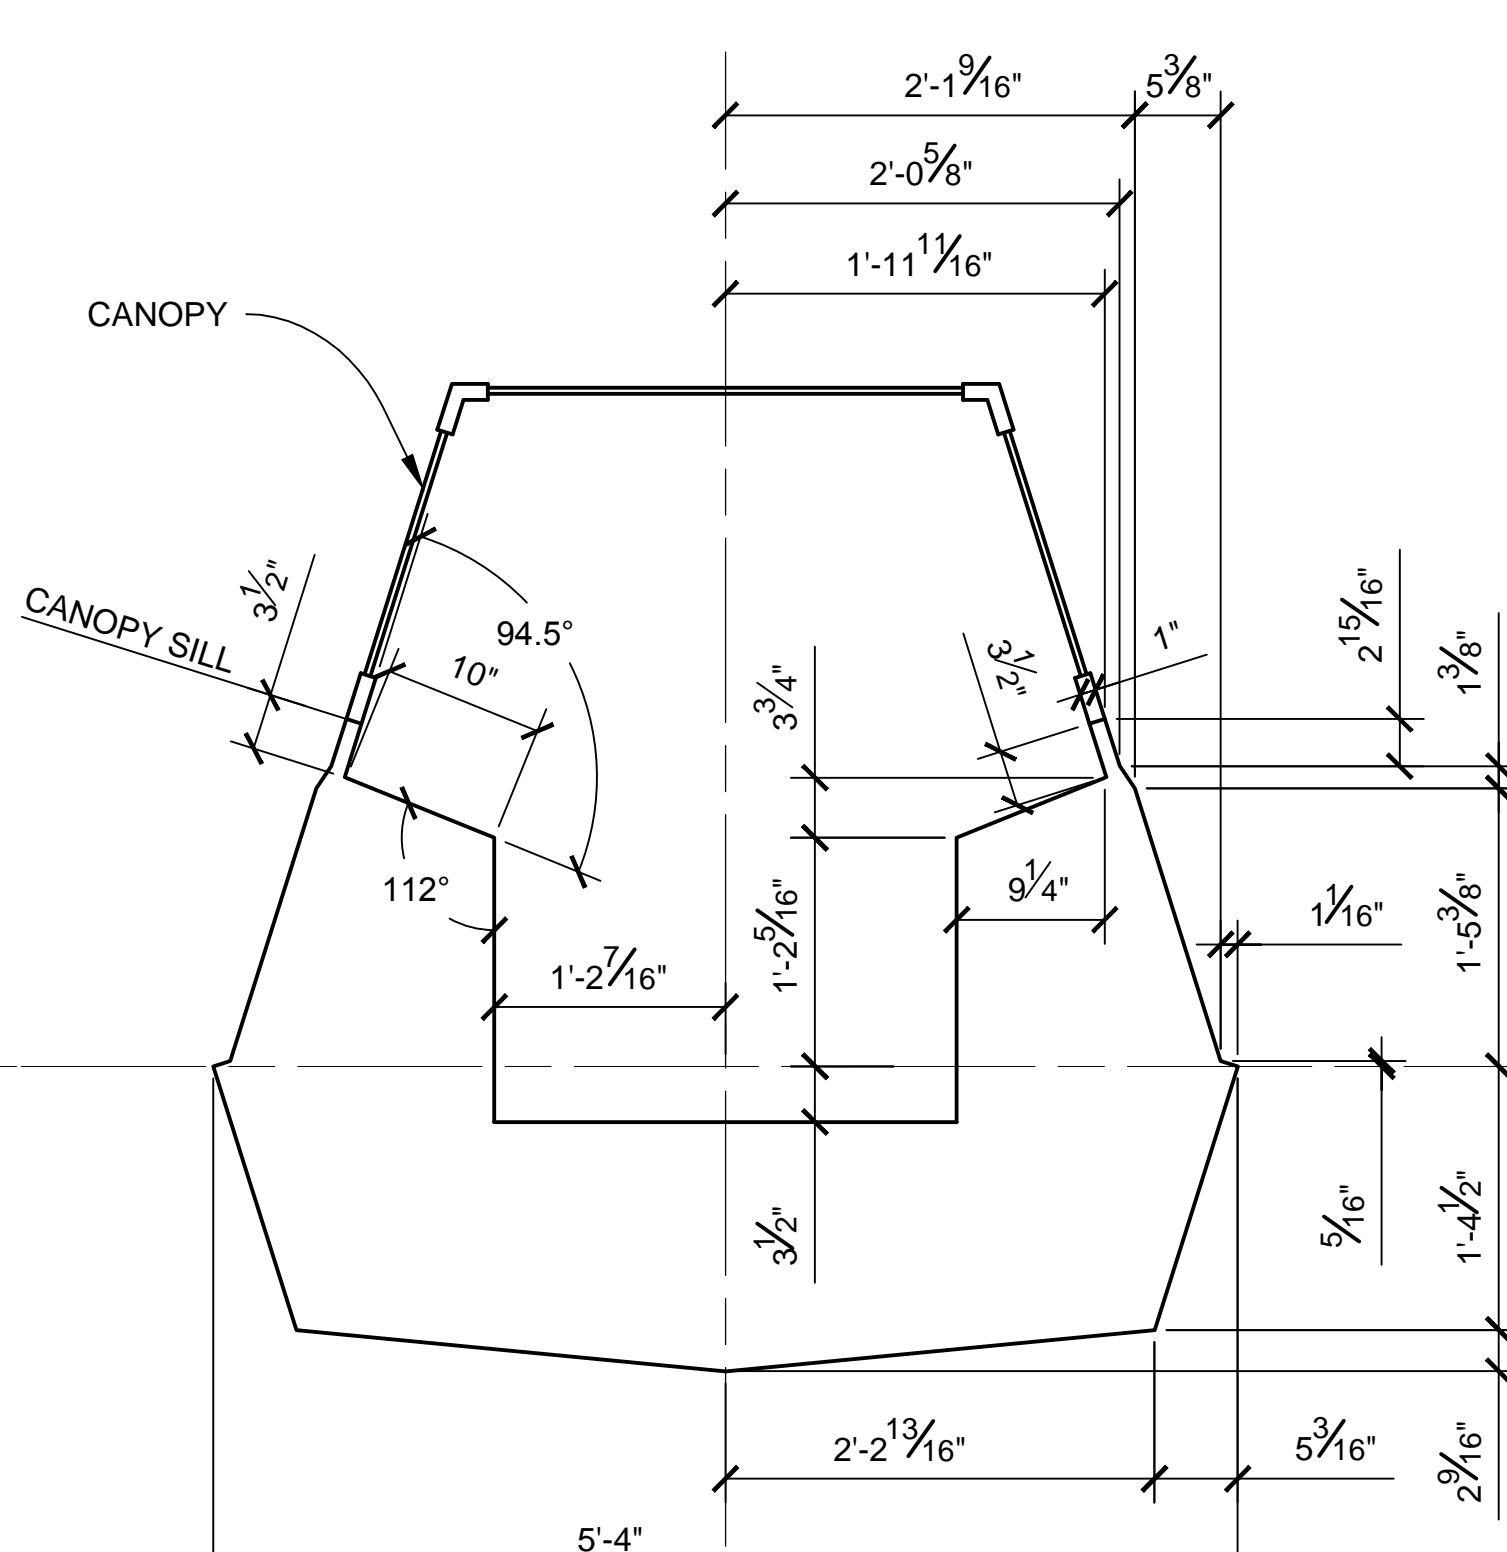

STA 22
SCALE 1:12

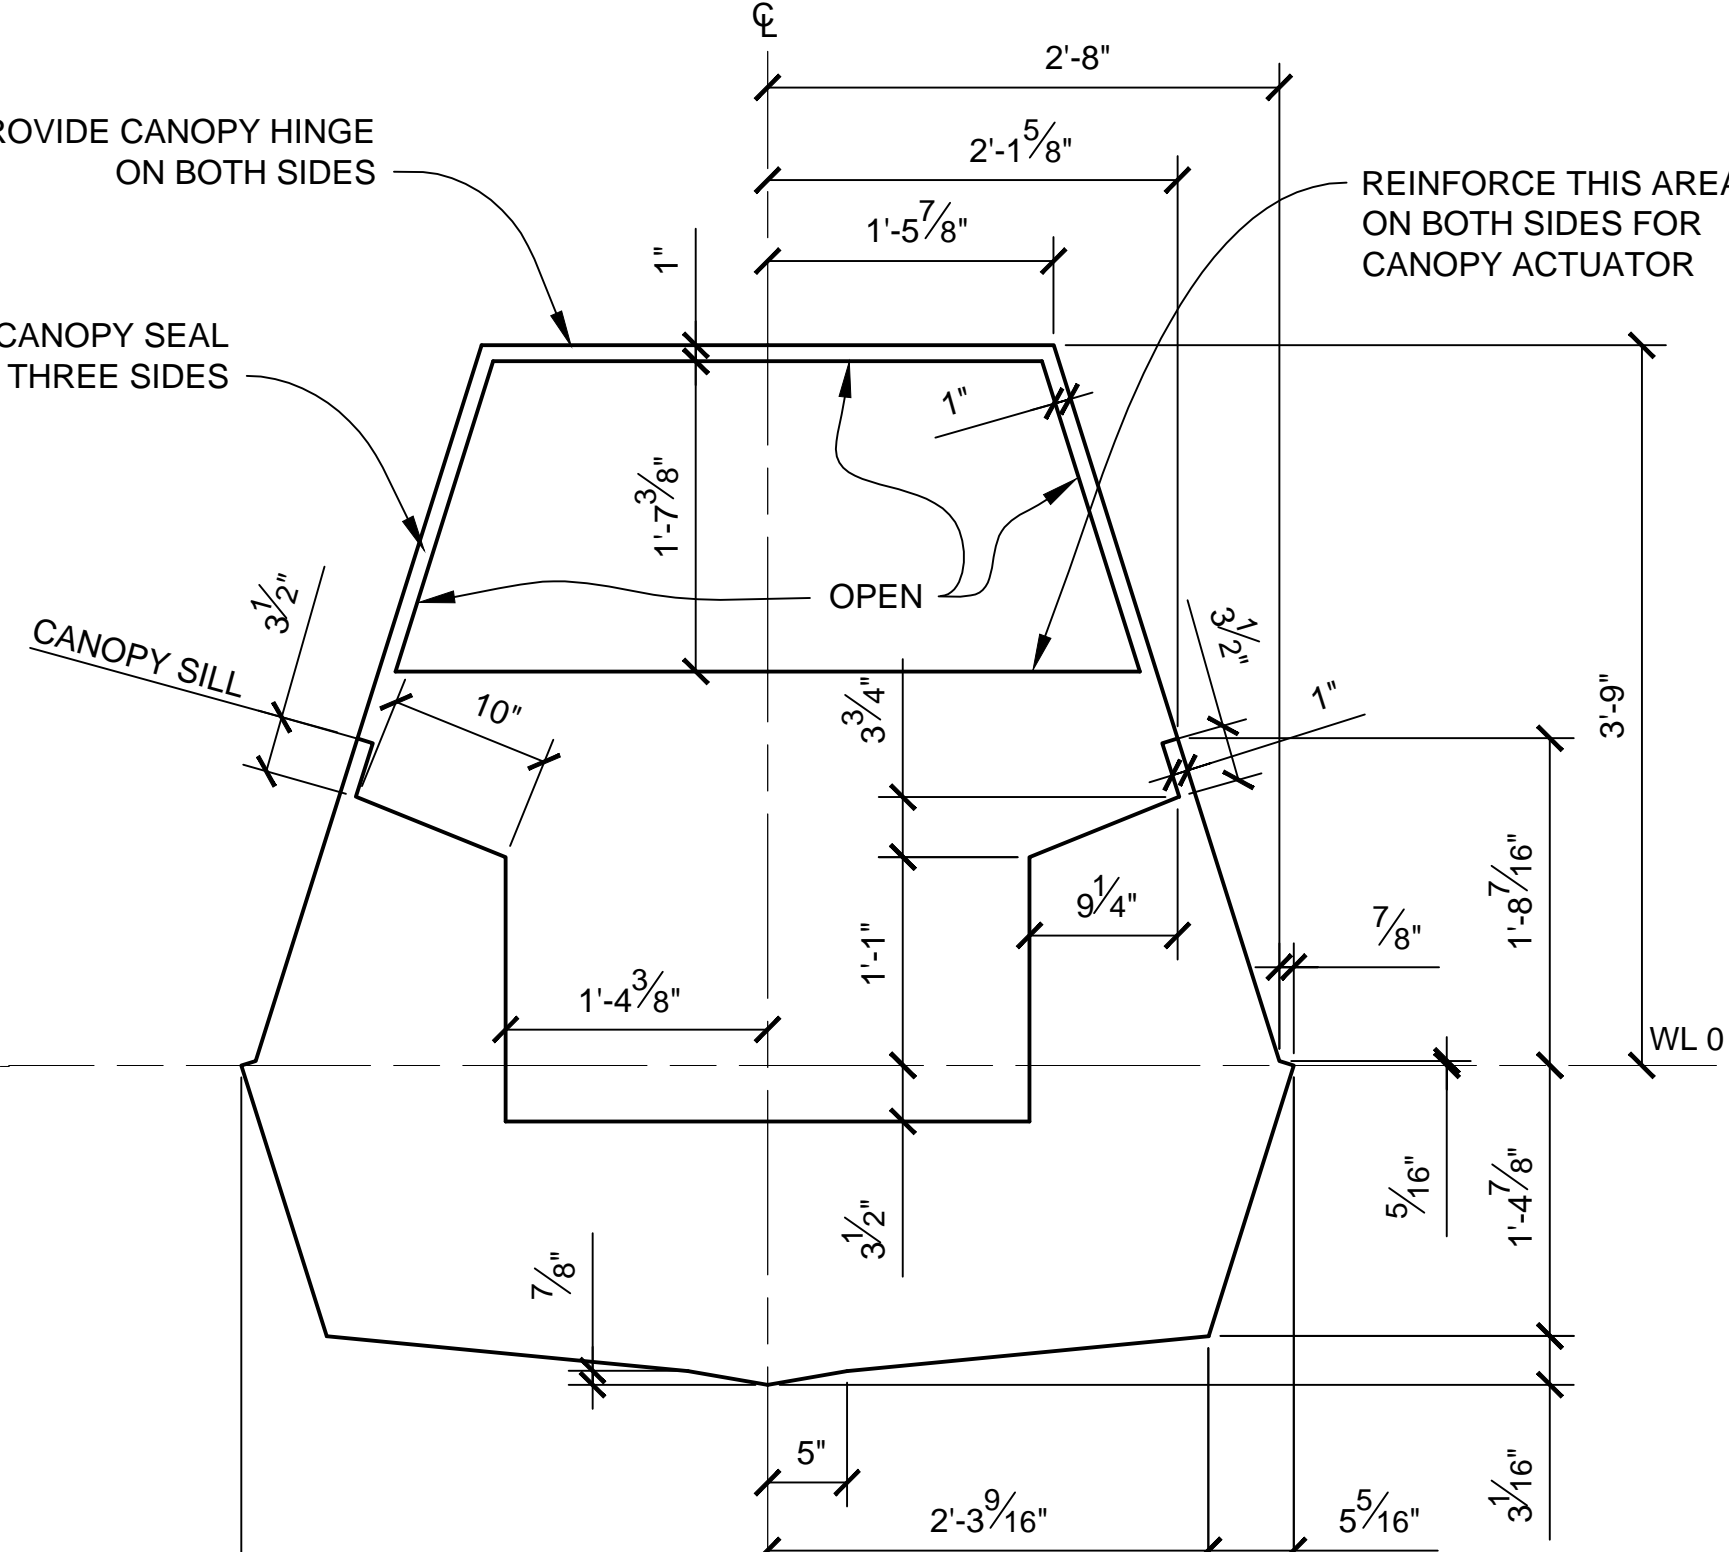


STA 23
SCALE 1:12

- NOTES:
- PRE-EXISTING MATERIAL COPYRIGHTED BY THE STAR WARS CORPORATION AND LUCASFILM LTD.
 - CROSS SECTIONS SHOW OUTSIDE MOLDED SURFACE.
 - CROSS SECTIONS ARE SYMMETRICAL UNLESS OTHERWISE SPECIFIED.
 - INSTRUMENT PANEL AND RUDDER PEDALS ARE NOT SHOWN.
 - SECTIONS 18, 19, 20, 21, 22 AND 23 SHOW "EMPIRE STRIKES BACK" COCKPIT SECTIONS. SEE DWG NO. 2.13 FOR "A NEW HOPE" COCKPIT.


PRODUCTION	D.O.P.	ART DIRECTOR	CAMERA
ART DEPT.	SET DESIGNER	SCULPTOR	GRAPHICS
SET DEC.	DRAPES	PROPS	MODEL SHOP
CONST. COORD.	CARPENTER	PLASTER	PAINT
GREENS	SCENIC	METALS	SFX
GRIP	ELECTRICAL	VFX	CGI

SCALE: 1:12


PROJECT			
THE X-WING BUILD			
1:1 SCALE STAGE PROP			
SET			SET NO.
TITLE			REV
FUSELAGE SECTIONS			--
PROD DESIGNER		DATE DRAWN	
		3/SEP/2012	
DRAWN BY	APPROVED BY	DATE ISSUED	
B.J.S.		DD/MMM/YYYY	
STAGE	LOCATION		DWG NO.
			2.04
FILE	X-WING LINES_MASTER.DWG	SHEET	
		5	OF XX

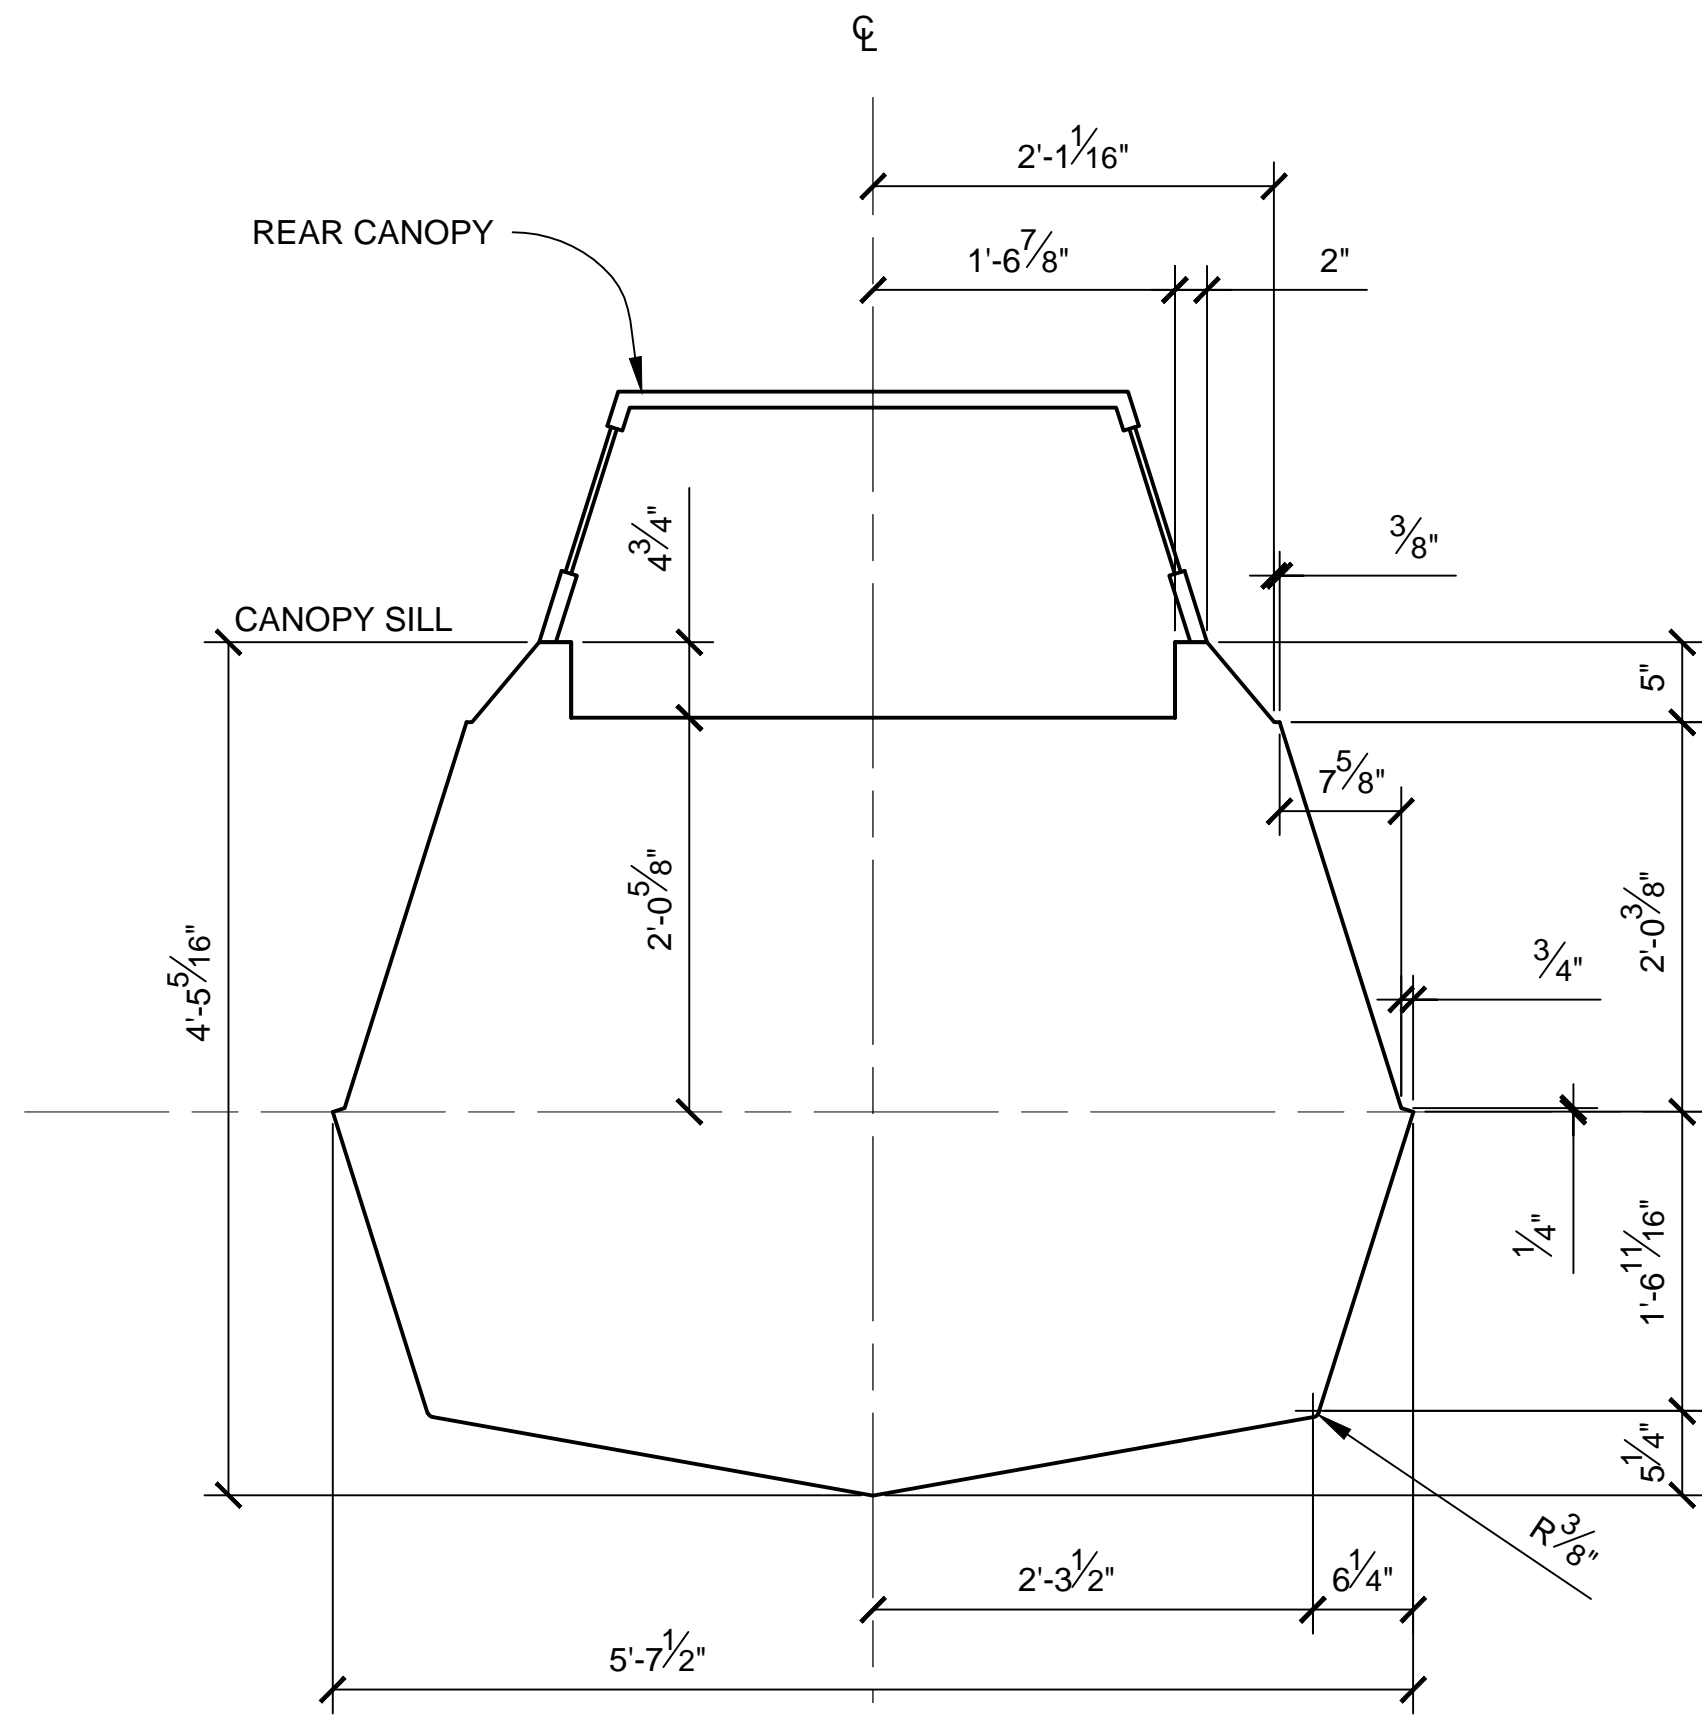


STA 24
SCALE 1:12

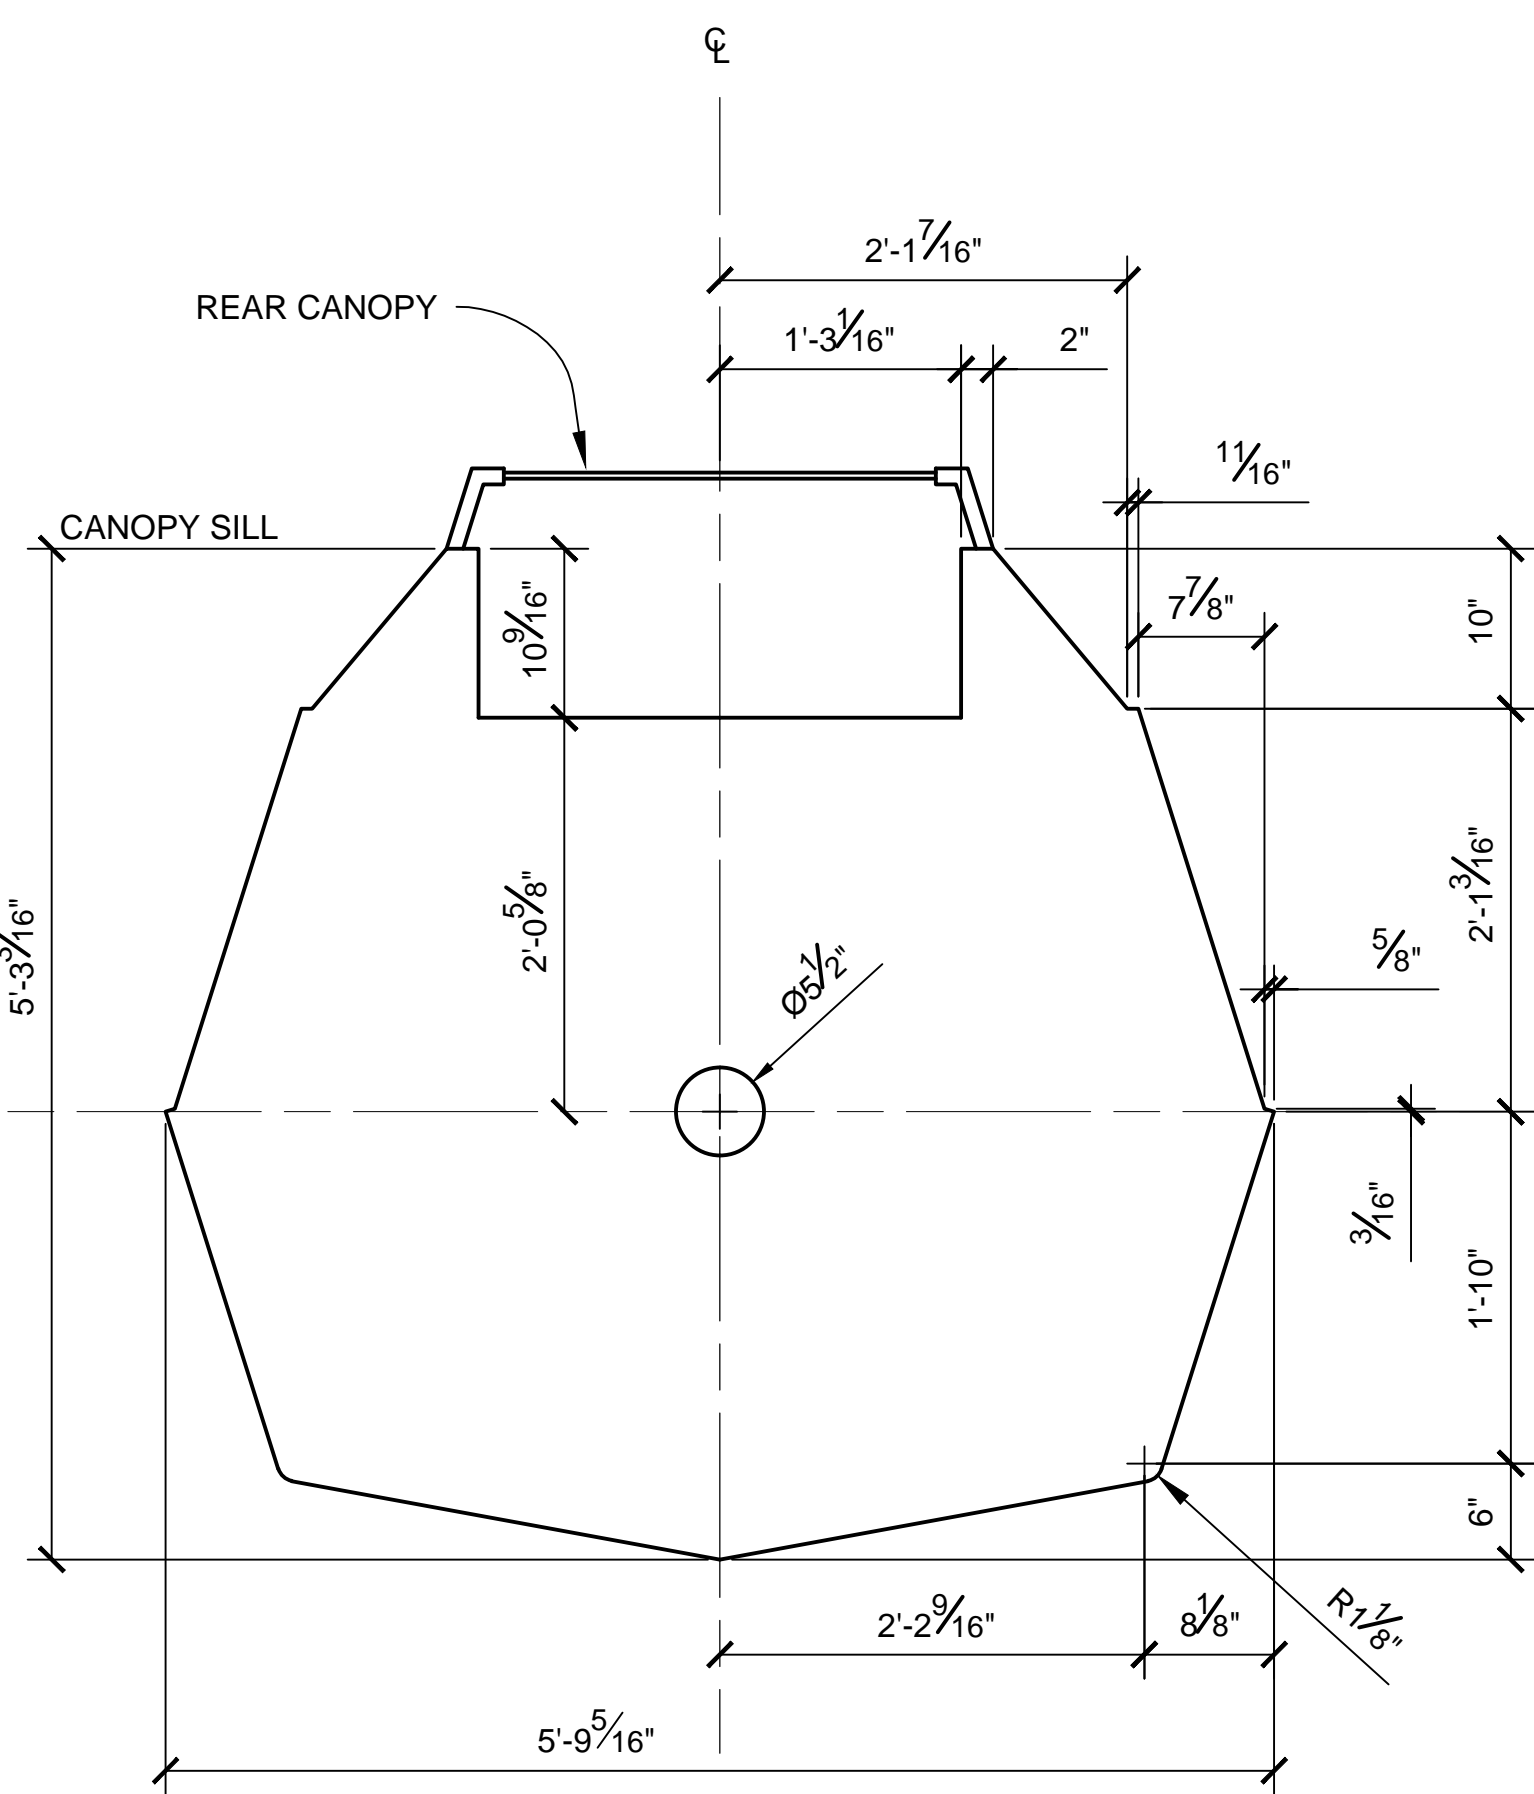


STA 25
SCALE 1:12

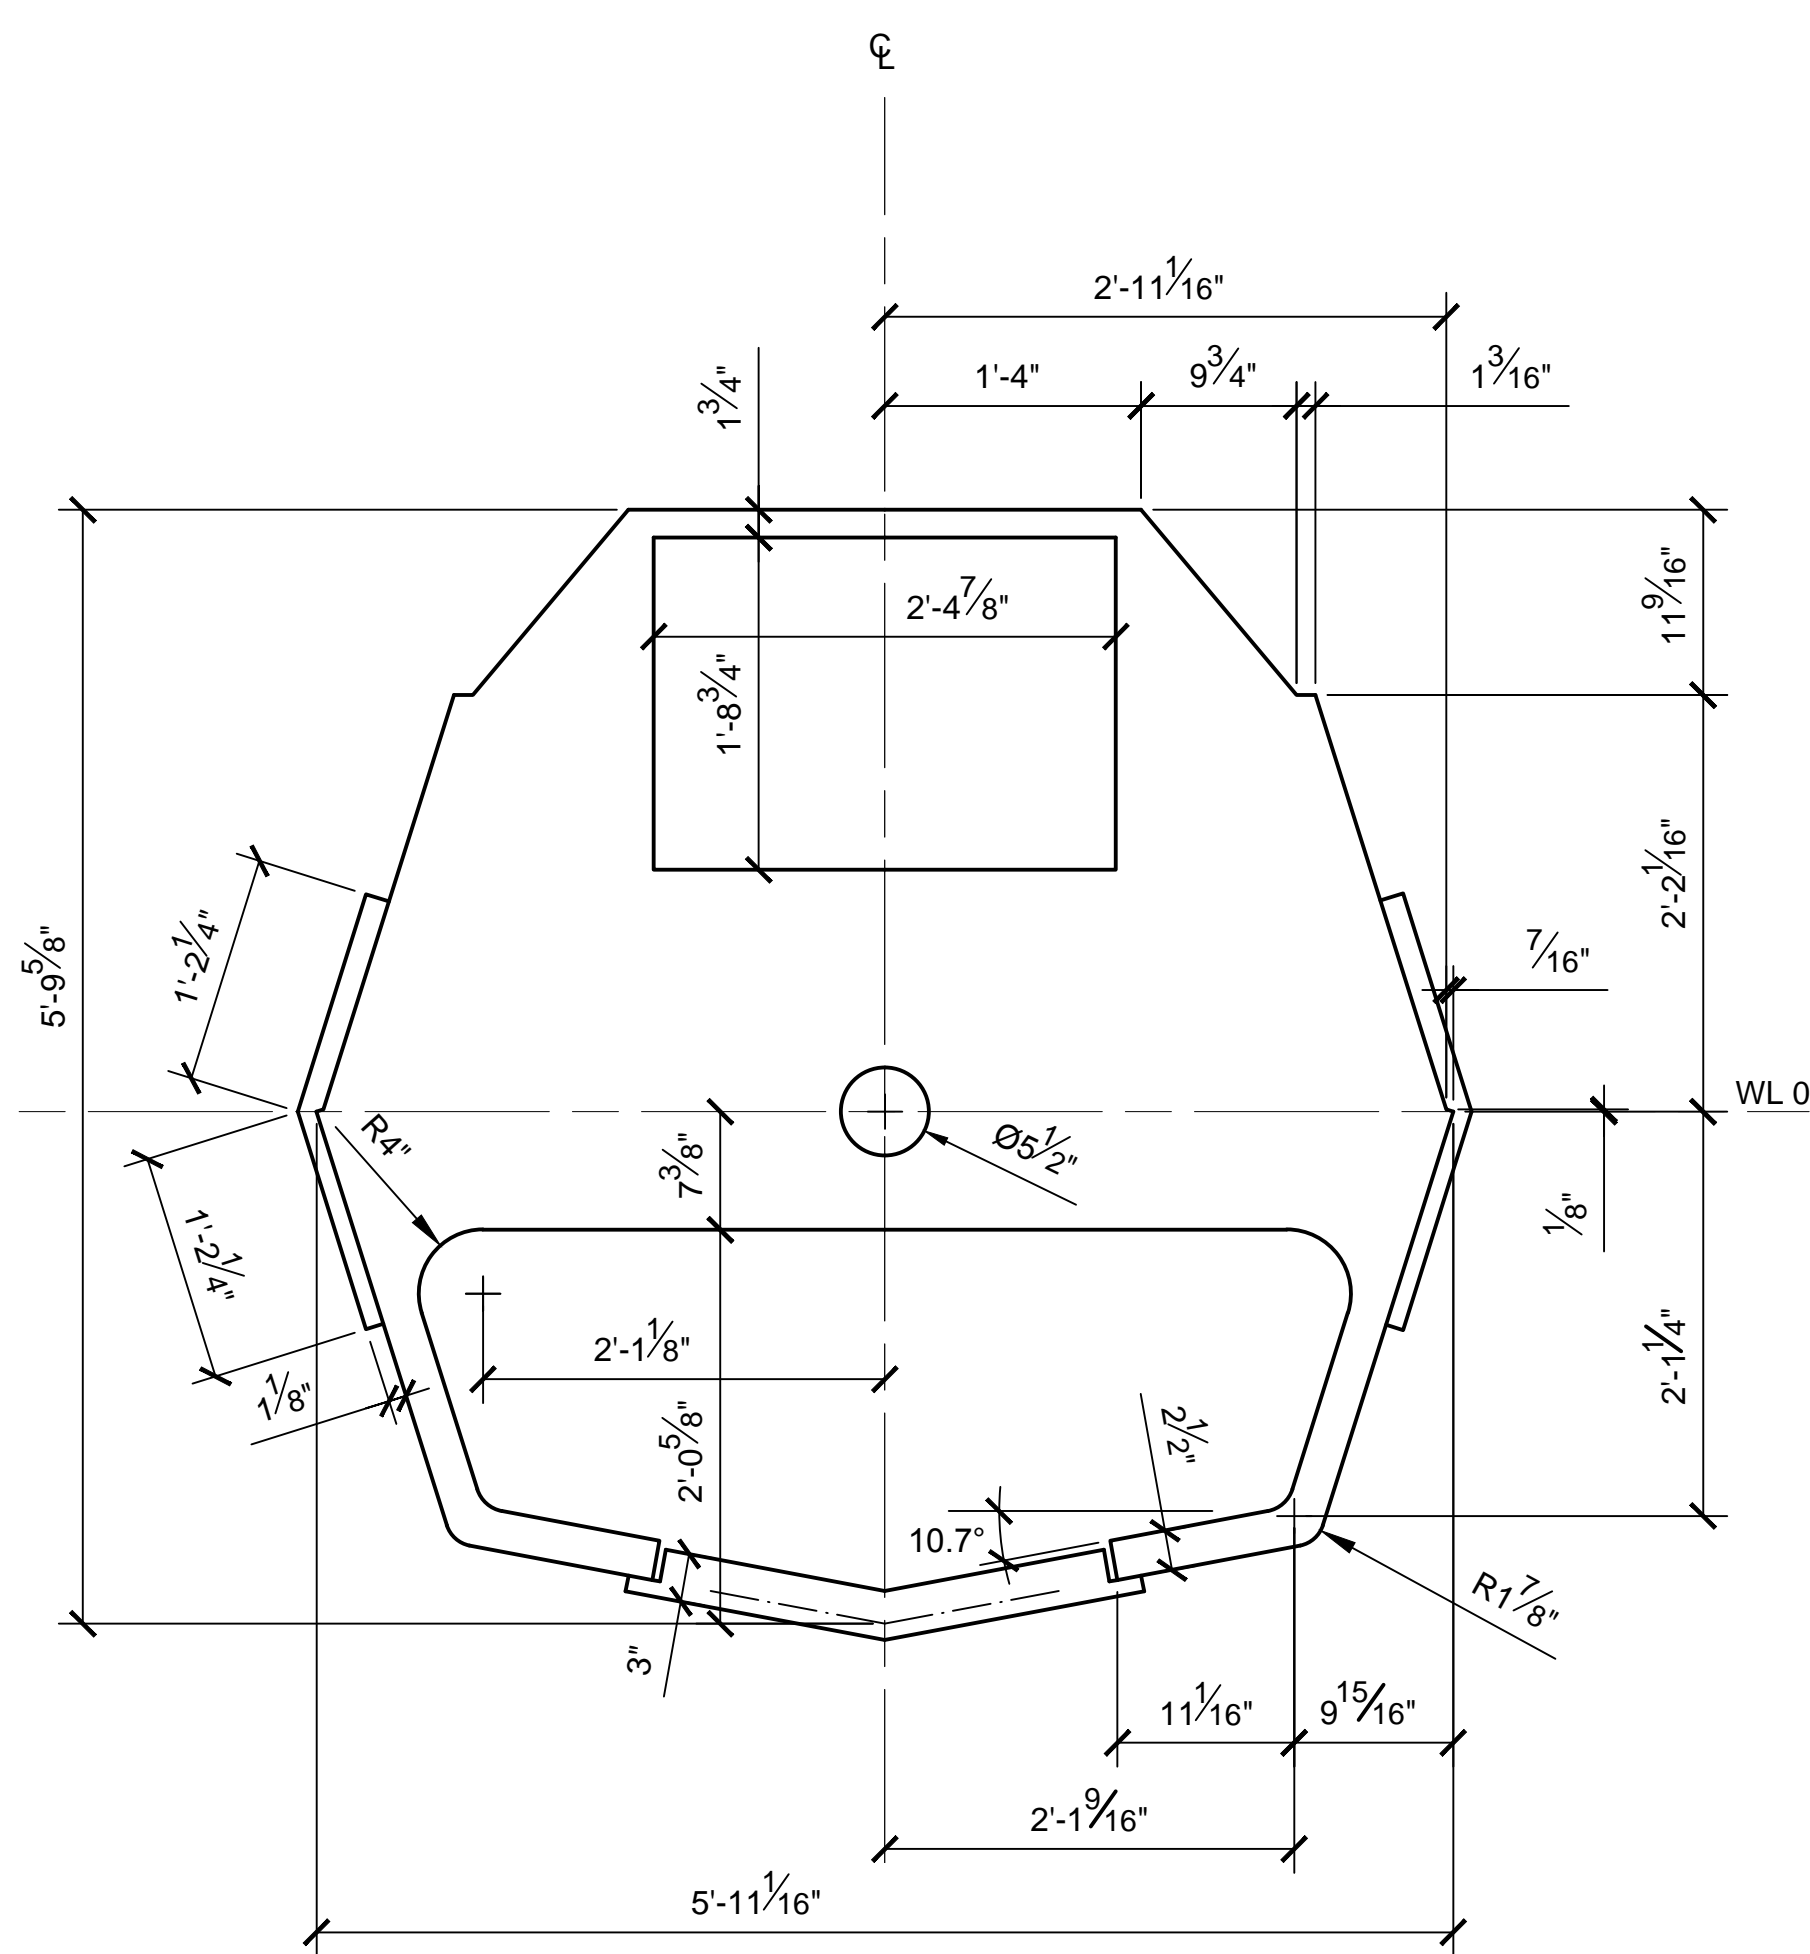


STA 26
SCALE 1:12

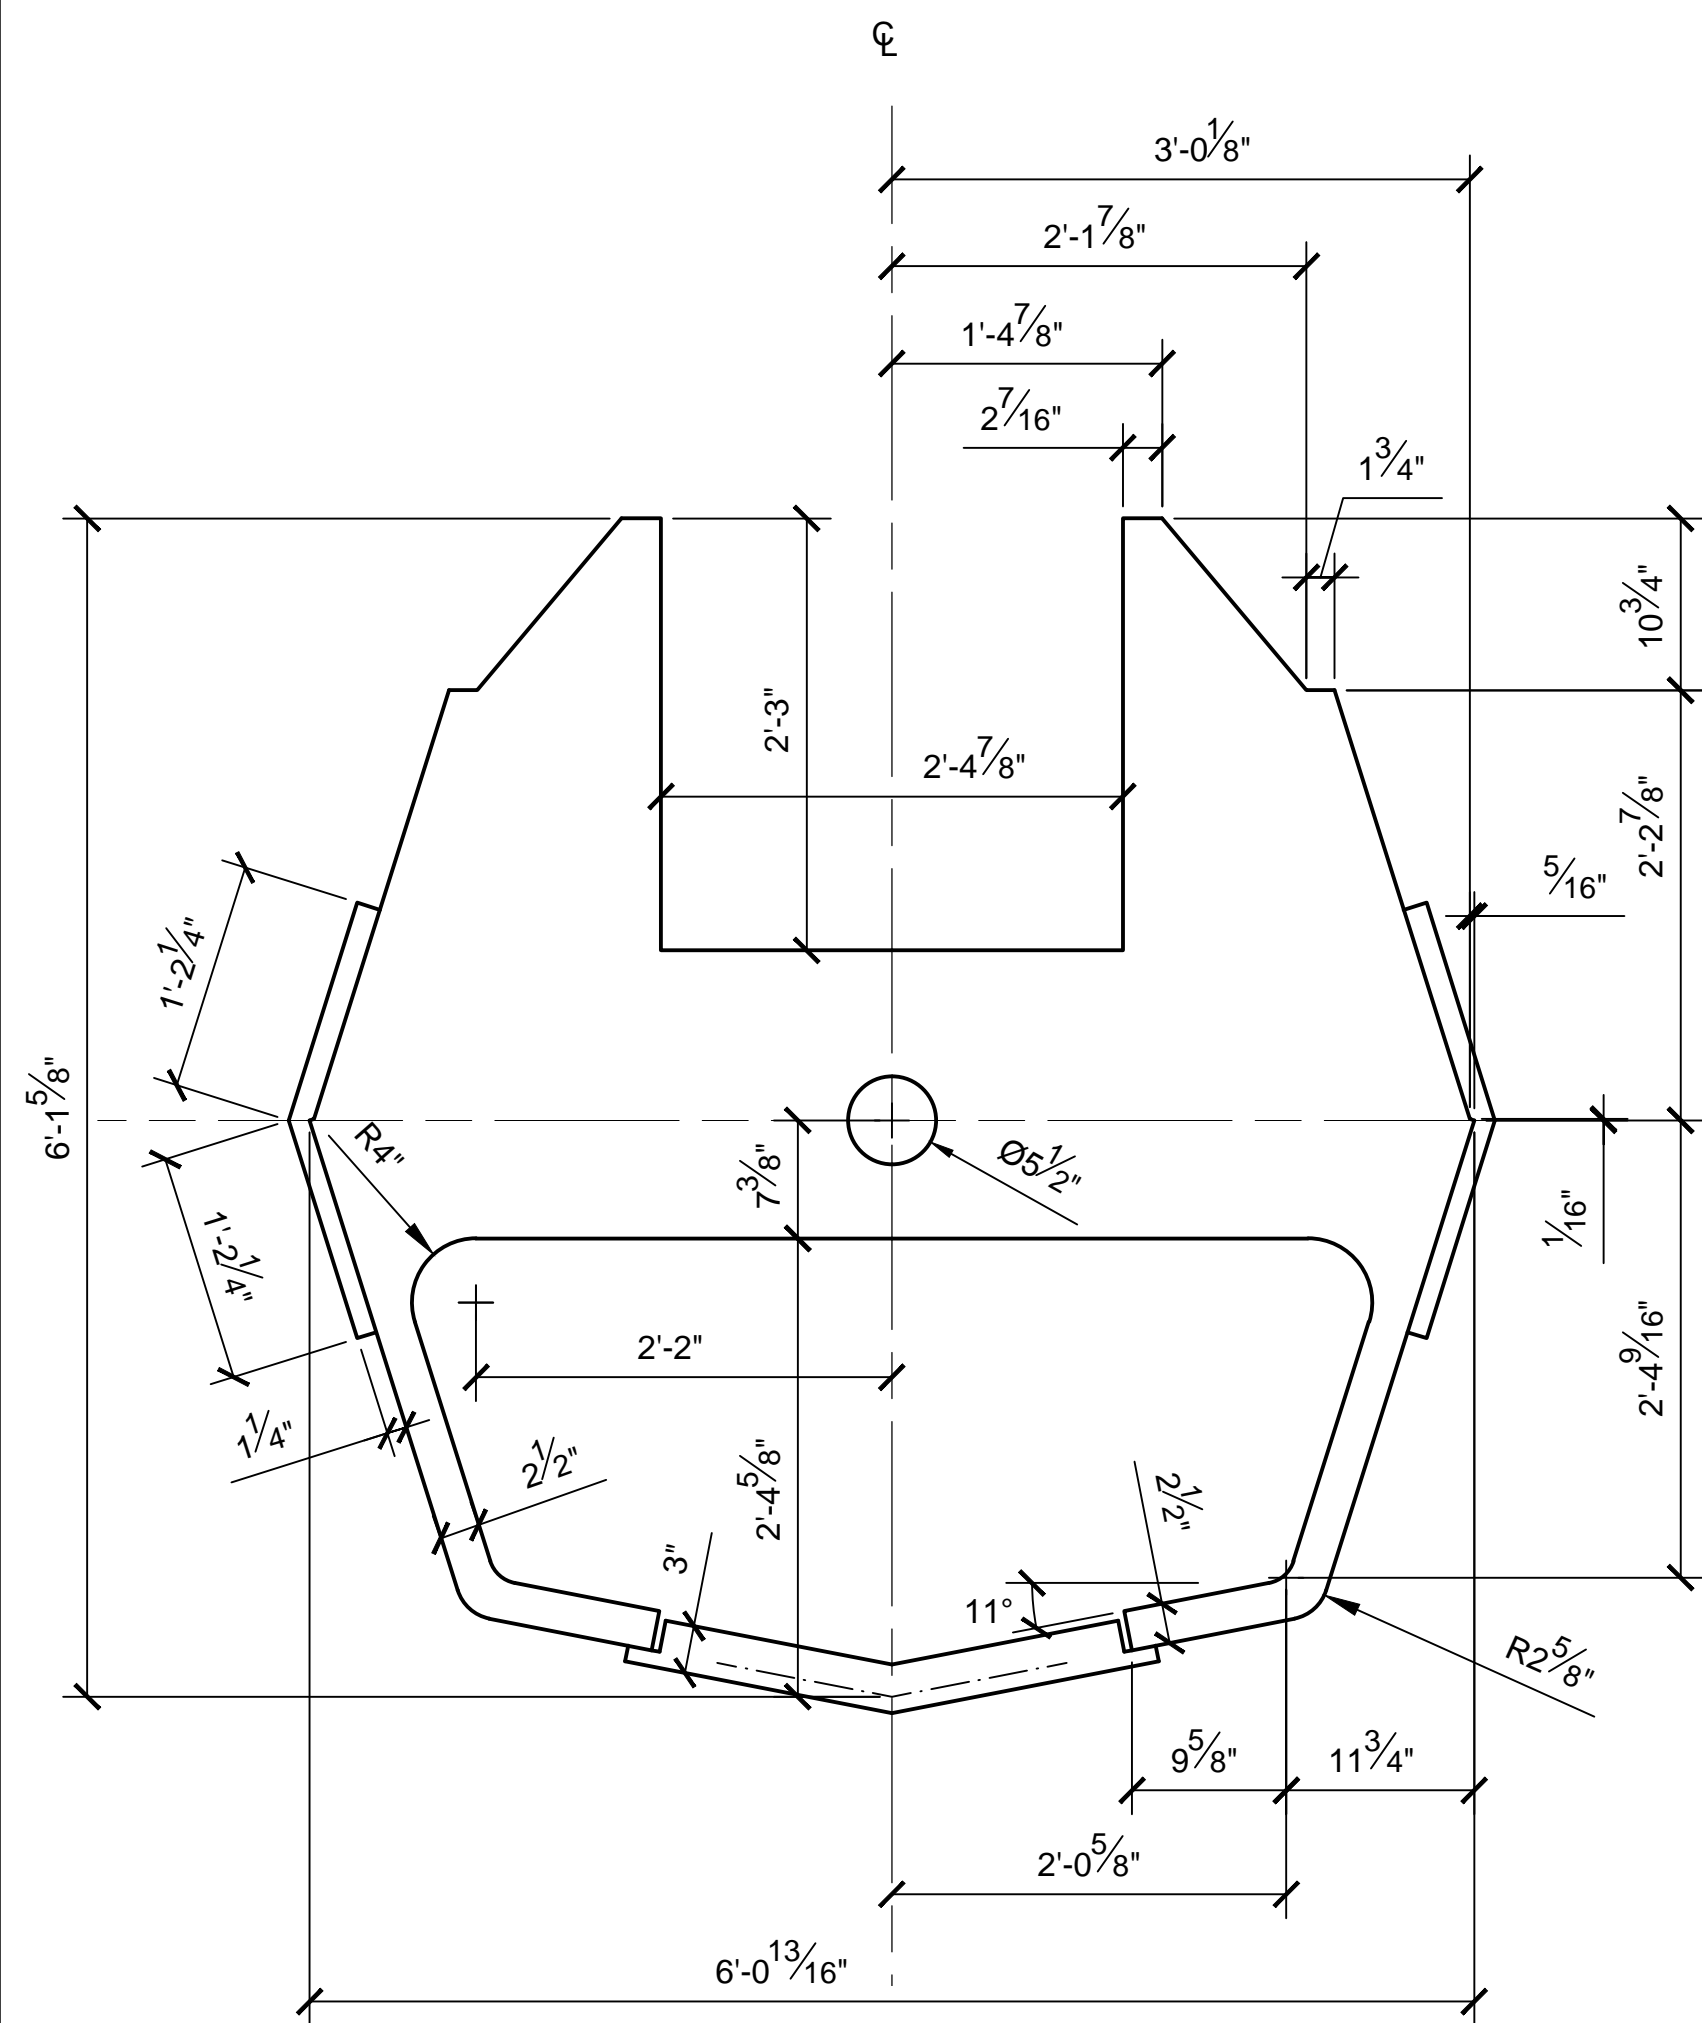

STA 27
SCALE 1:12

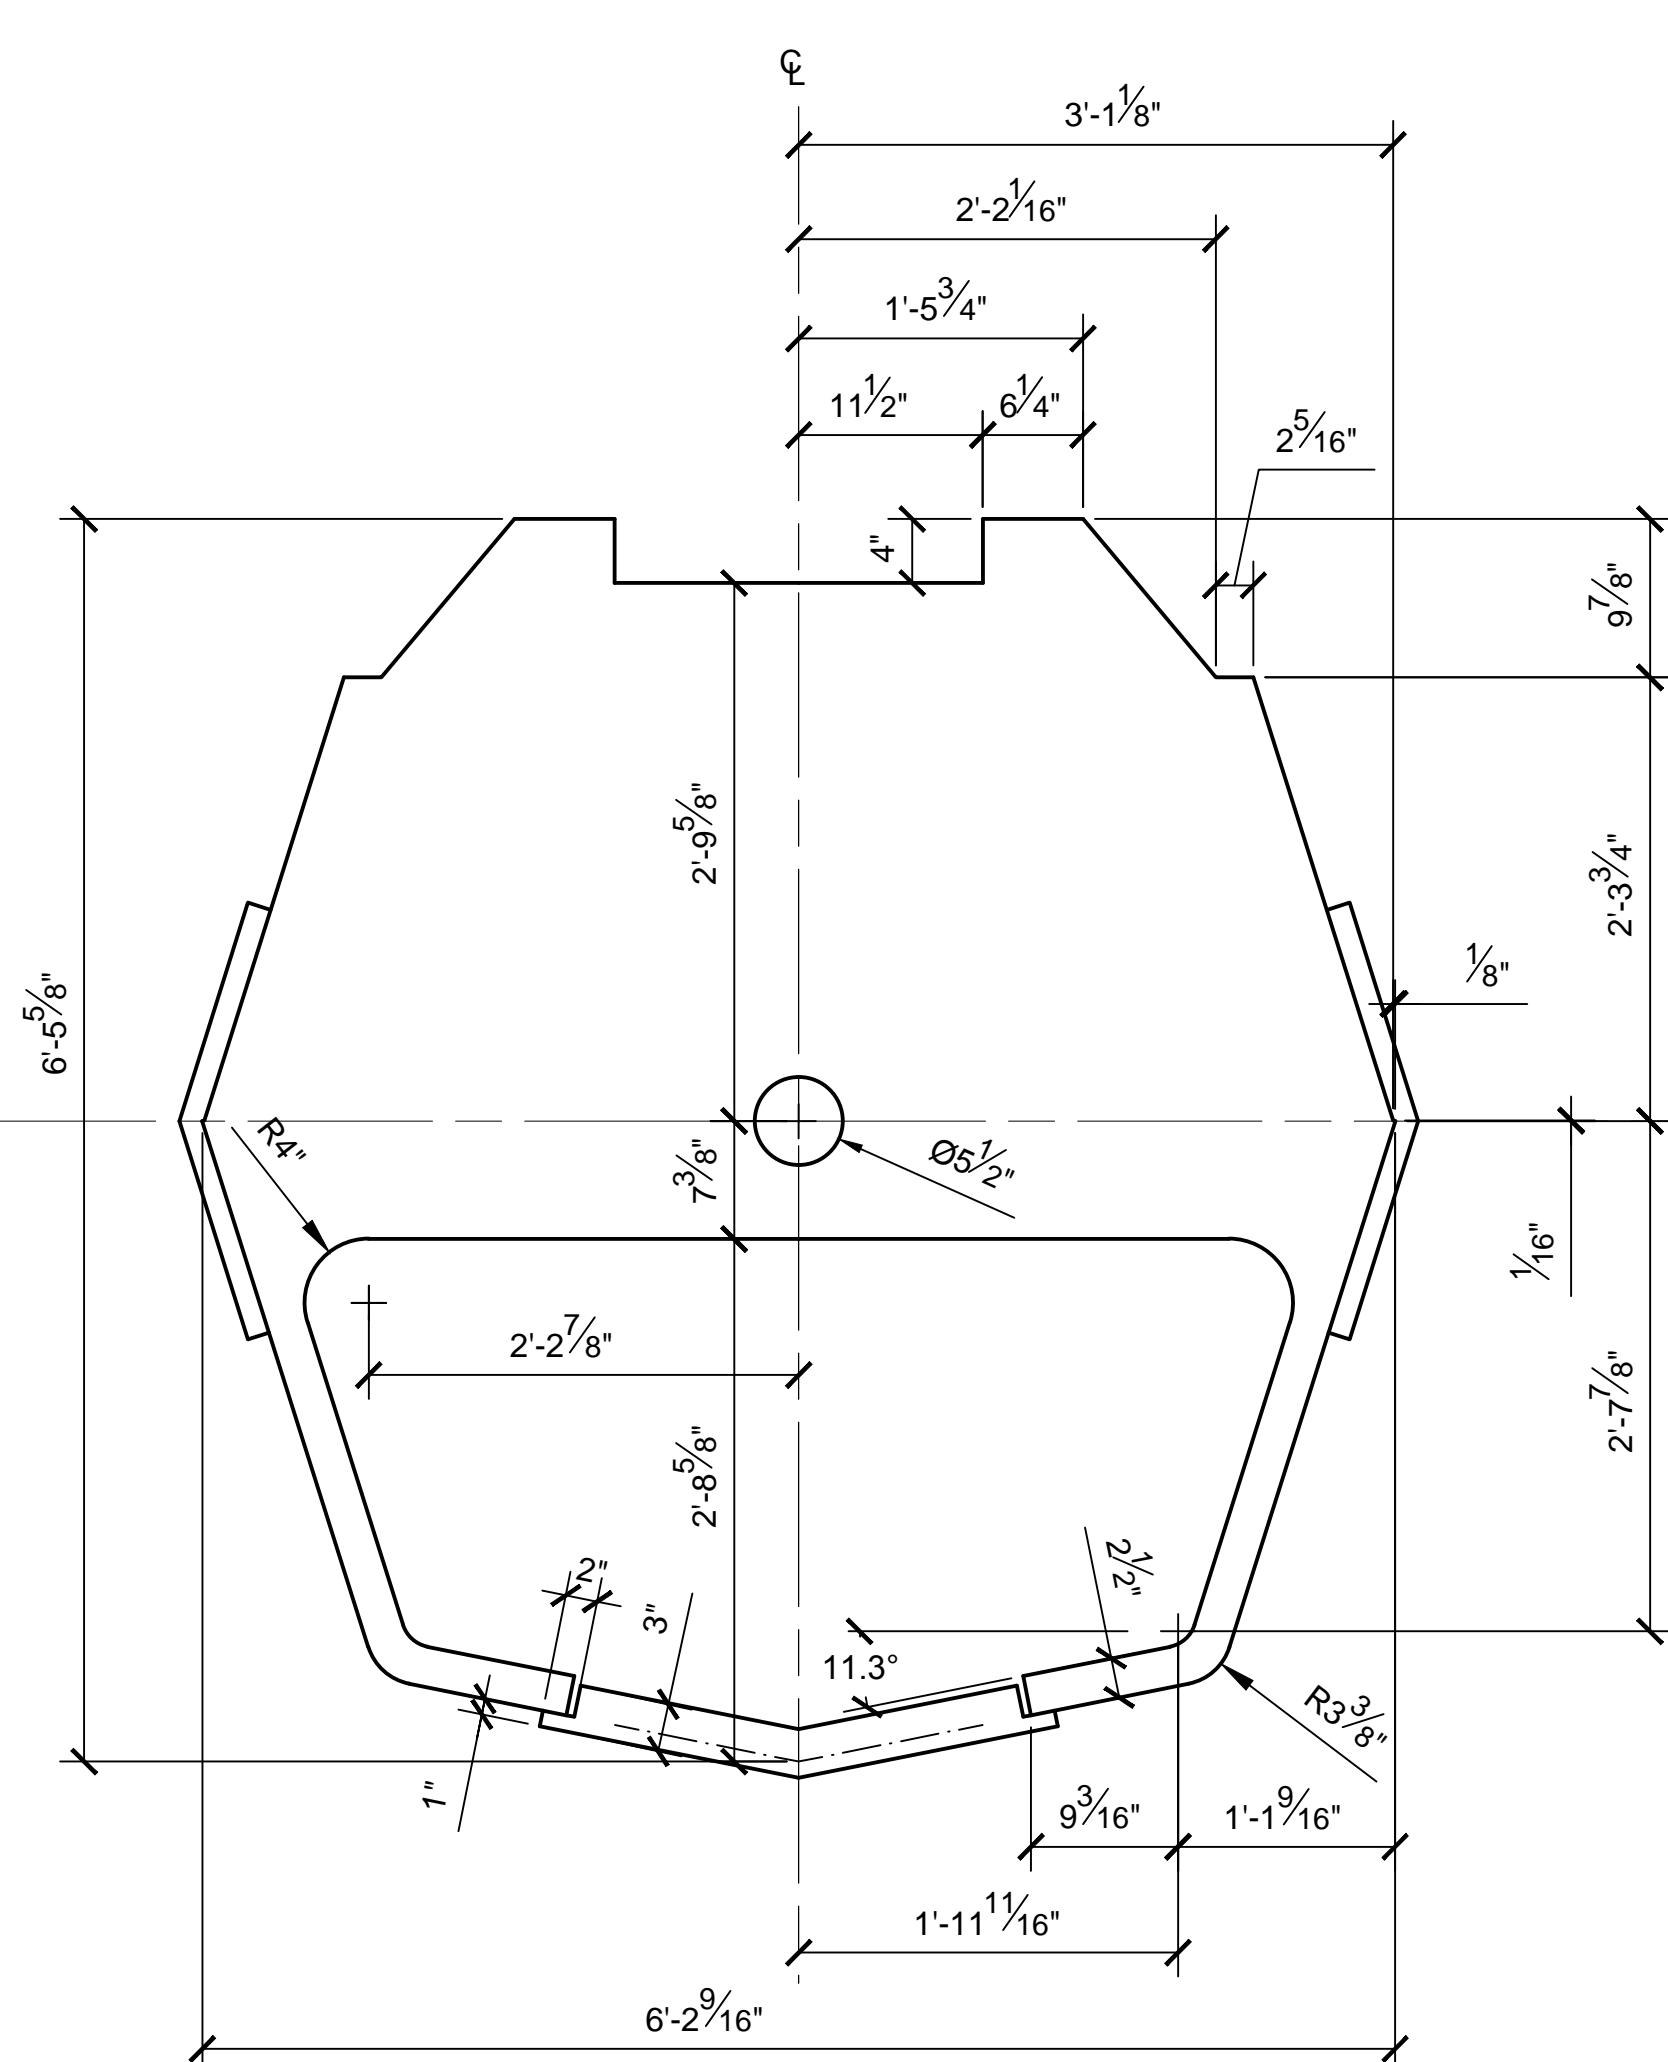

STA 28
SCALE 1:12

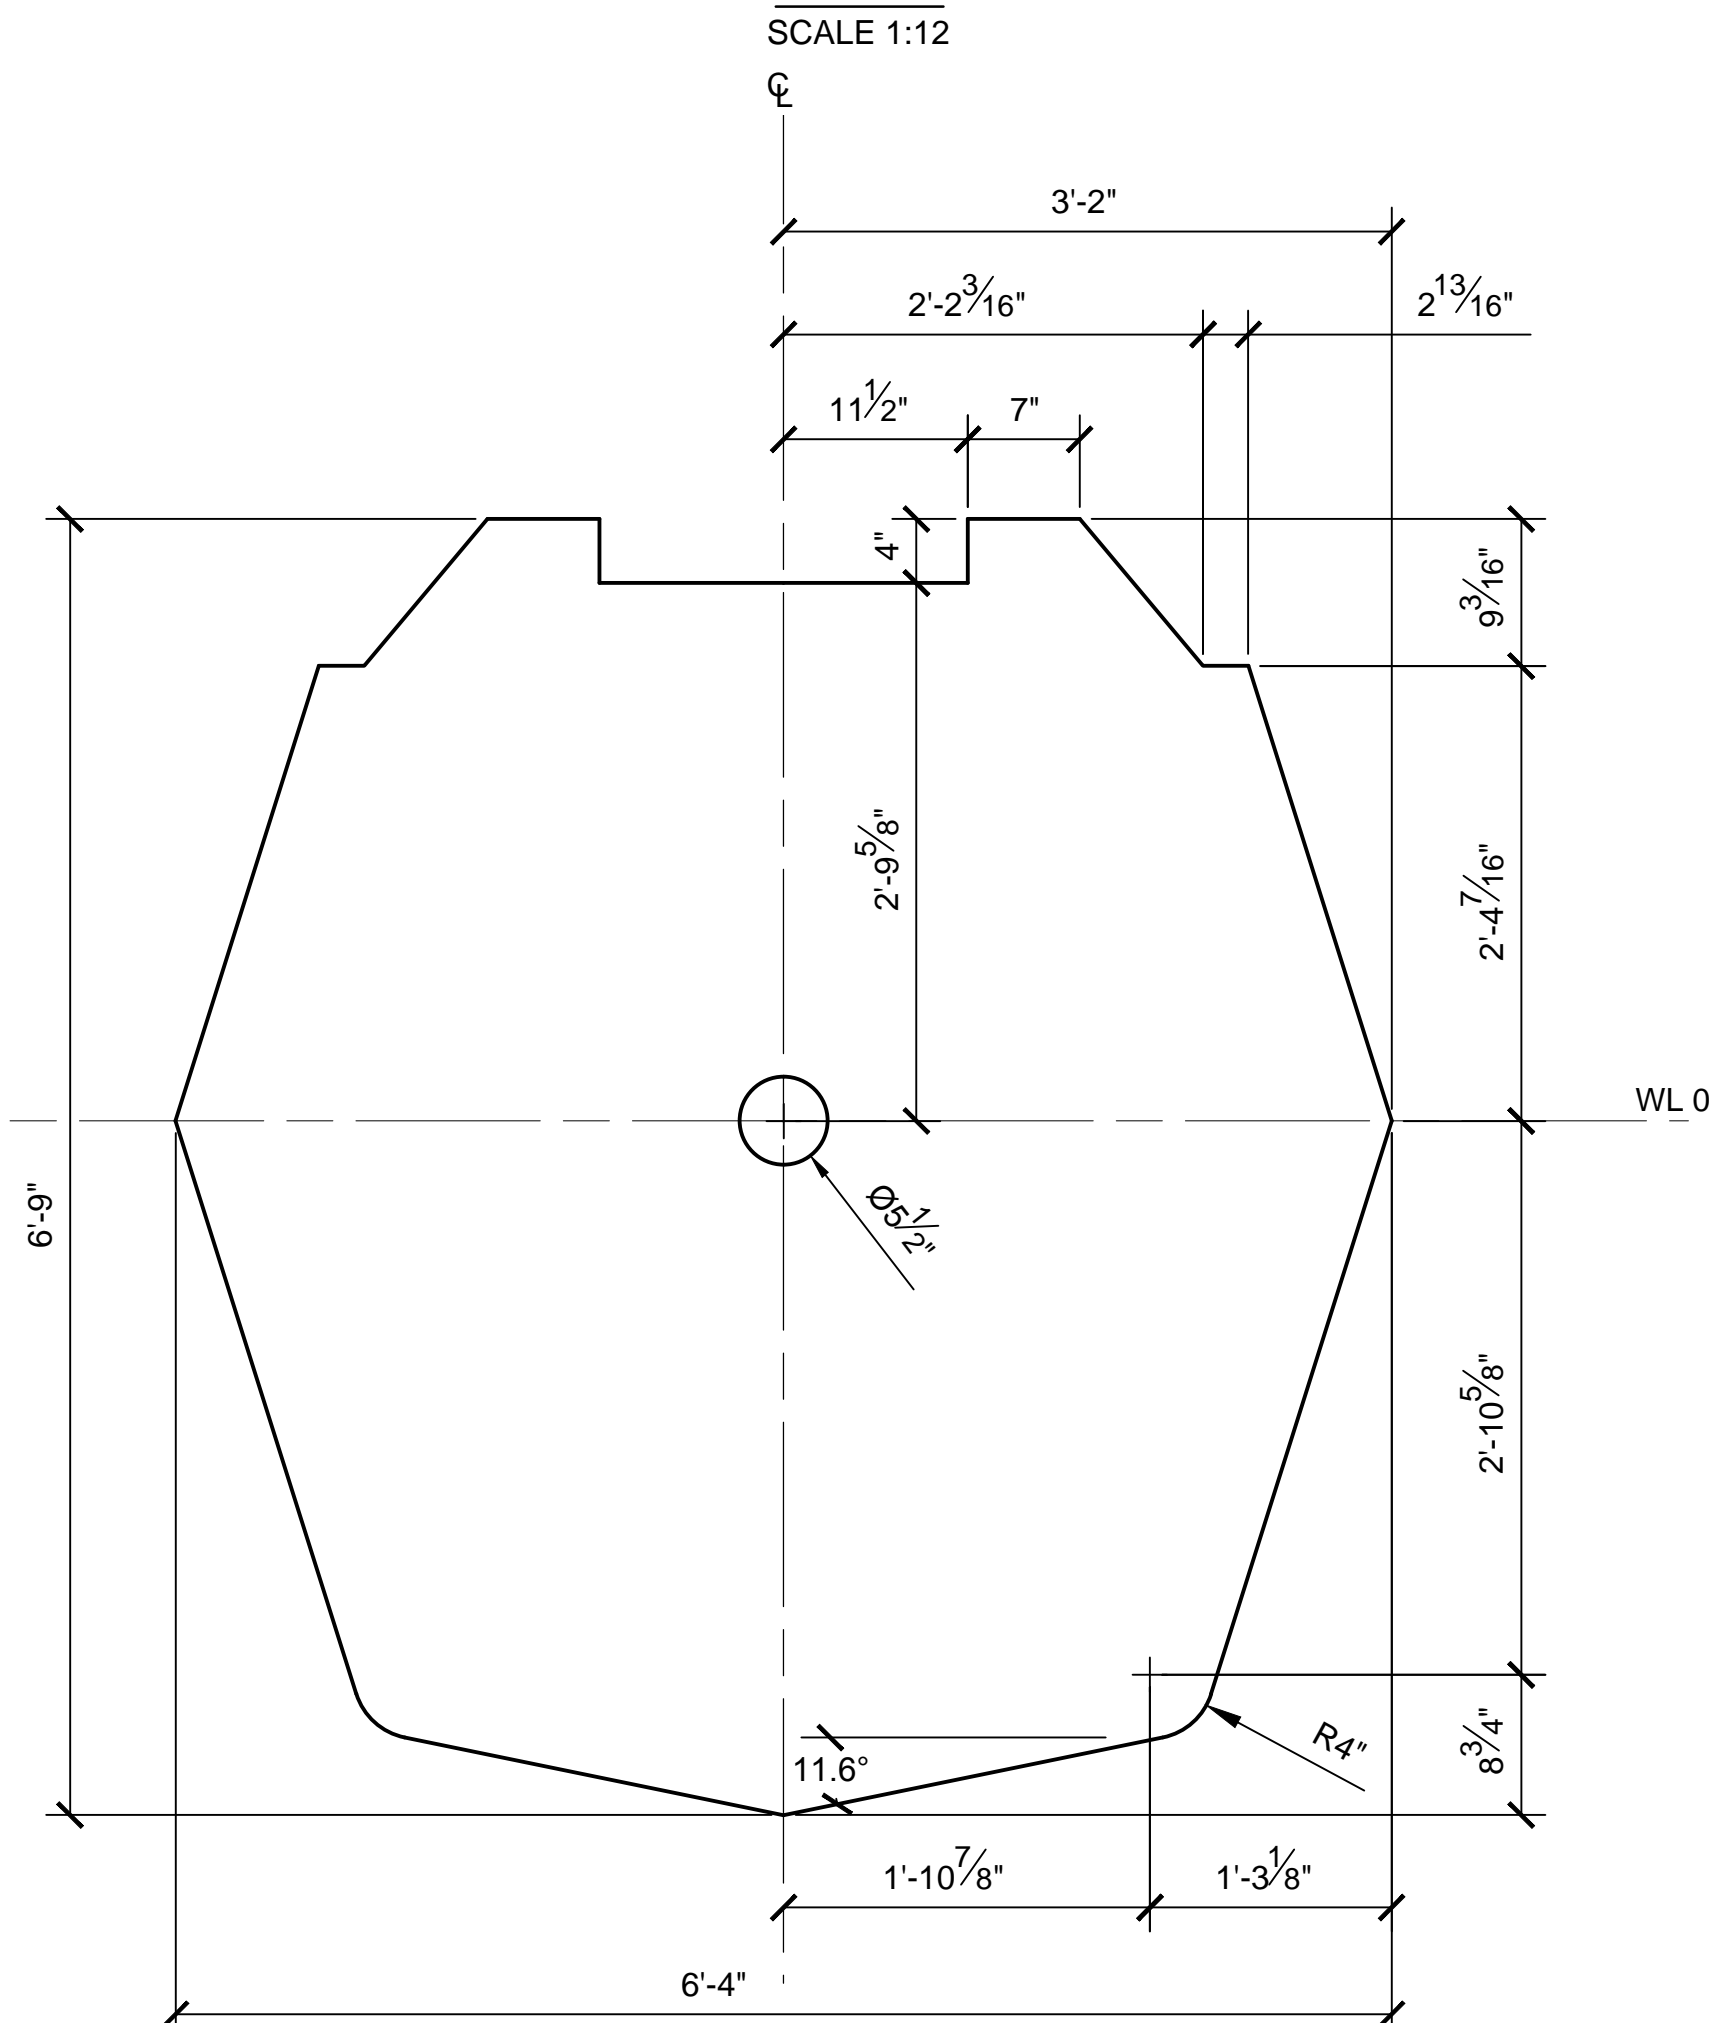


STA 28.83
SCALE 1:12

NOTES:


1. PRE-EXISTING MATERIAL COPYRIGHTED BY THE STAR WARS CORPORATION AND LUCASFILM LTD.
2. CROSS SECTIONS SHOW OUTSIDE MOLDED SURFACE.
3. CROSS SECTIONS ARE SYMMETRICAL UNLESS OTHERWISE SPECIFIED.

PRODUCTION	D.O.P.	ART DIRECTOR	CAMERA
ART DEPT.	SET DESIGNER	SCULPTOR	GRAPHICS
SET DEC.	DRAPES	PROPS	MODEL SHOP
CONST. COORD.	CARPENTER	PLASTER	PAINT
GREENS	SCENIC	METALS	SFX
GRIP	ELECTRICAL	VFX	CGI


PROJECT			
THE X-WING BUILD			
1:1 SCALE STAGE PROP			
SET	TITLE		SET NO.
	FUSELAGE SECTIONS		--
PROD DESIGNER	DATE DRAWN		
	3/SEP/2012		
DRAWN BY	APPROVED BY		DATE ISSUED
B.J.S.			DD/MMM/YYYY
STAGE	LOCATION		DWG NO.
FILE X-WING LINES_MASTER.DWG	SHEET 7	OF XX	2.05

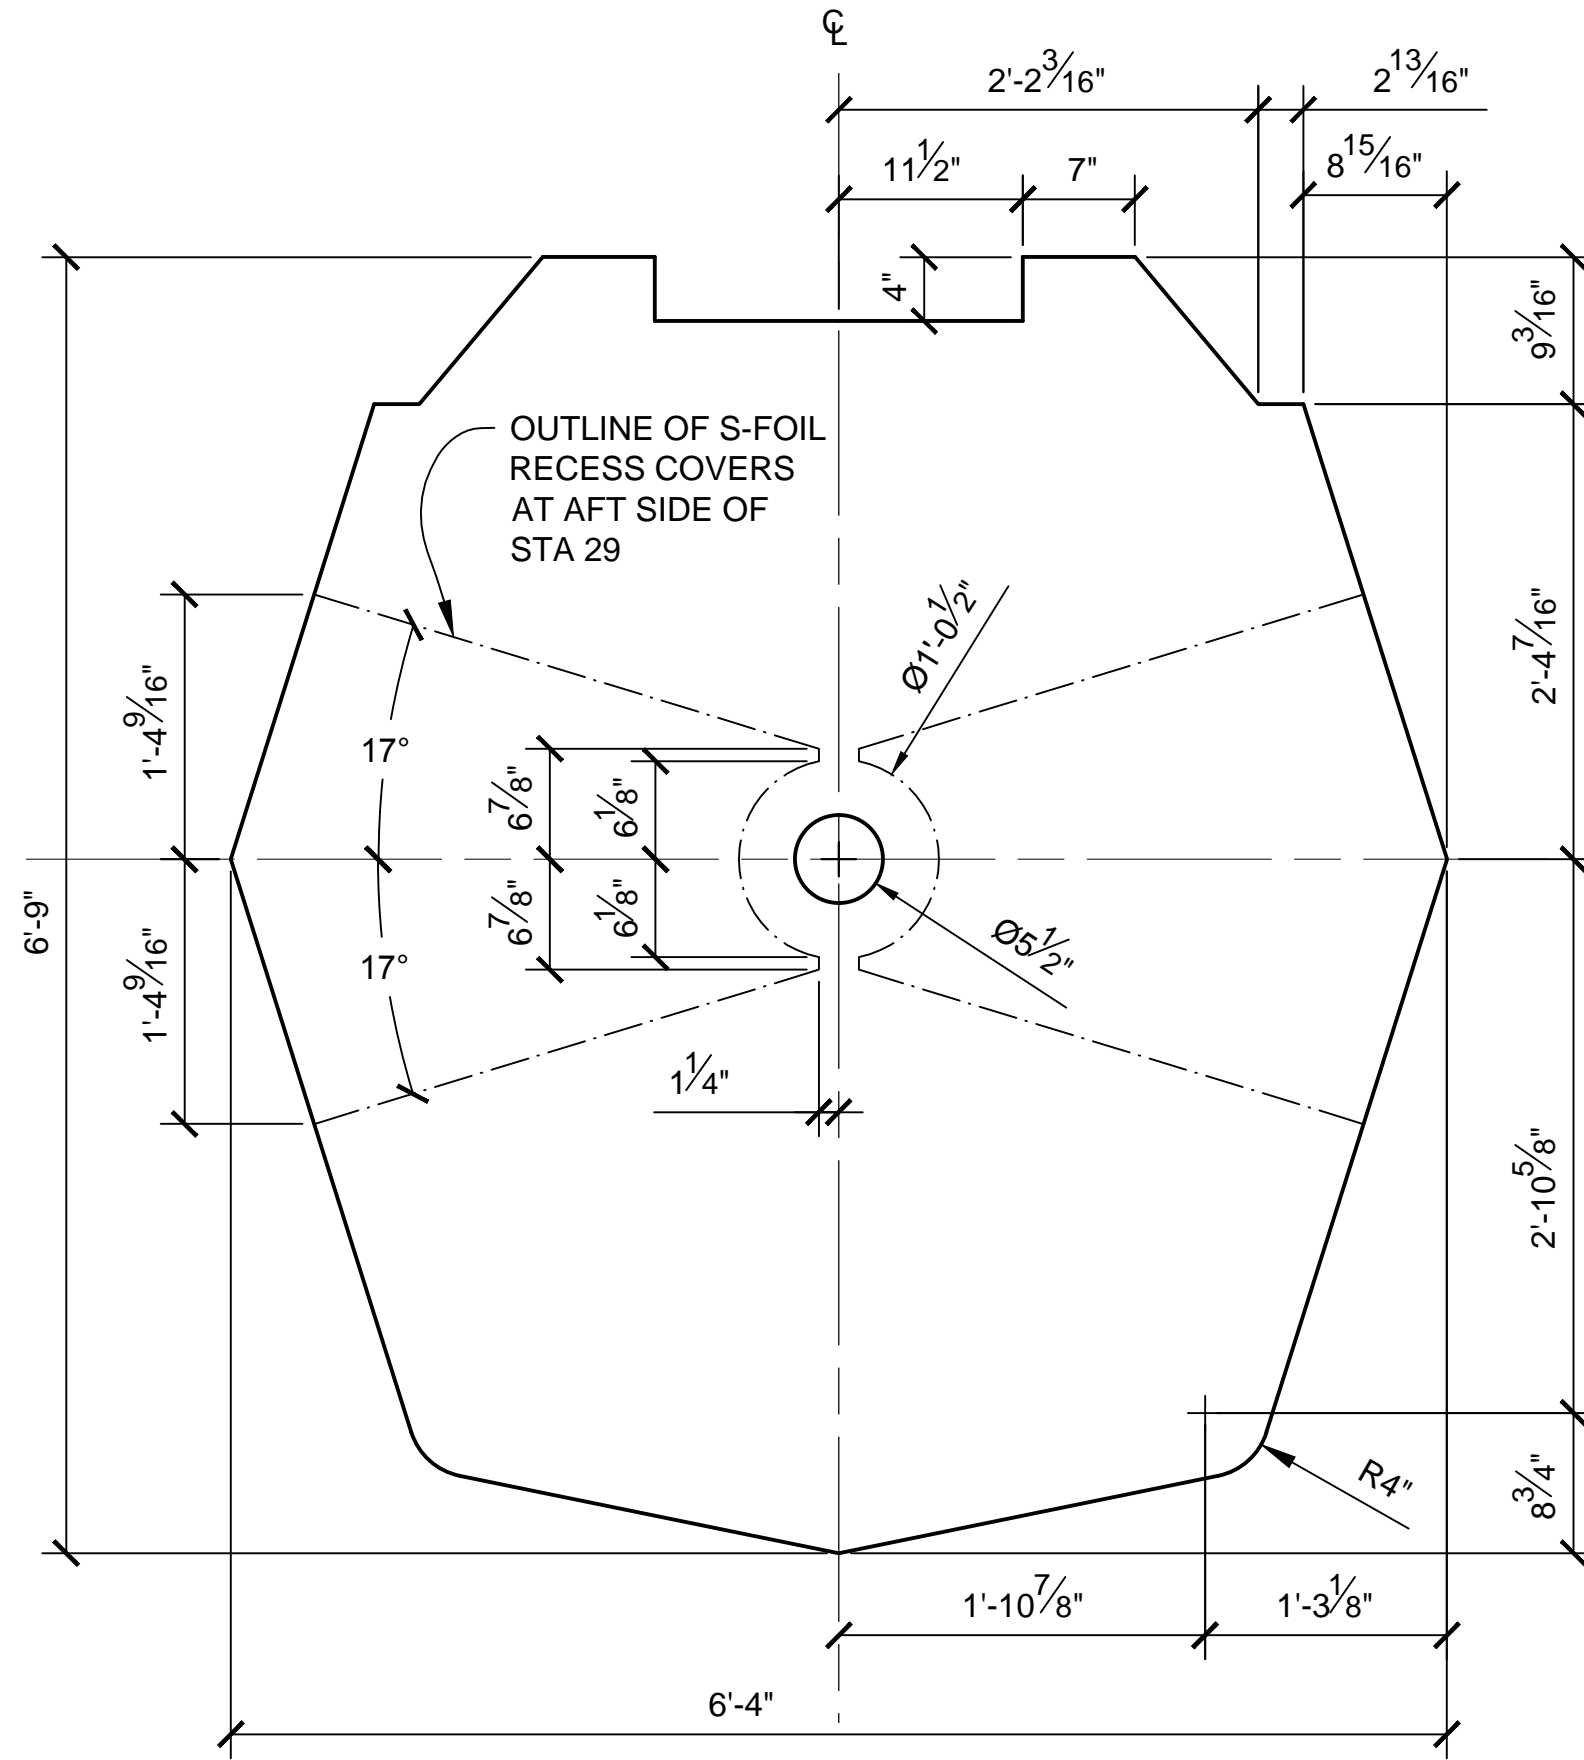


STA 29
SCALE 1:12

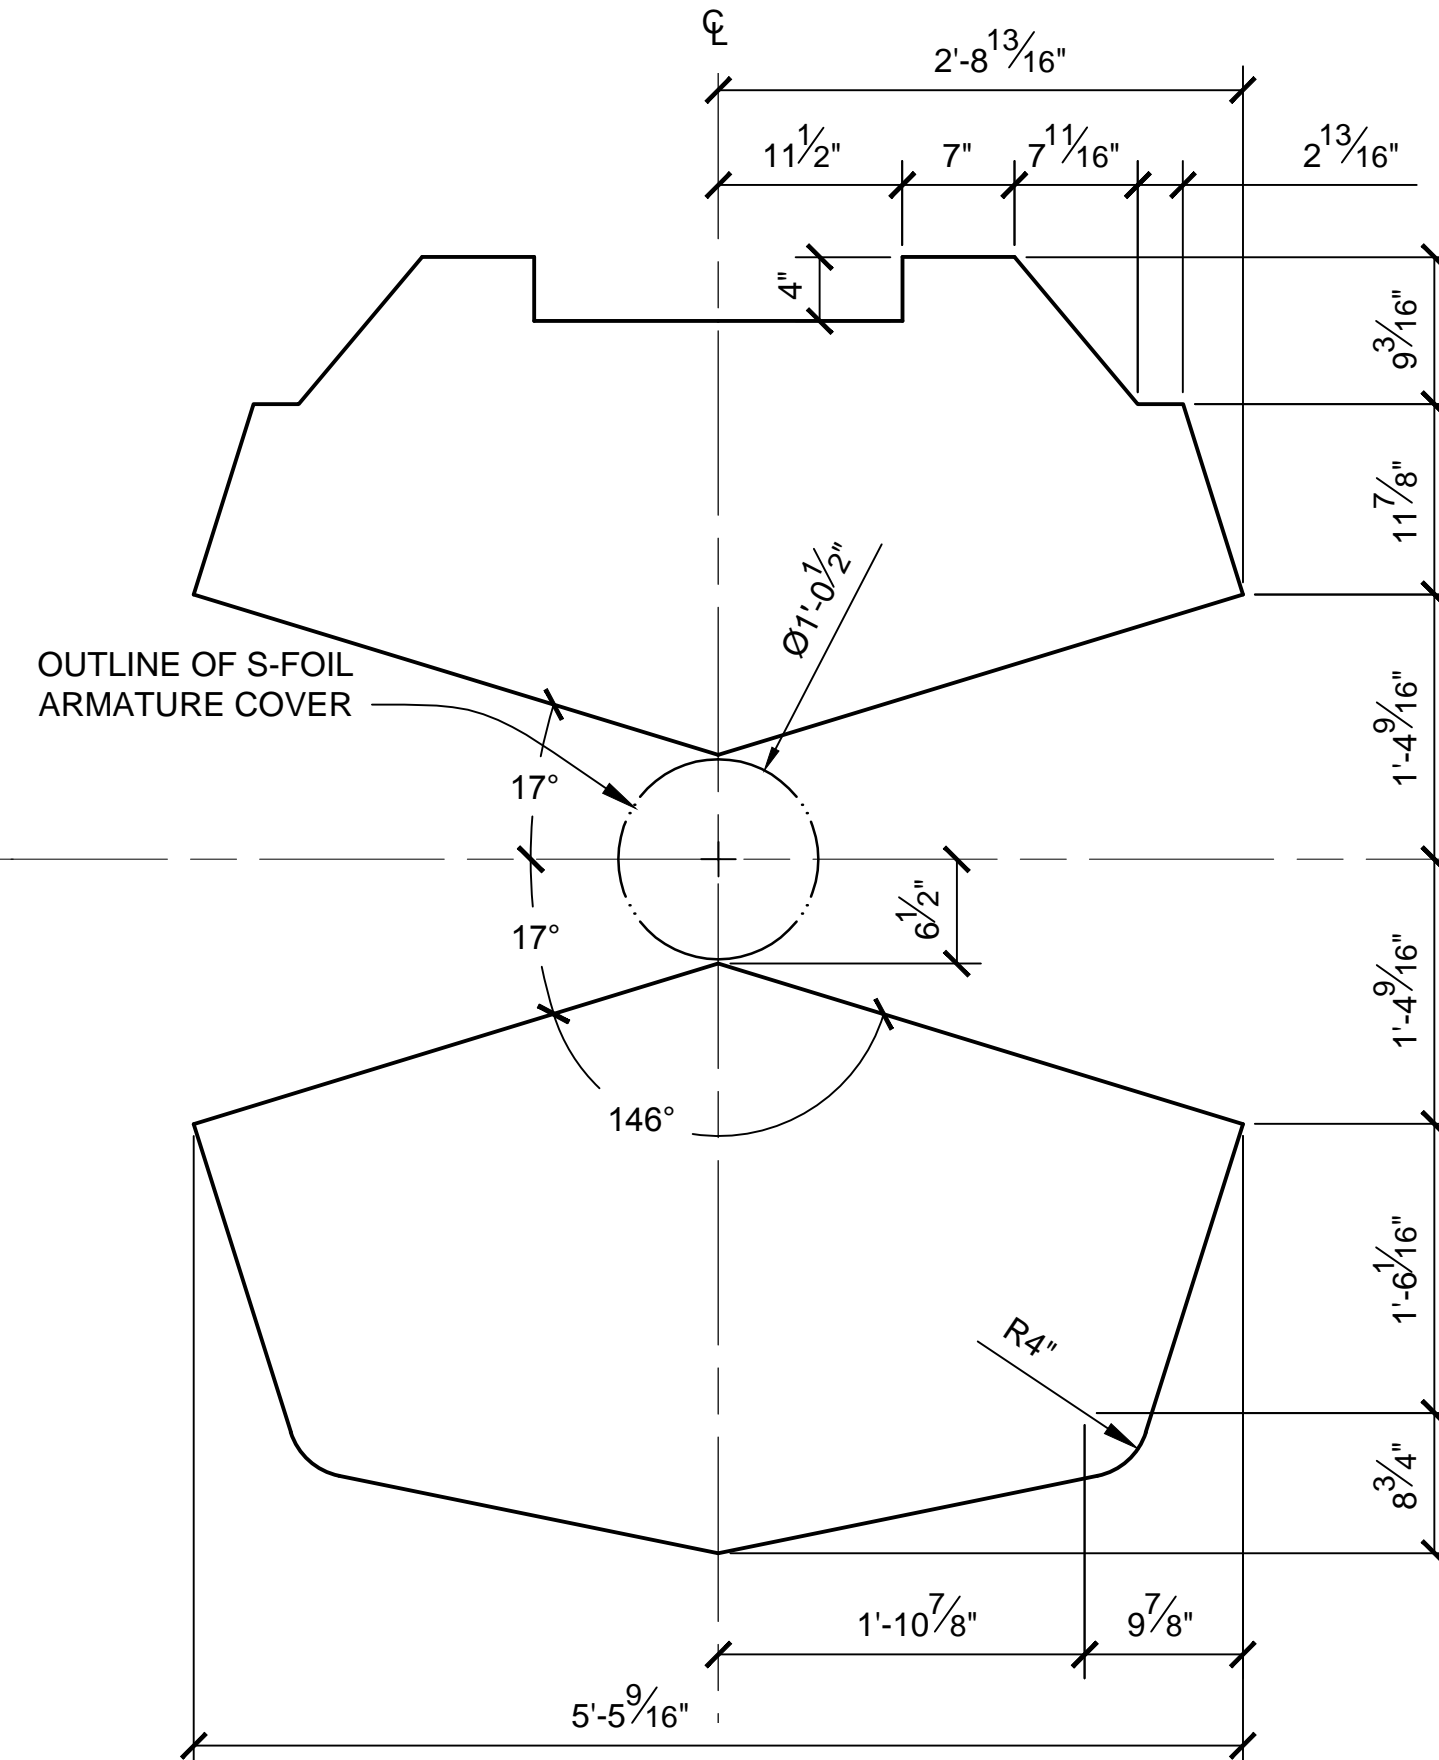


STA 30
SCALE 1:12

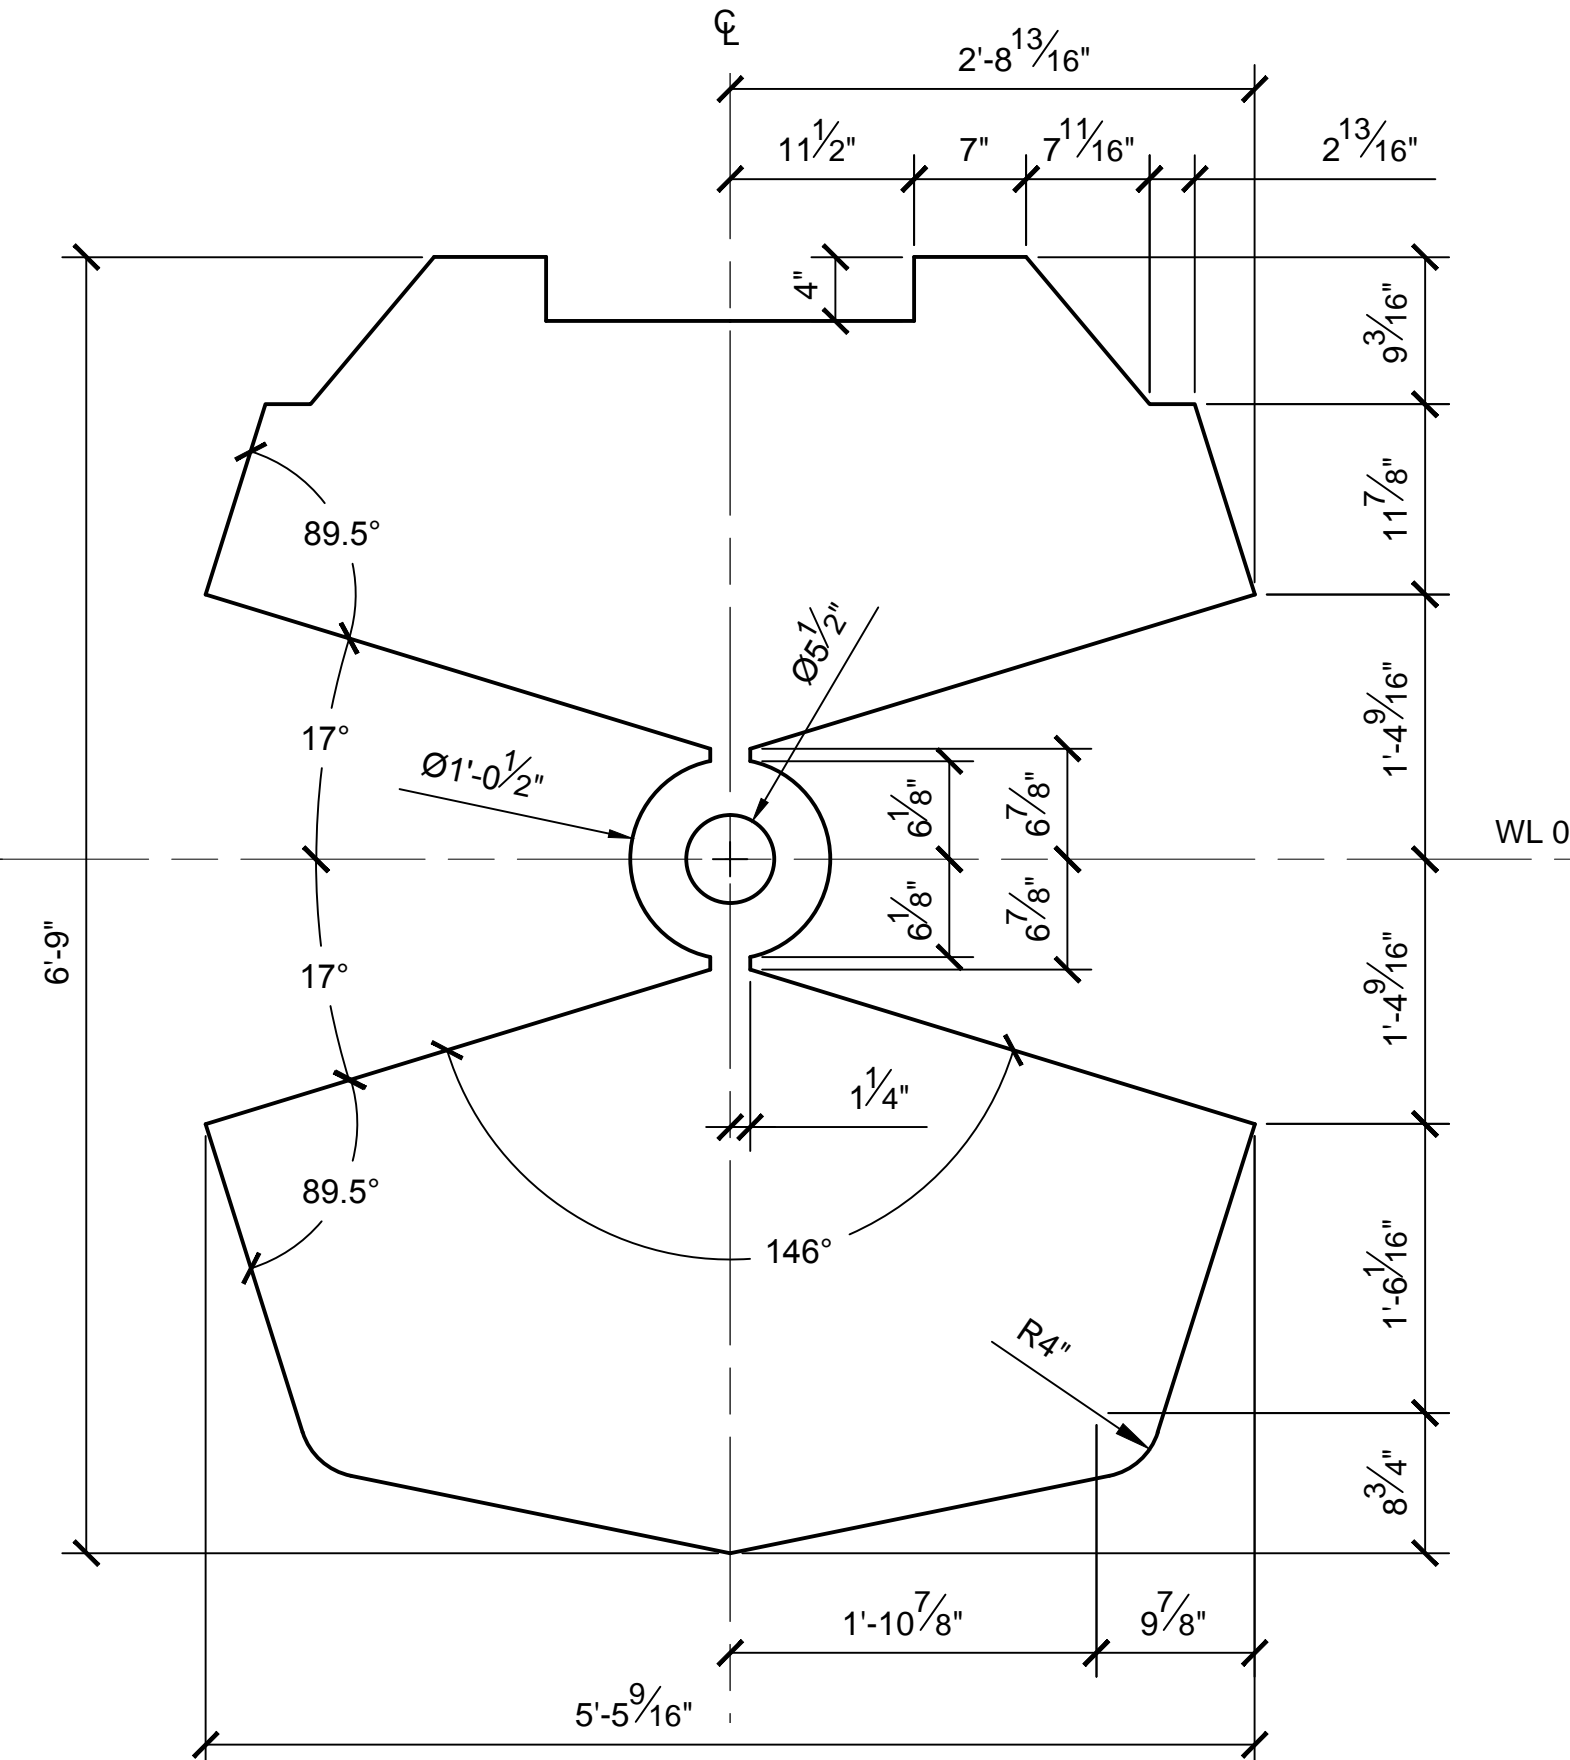


STA 32
SCALE 1:12

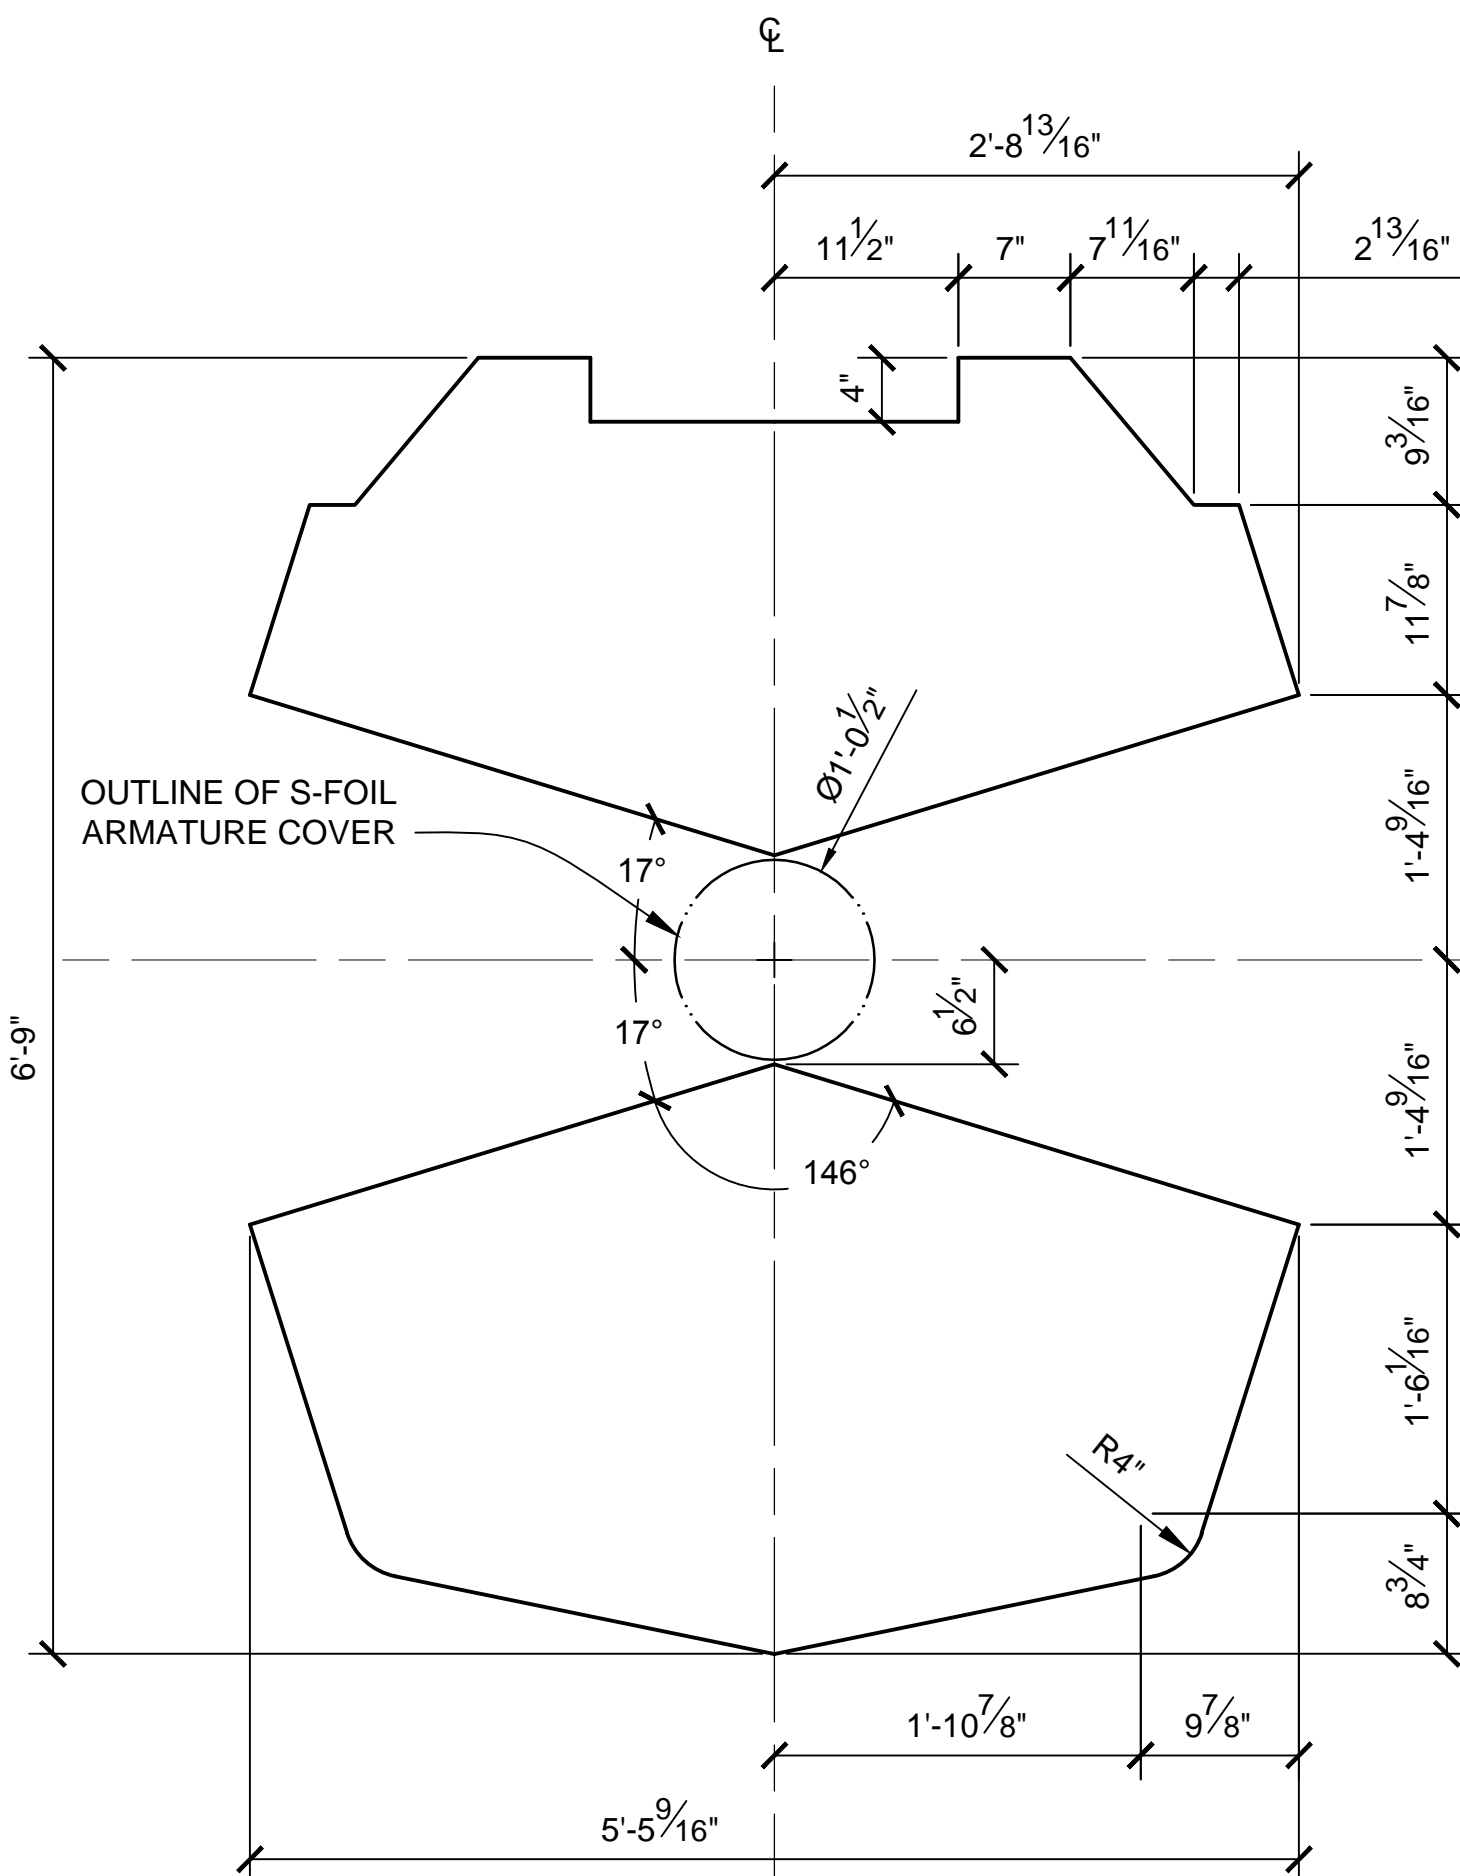

STA 33
SCALE 1:12

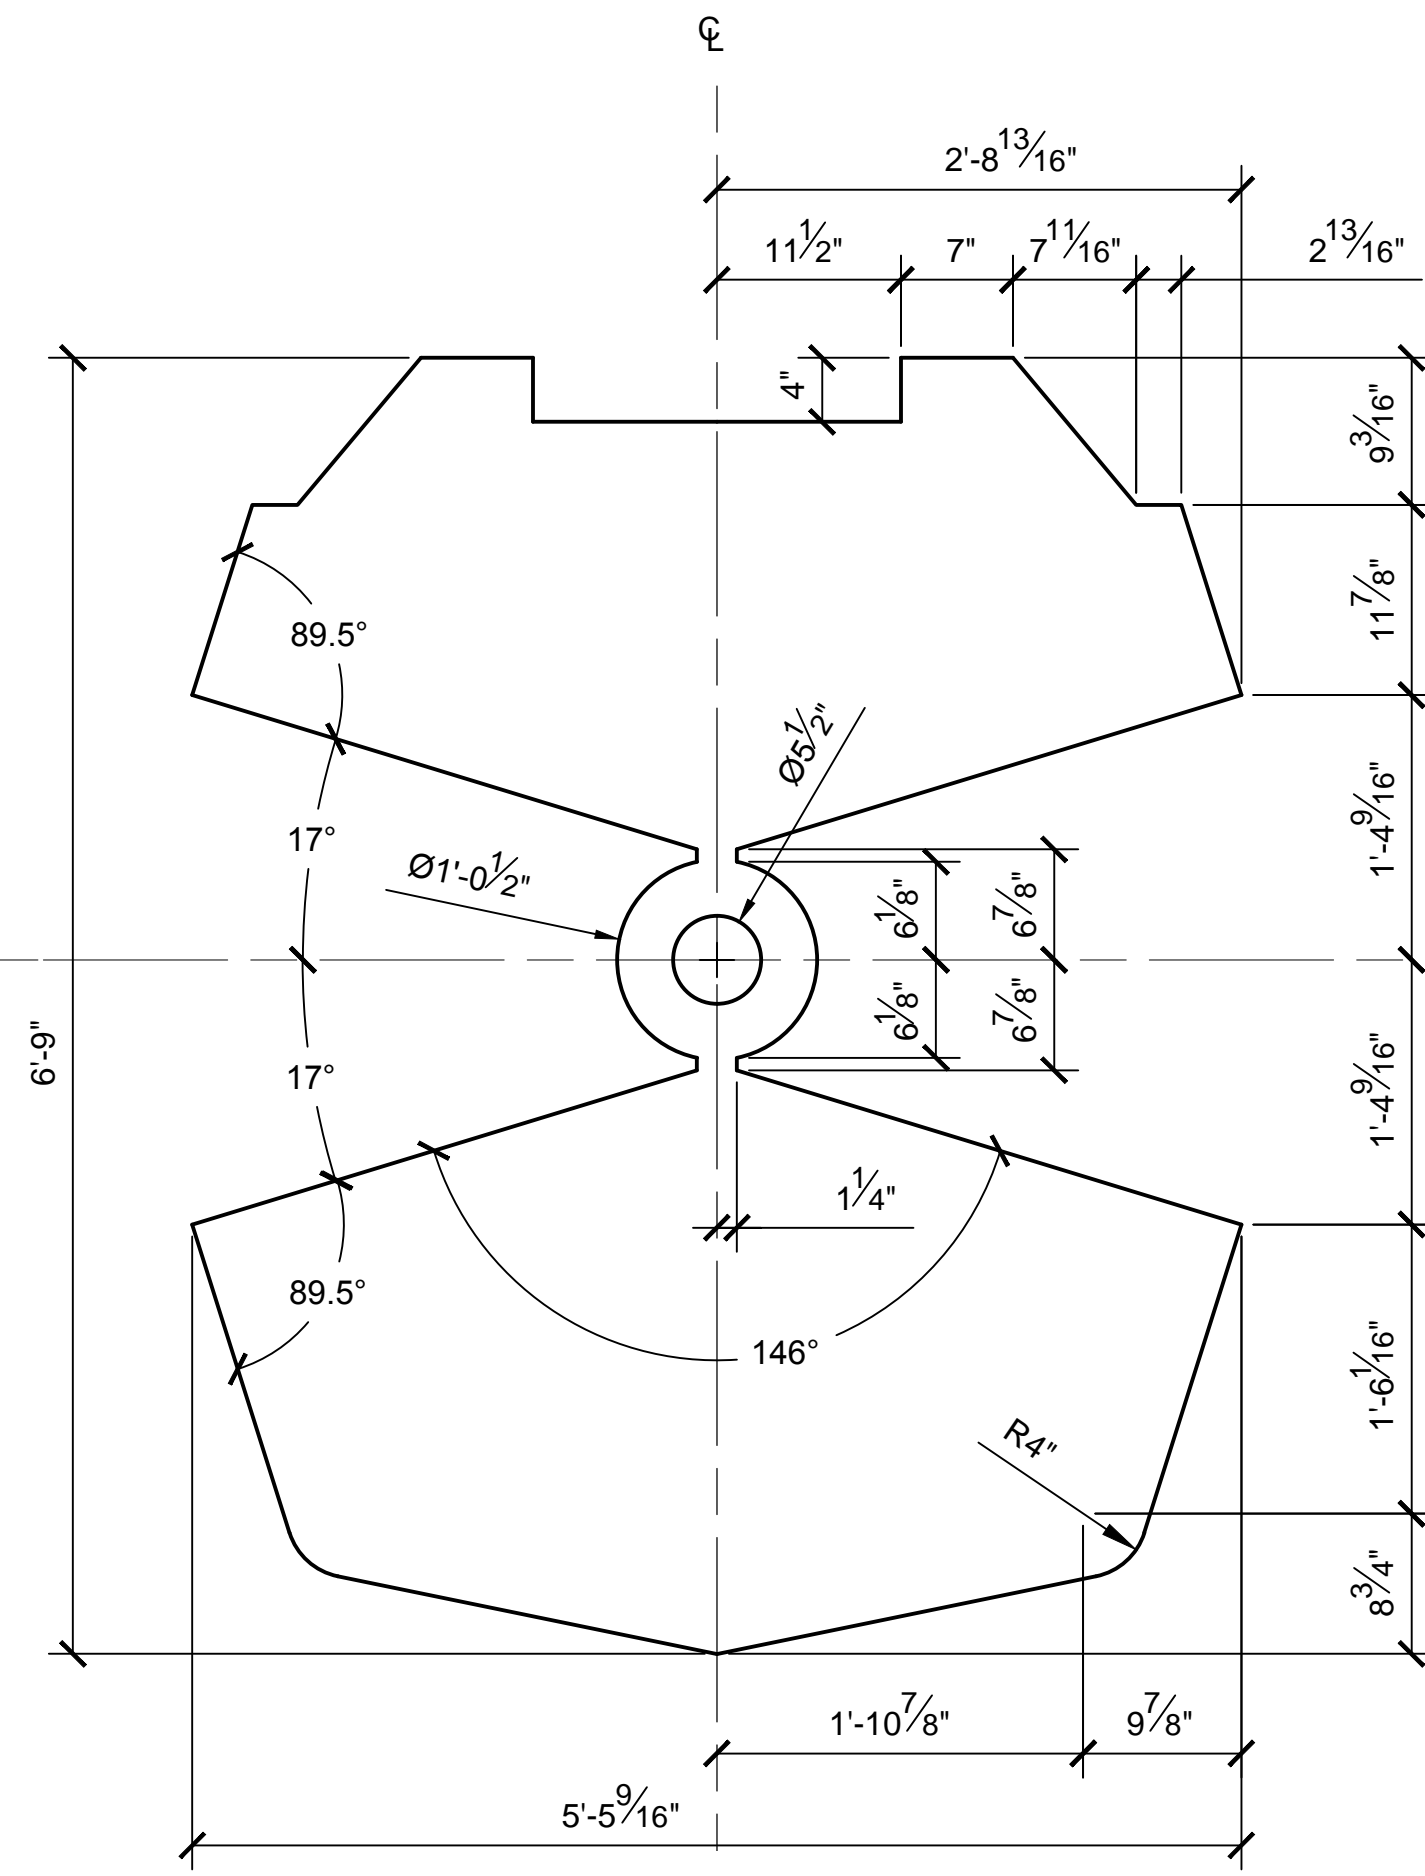

STA 35
SCALE 1:12

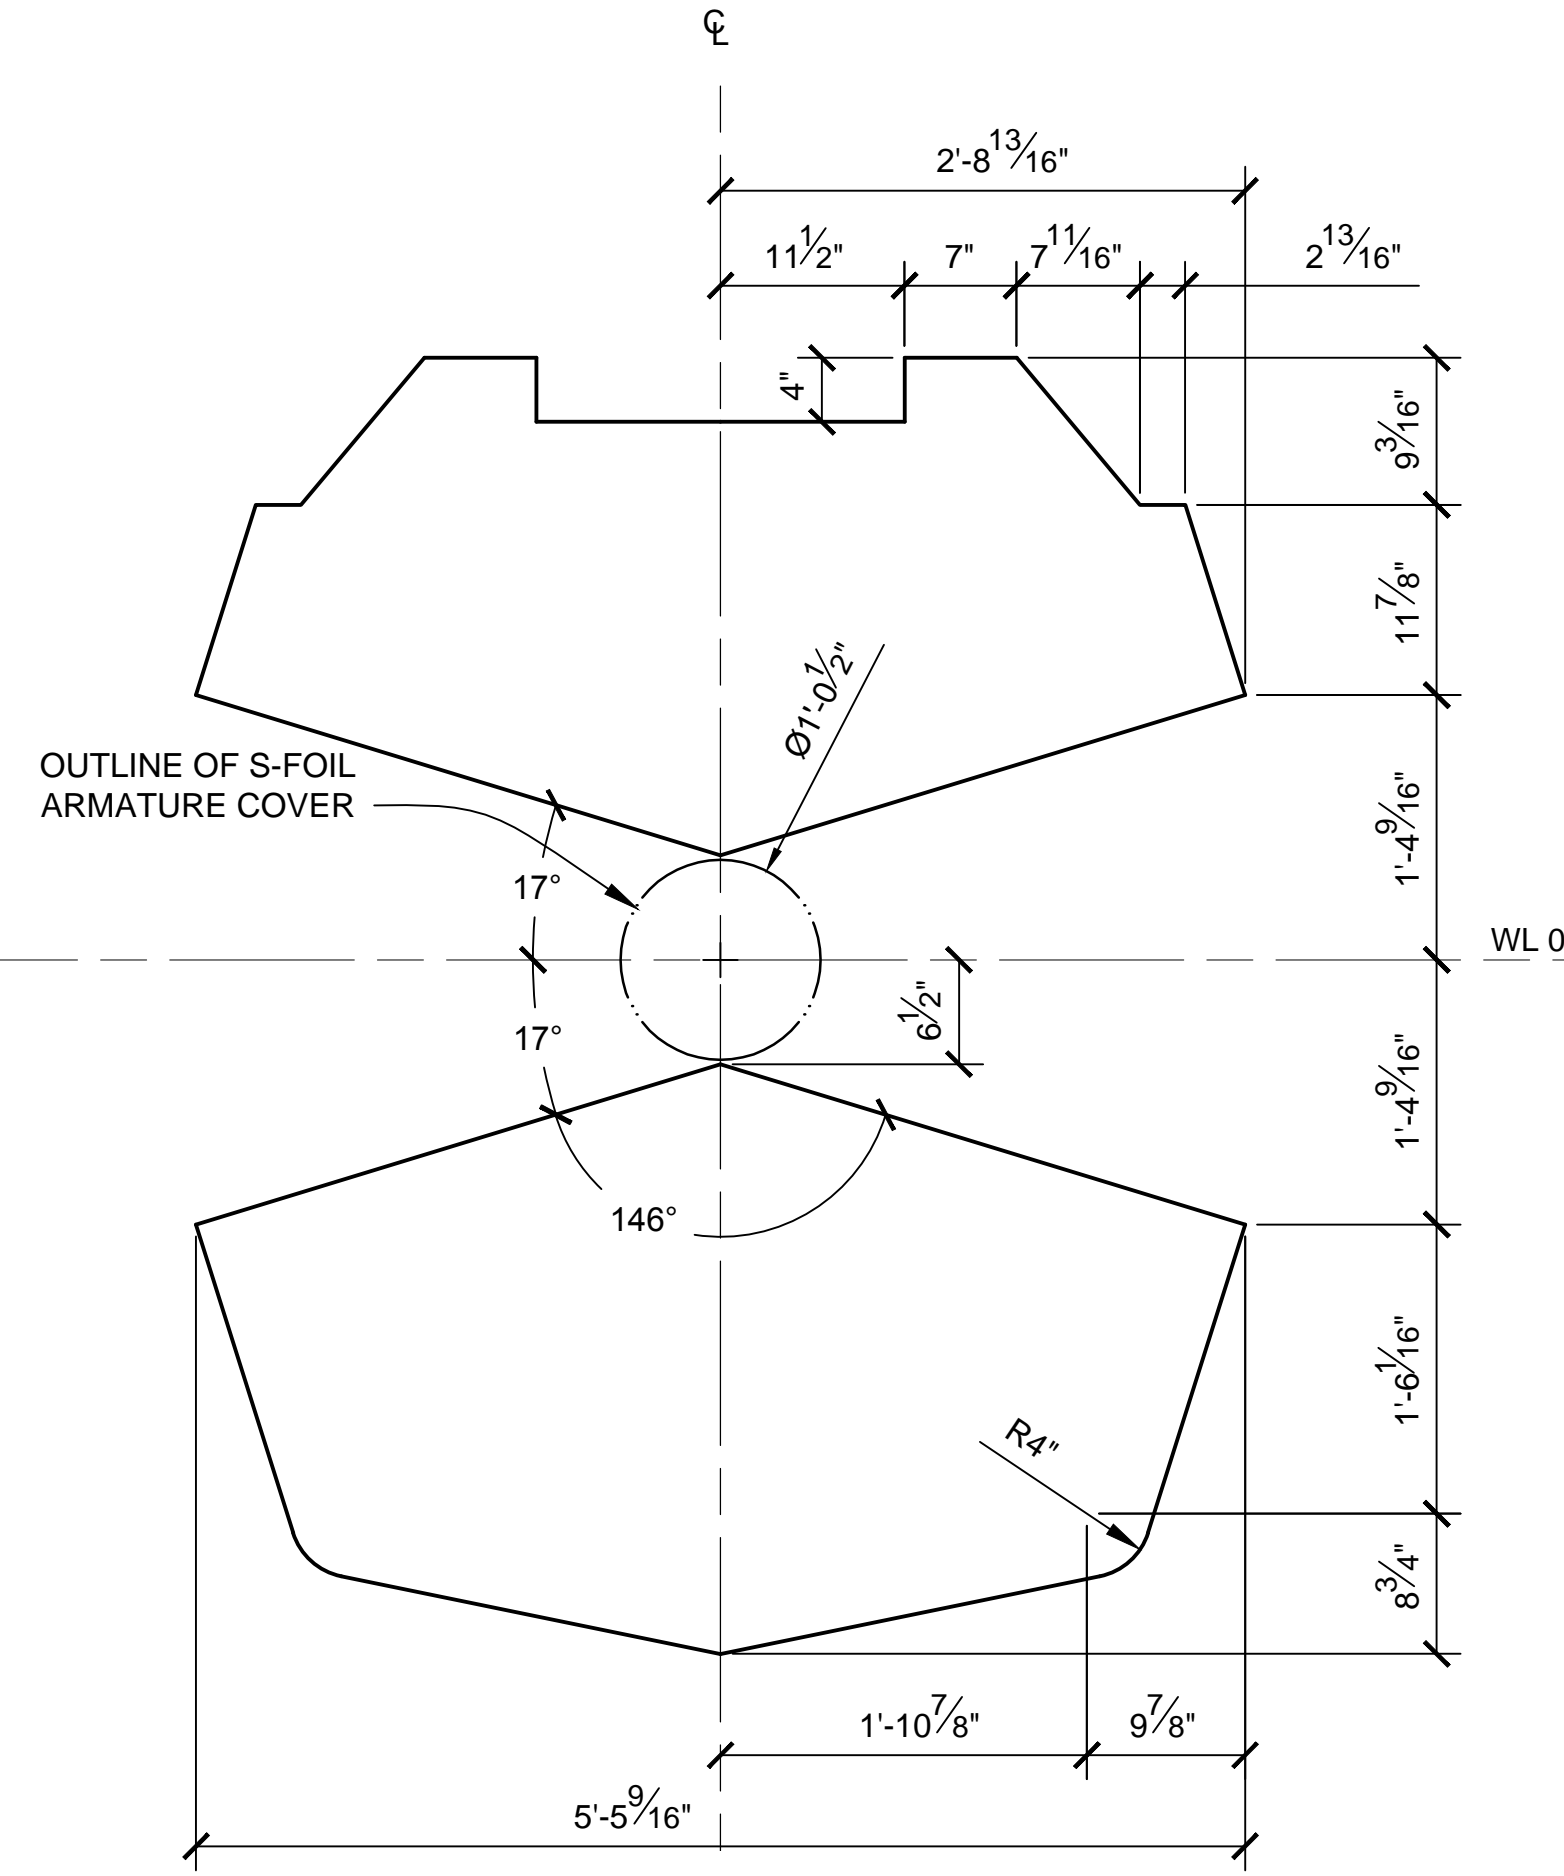

STA 36
SCALE 1:12

NOTES:


1. PRE-EXISTING MATERIAL COPYRIGHTED BY THE STAR WARS CORPORATION AND LUCASFILM LTD.
2. CROSS SECTIONS SHOW OUTSIDE MOLDED SURFACE.
3. CROSS SECTIONS ARE SYMMETRICAL UNLESS OTHERWISE SPECIFIED.

PRODUCTION	D.O.P.	ART DIRECTOR	CAMERA	
ART DEPT.	SET DESIGNER	SCULPTOR	GRAPHICS	
SET DEC.	DRAPES	PROPS	MODEL SHOP	
CONST. COORD.	CARPENTER	PLASTER	PAINT	
GREENS	SCENIC	METALS	SFX	
GRIP	ELECTRICAL	VFX	CGI	


PROJECT				
THE X-WING BUILD				
1:1 SCALE STAGE PROP				
SET				SET NO.
TITLE	FUSELAGE SECTIONS			REV
			--	
PROD DESIGNER			DATE DRAWN	
			3/SEP/2012	
DRAWN BY		APPROVED BY		DATE ISSUED
B.J.S.				DD/MM/YYYY
STAGE		LOCATION		DWG NO.
FILE X-WING LINES_MASTER.DWG		SHEET 8	OF XX	

2.06


SCALE: 1:12

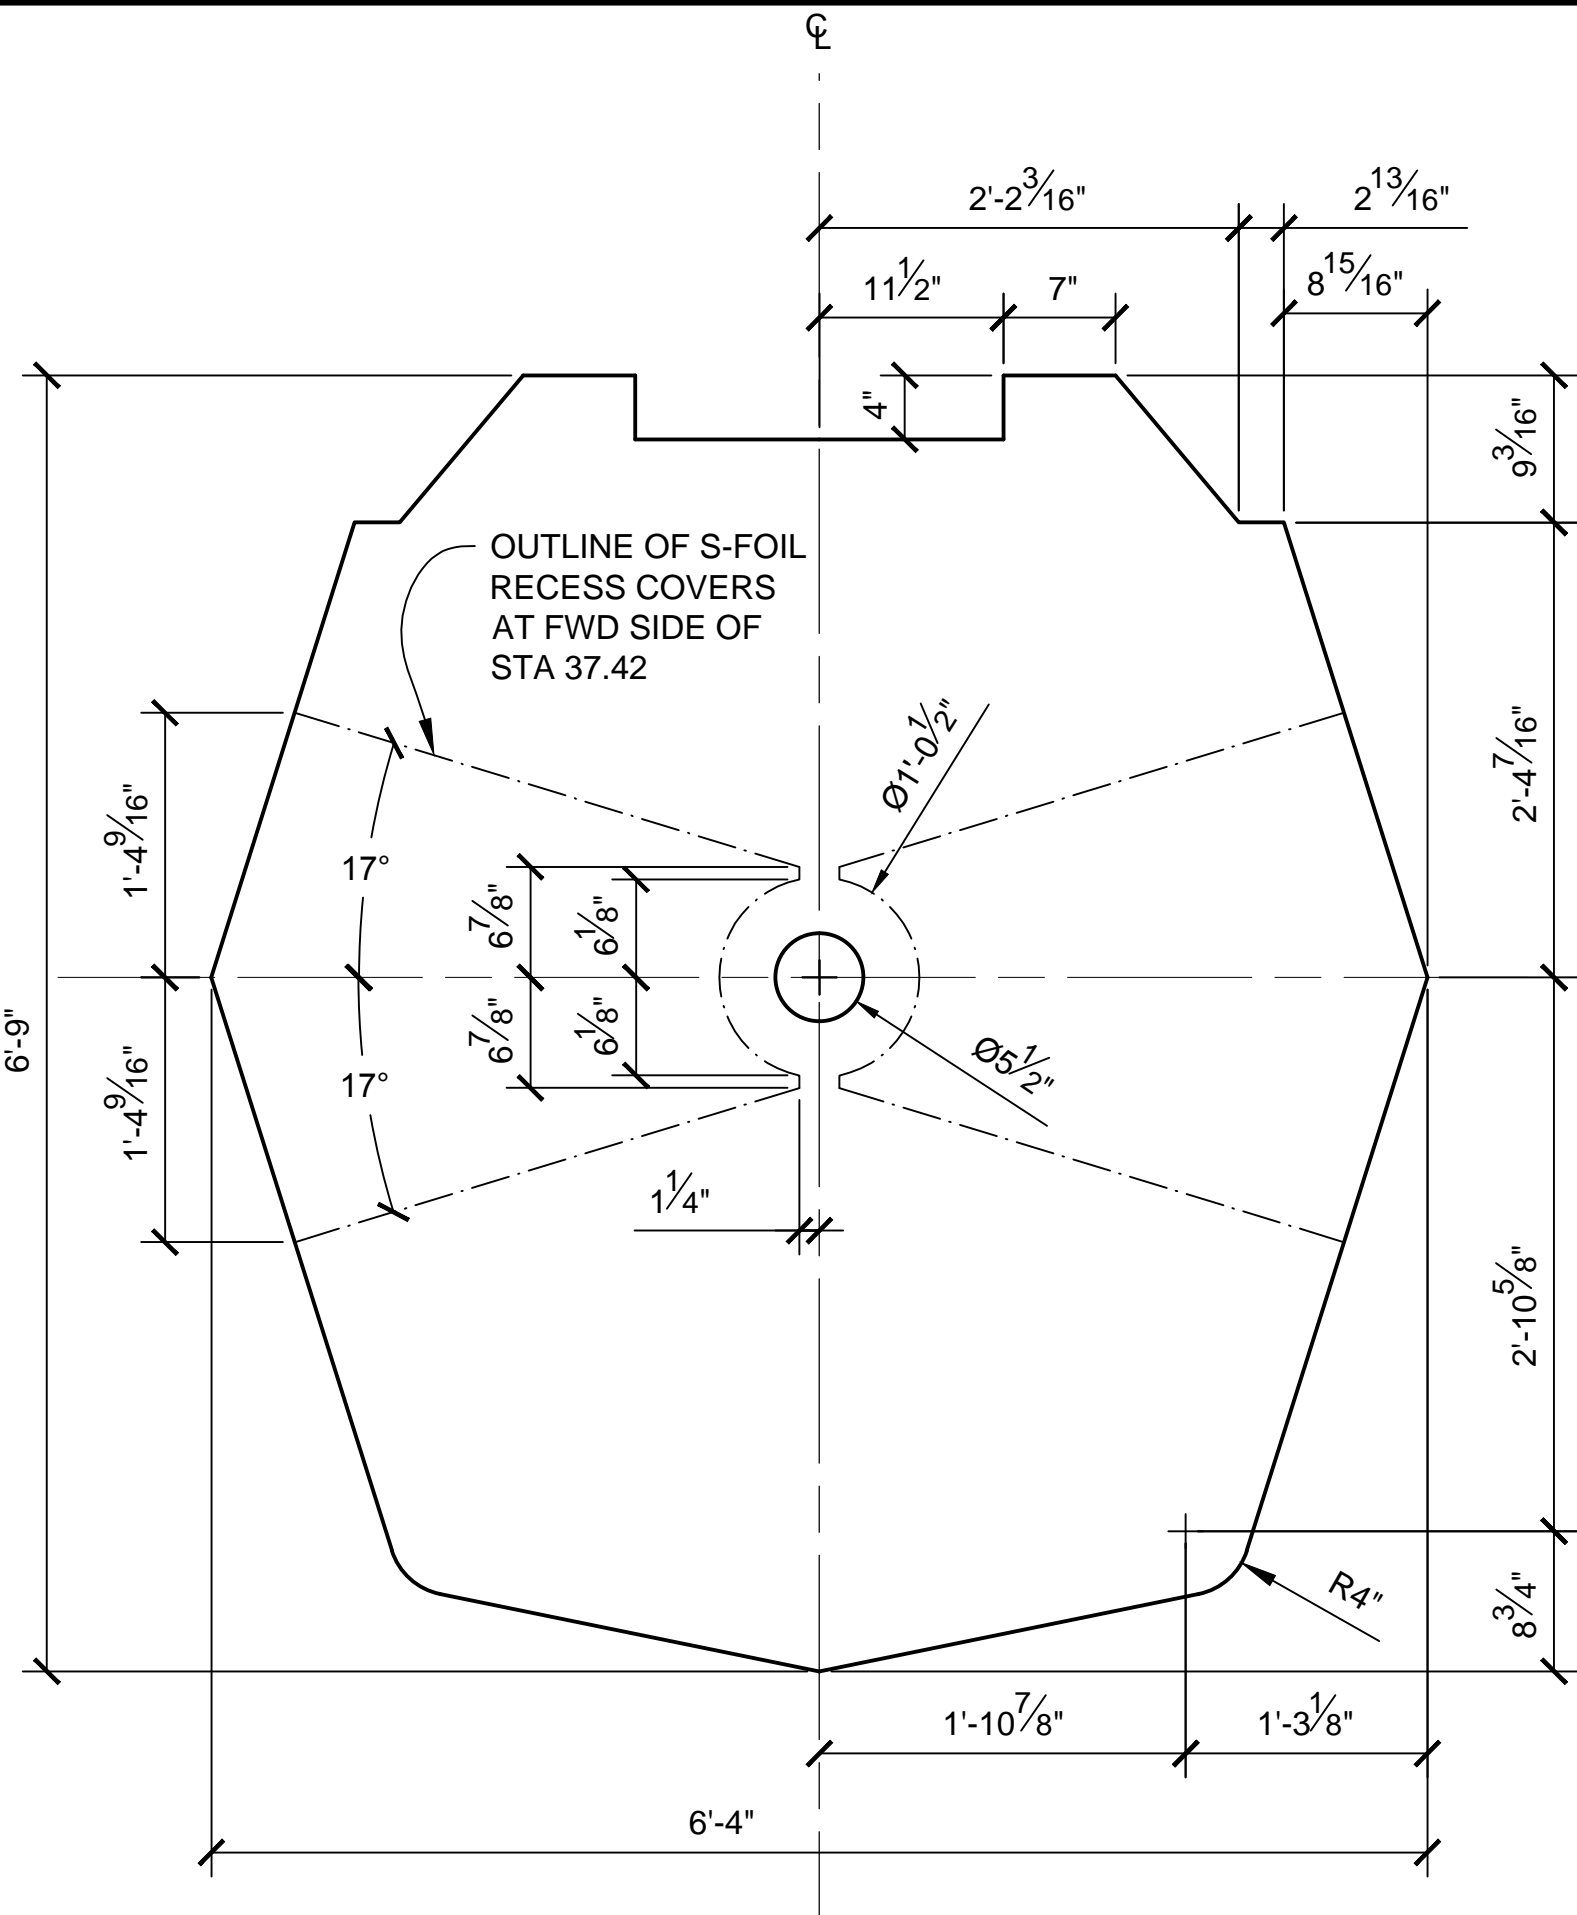

STA 37.42
SCALE 1:12

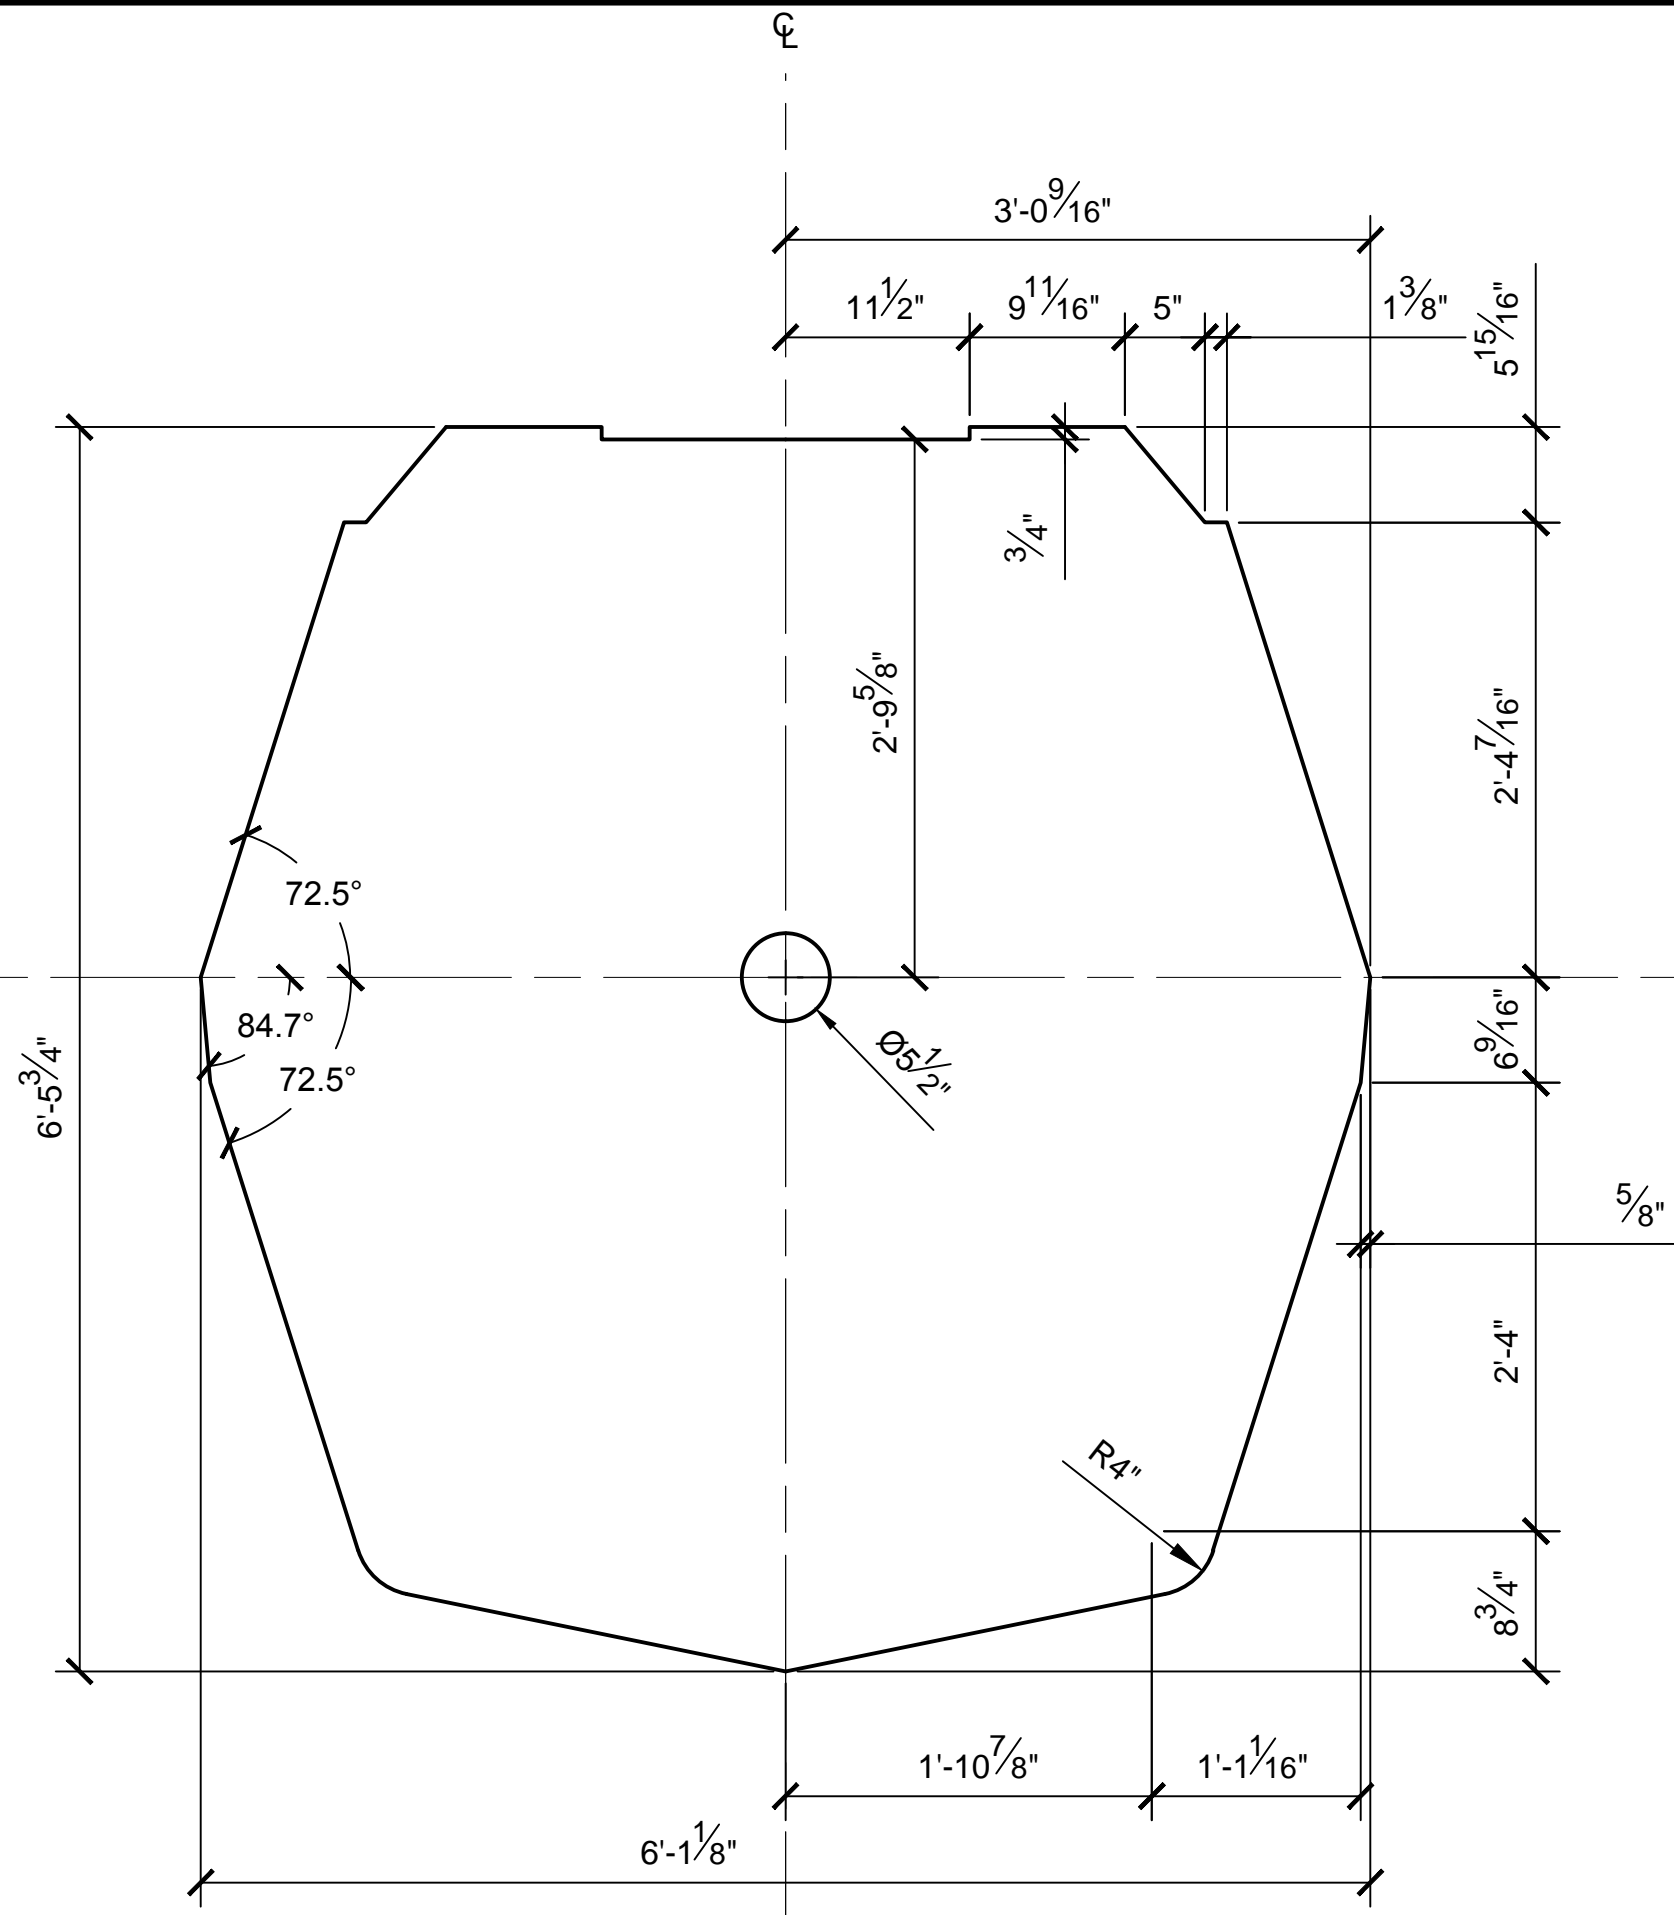


STA 38
SCALE 1:12

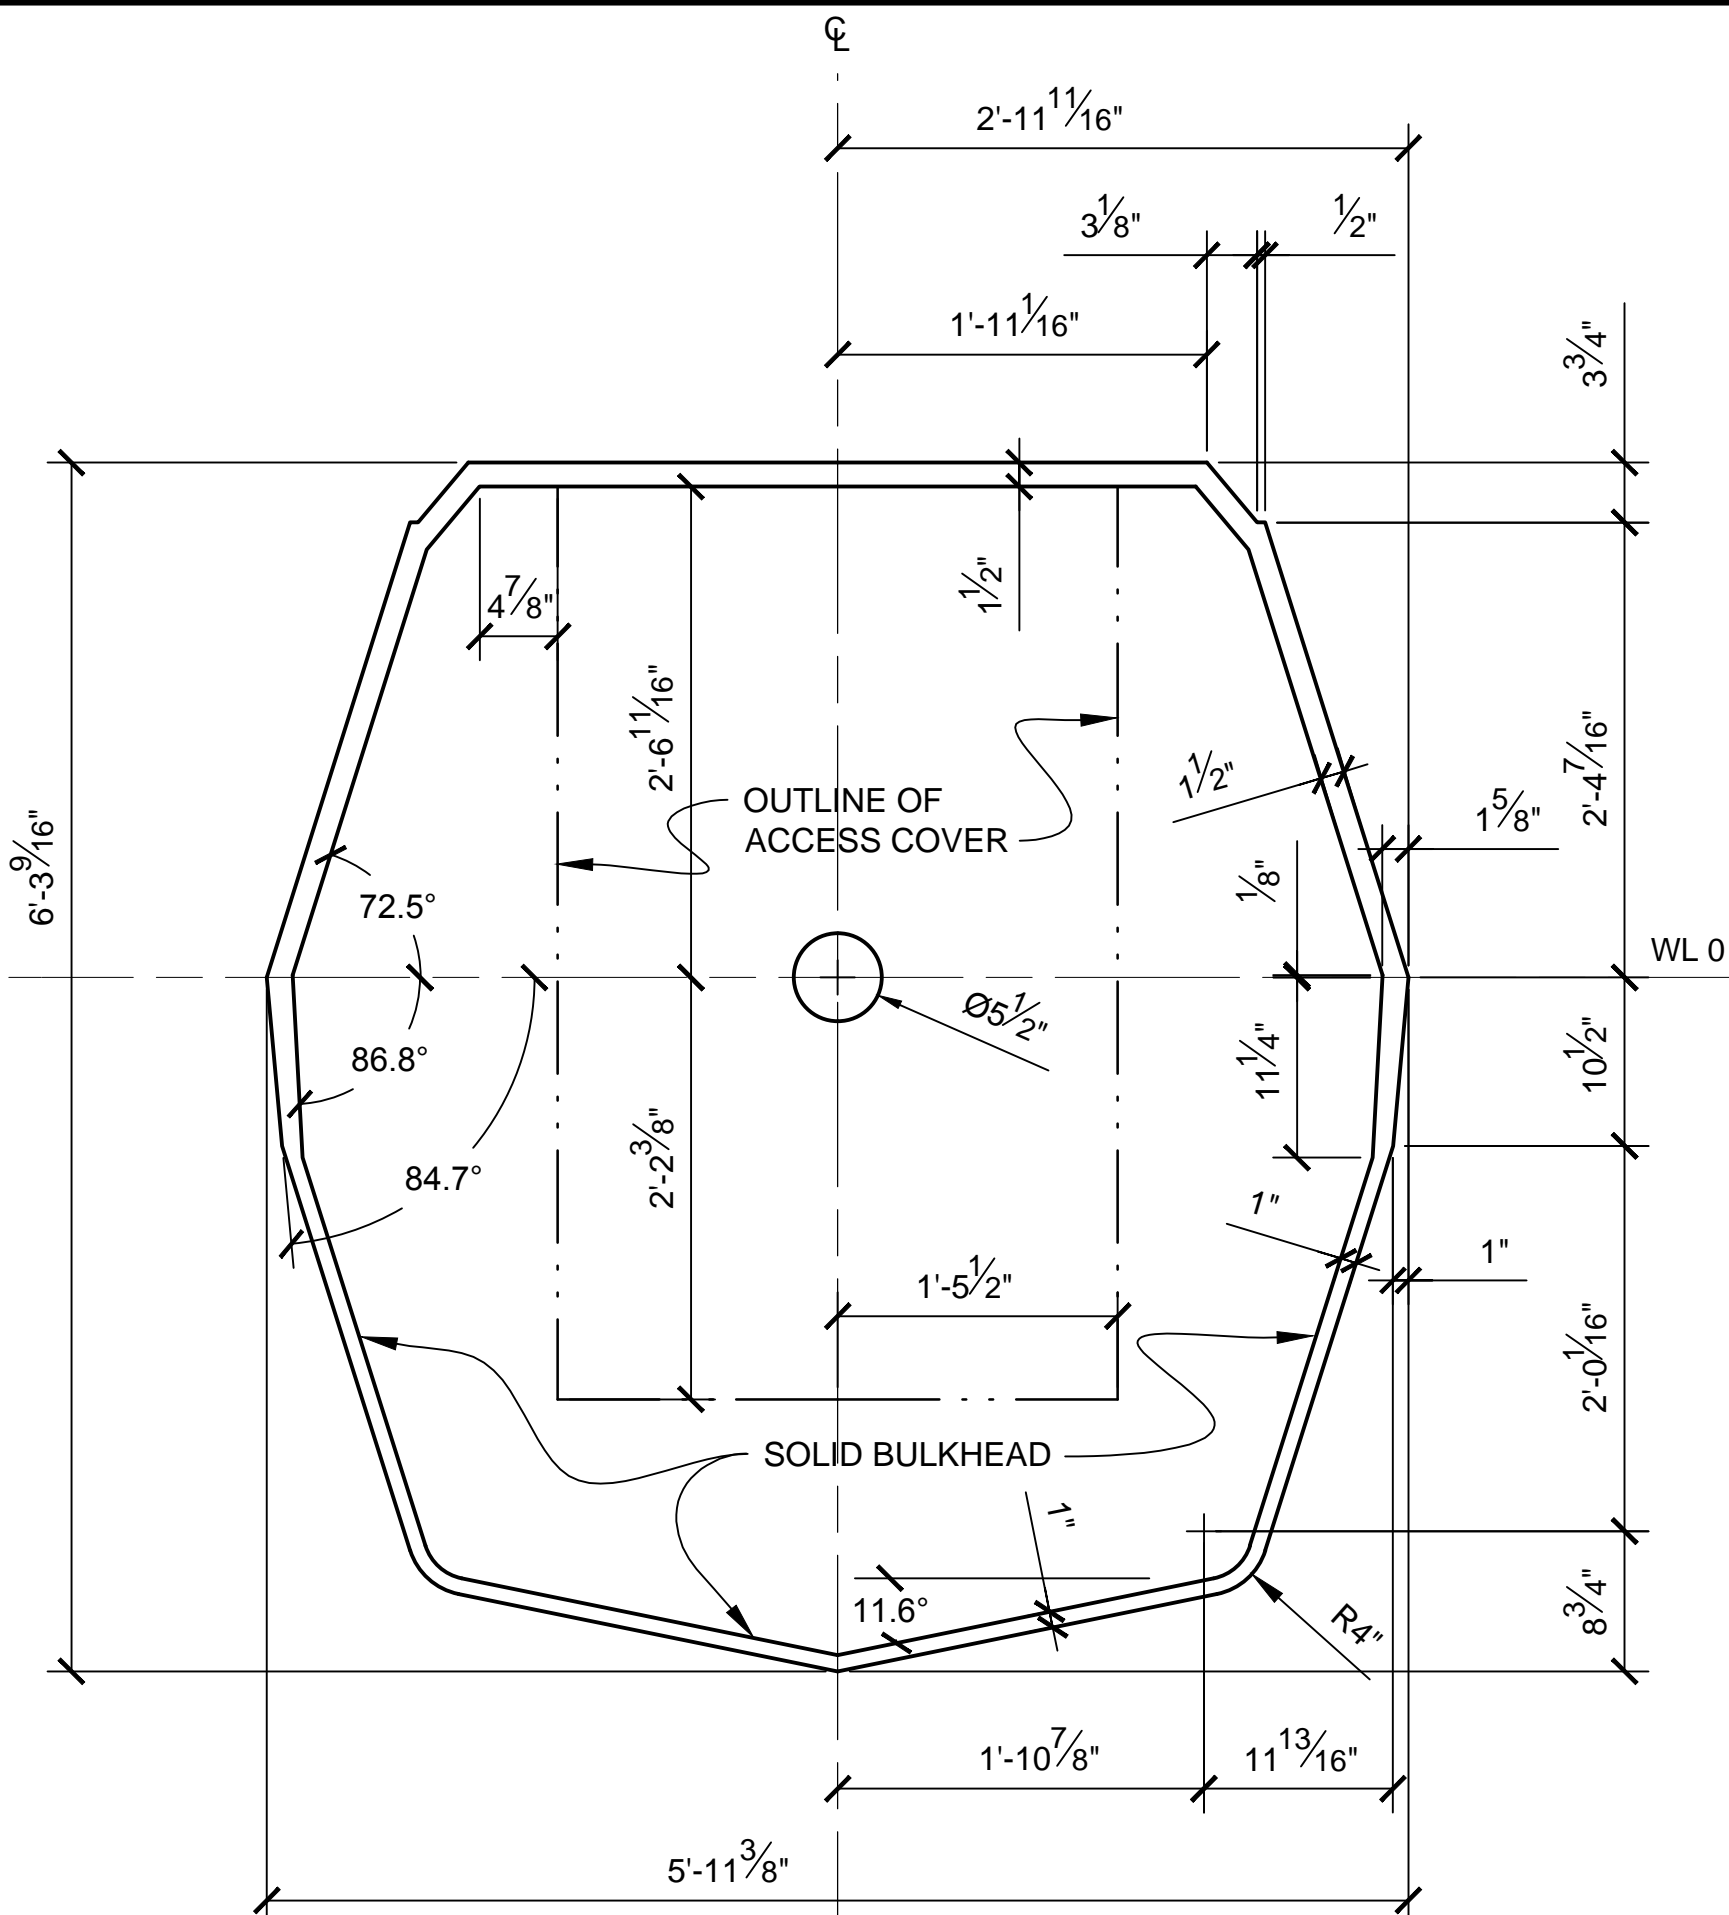

STA 38.25
SCALE 1:12

- NOTES:**
1. PRE-EXISTING MATERIAL COPYRIGHTED BY THE STAR WARS CORPORATION AND LUCASFILM LTD.
 2. CROSS SECTIONS SHOW OUTSIDE MOLDED SURFACE.
 3. CROSS SECTIONS ARE SYMMETRICAL UNLESS OTHERWISE SPECIFIED.

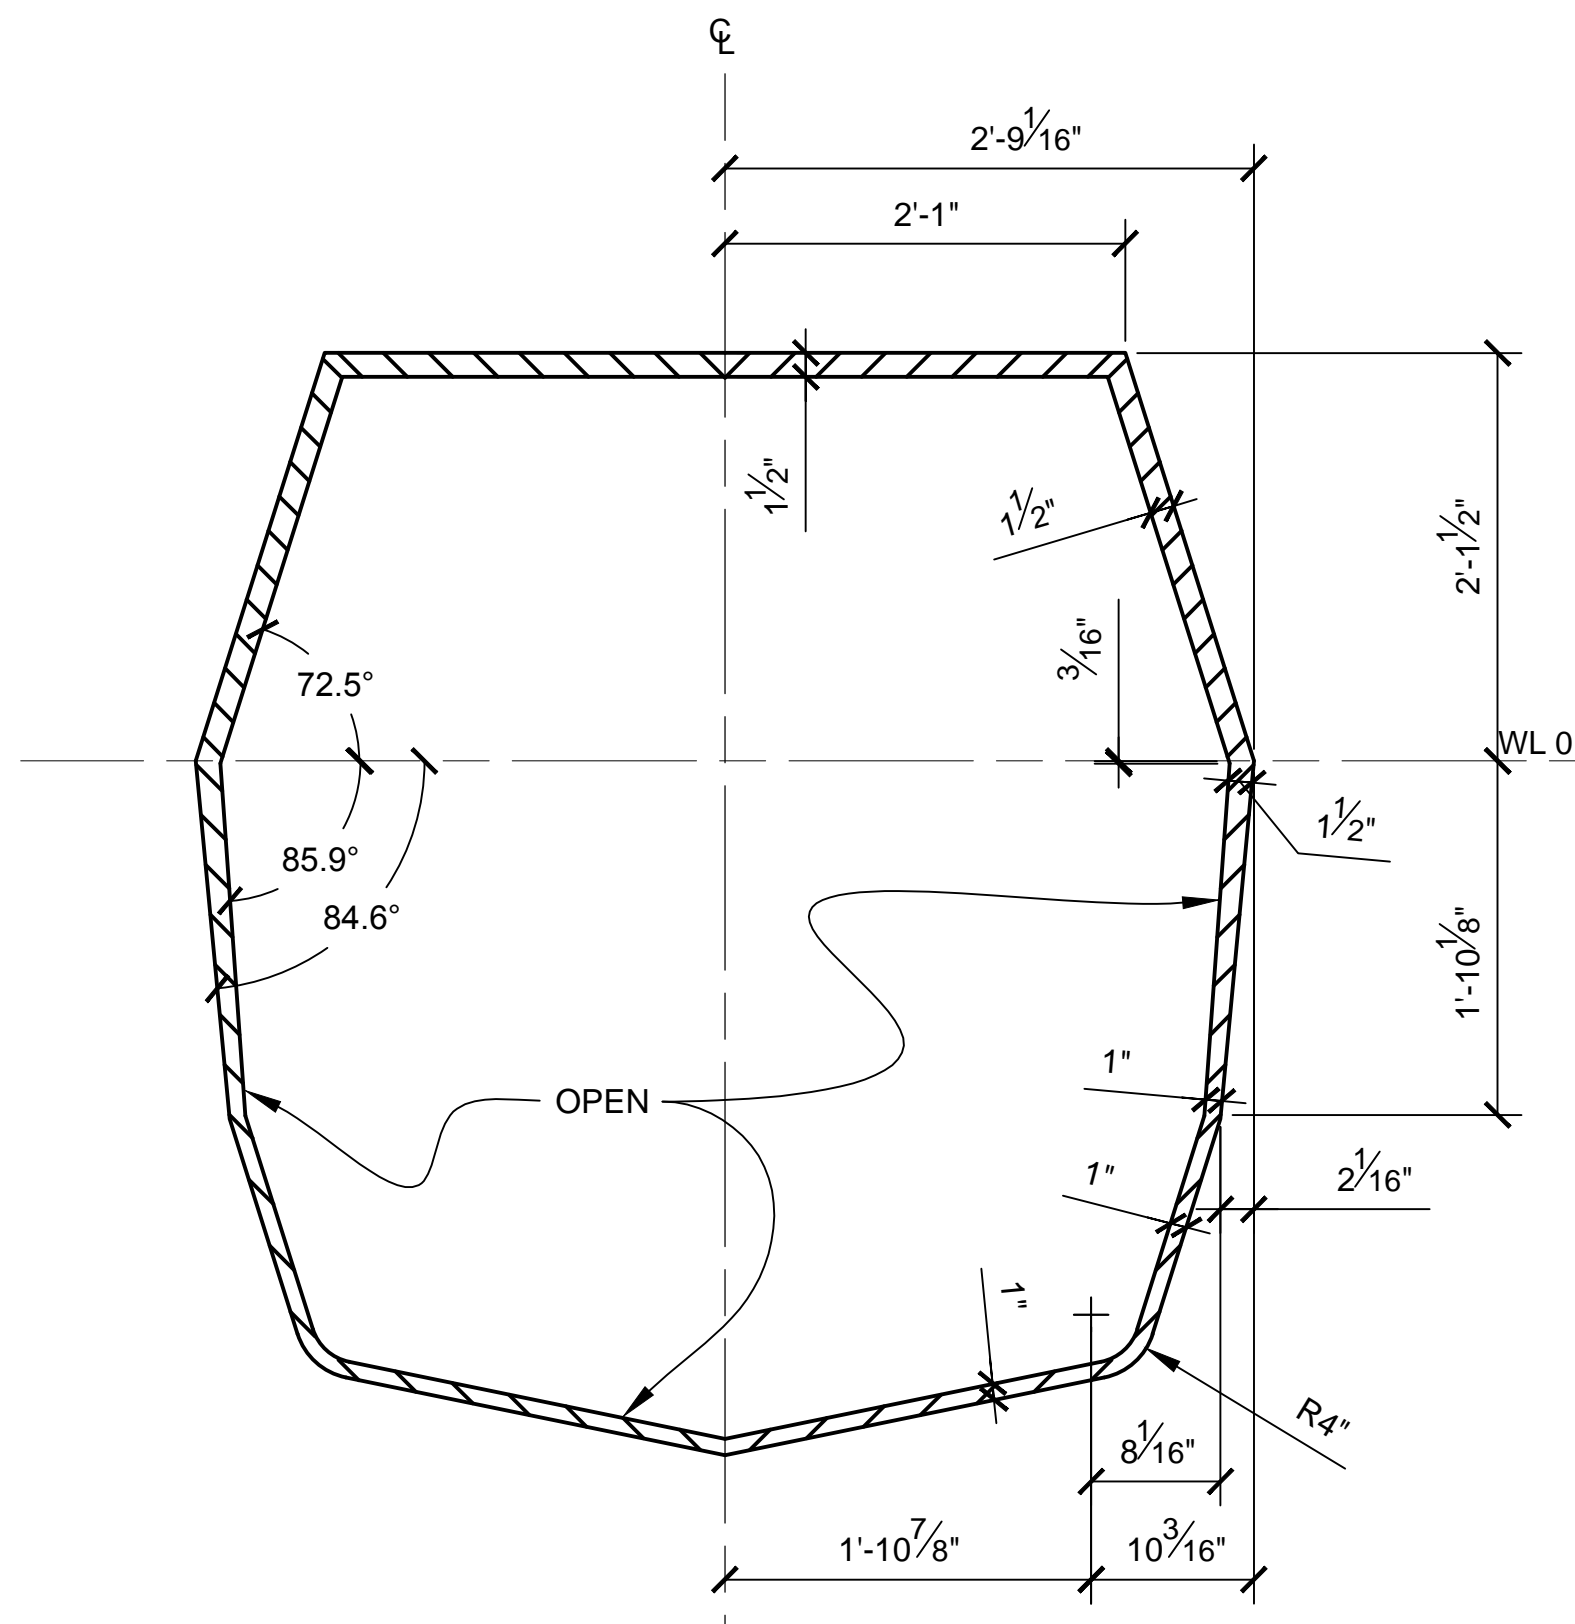


STA 39
SCALE 1:12




PRODUCTION	D.O.P.	ART DIRECTOR	CAMERA	
ART DEPT.	SET DESIGNER	SCULPTOR	GRAPHICS	
SET DEC.	DRAPES	PROPS	MODEL SHOP	
CONST. COORD.	CARPENTER	PLASTER	PAINT	
GREENS	SCENIC	METALS	SFX	
GRIP	ELECTRICAL	VFX	CGI	

PROJECT				
THE X-WING BUILD				
1:1 SCALE STAGE PROP				
SET				SET NO.
TITLE	FUSELAGE SECTIONS			REV
PROD DESIGNER			DATE DRAWN	
DRAWN BY			3/SEP/2012	
STAGE			DATE ISSUED	
LOCATION			DD/MMM/YYYY	
FILE			DWG NO.	
X-WING LINES_MASTER.DWG			2.07	
SHEET			OF	
9			XX	

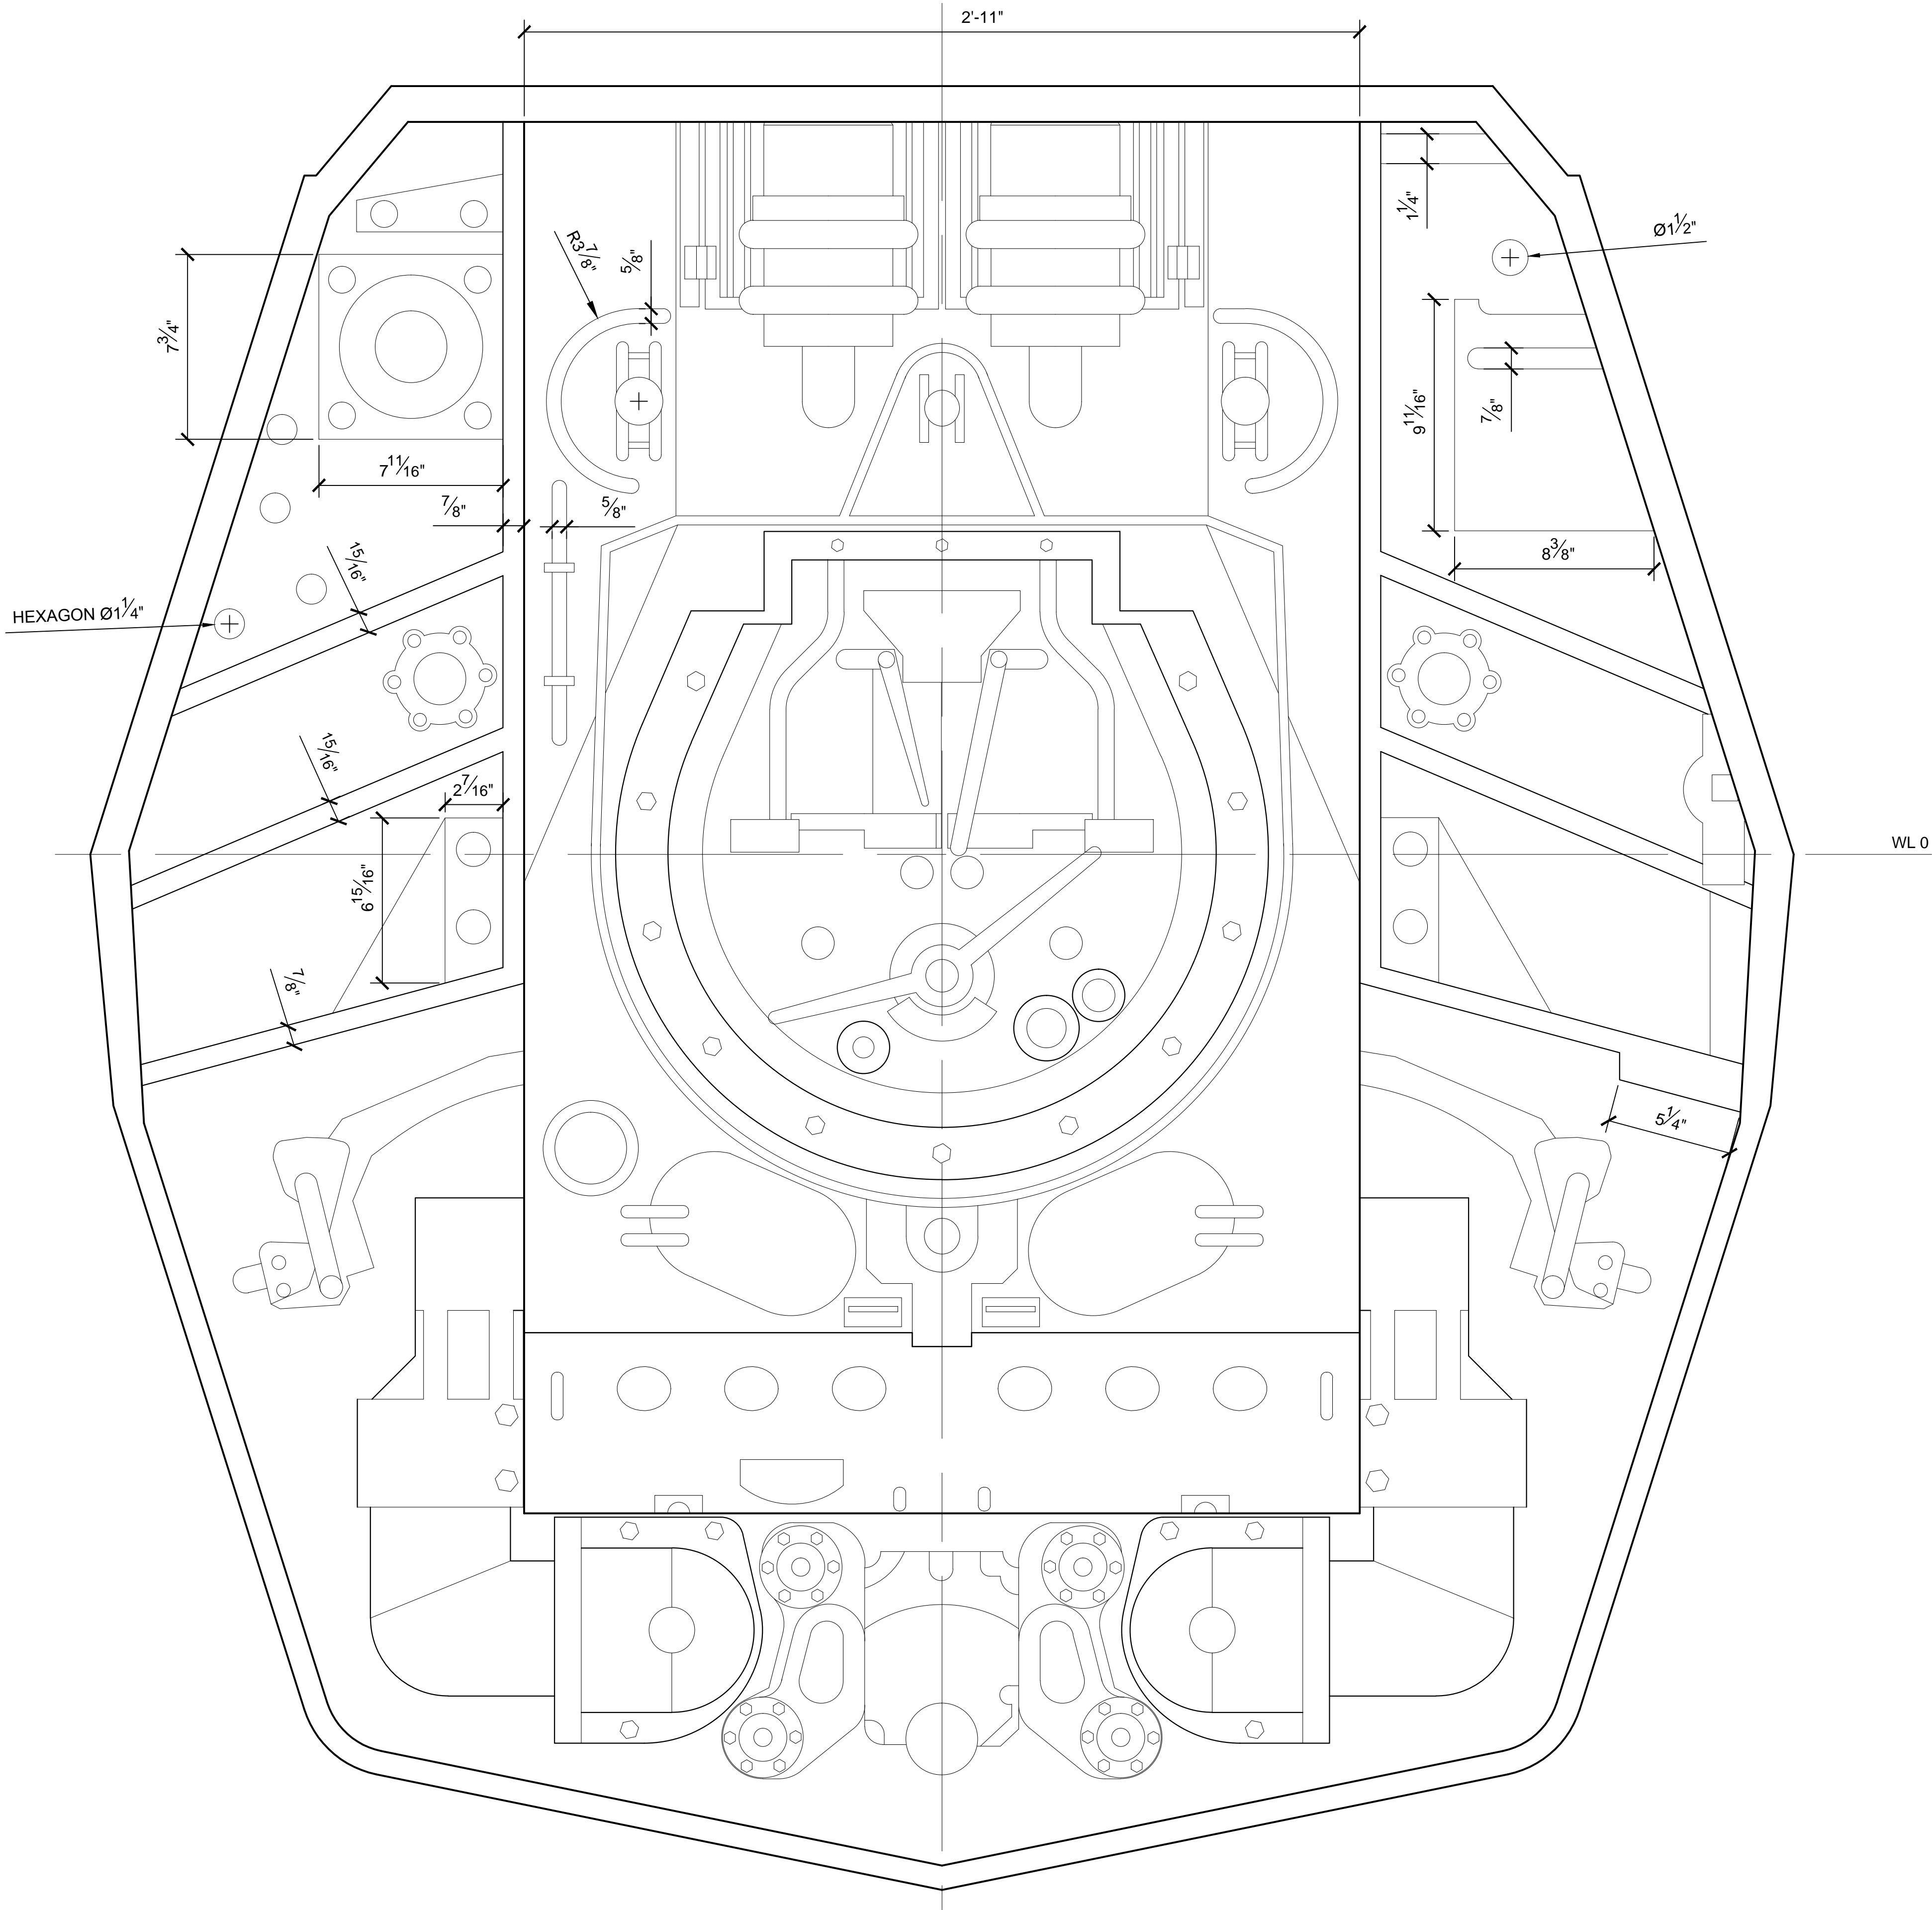


STA 38.25 - DETAILS
SCALE 1:4

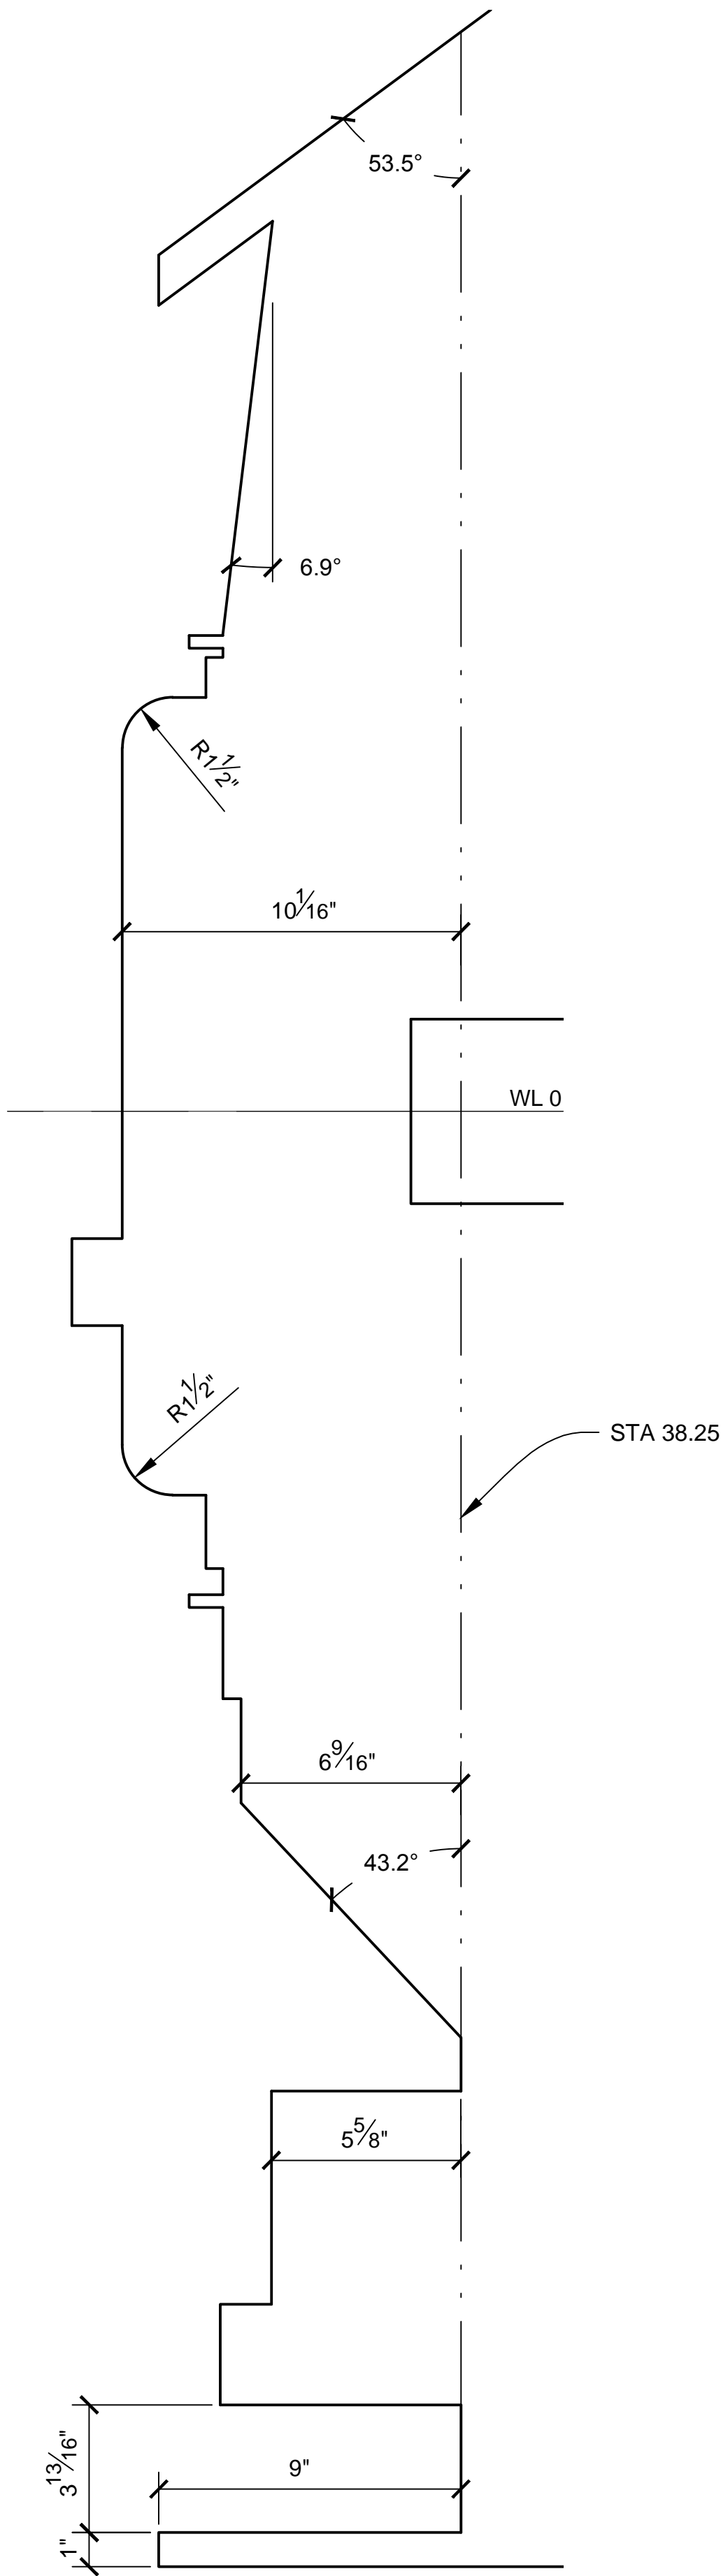


AFT BULKHEAD CENTERLINE PROFILE
SCALE 1:4





 
NOTES:
1. PREEXISITNG MATERIAL COPYRIGHTED BY THE STAR WARS CORPORATION AND LUCASFILM LTD.



PRODUCTION	D.O.P.	ART DIRECTOR	CAMERA	
ART DEPT.	SET DESIGNER	SCULPTOR	GRAPHICS	
SET DEC.	DRAPES	PROPS	MODEL SHOP	
CONST. COORD.	CARPENTER	PLASTER	PAINT	
GREENS	SCENIC	METALS	SFX	
GRIP	ELECTRICAL	VFX	CGI	


PROJECT				
THE X-WING BUILD				
1:1 SCALE STAGE PROP				
SET				SET NO.
TITLE	FUSELAGE DETAILS AFT BULKHEAD			REV --
PROD DESIGNER			DATE DRAWN 3/SEP/2012	
DRAWN BY B.J.S.		APPROVED BY		DATE ISSUED DD/MM/YYYY
STAGE		LOCATION		DWG NO.
FILE X-WING LINES_MASTER.DWG		SHEET 10 OF XX		2.08

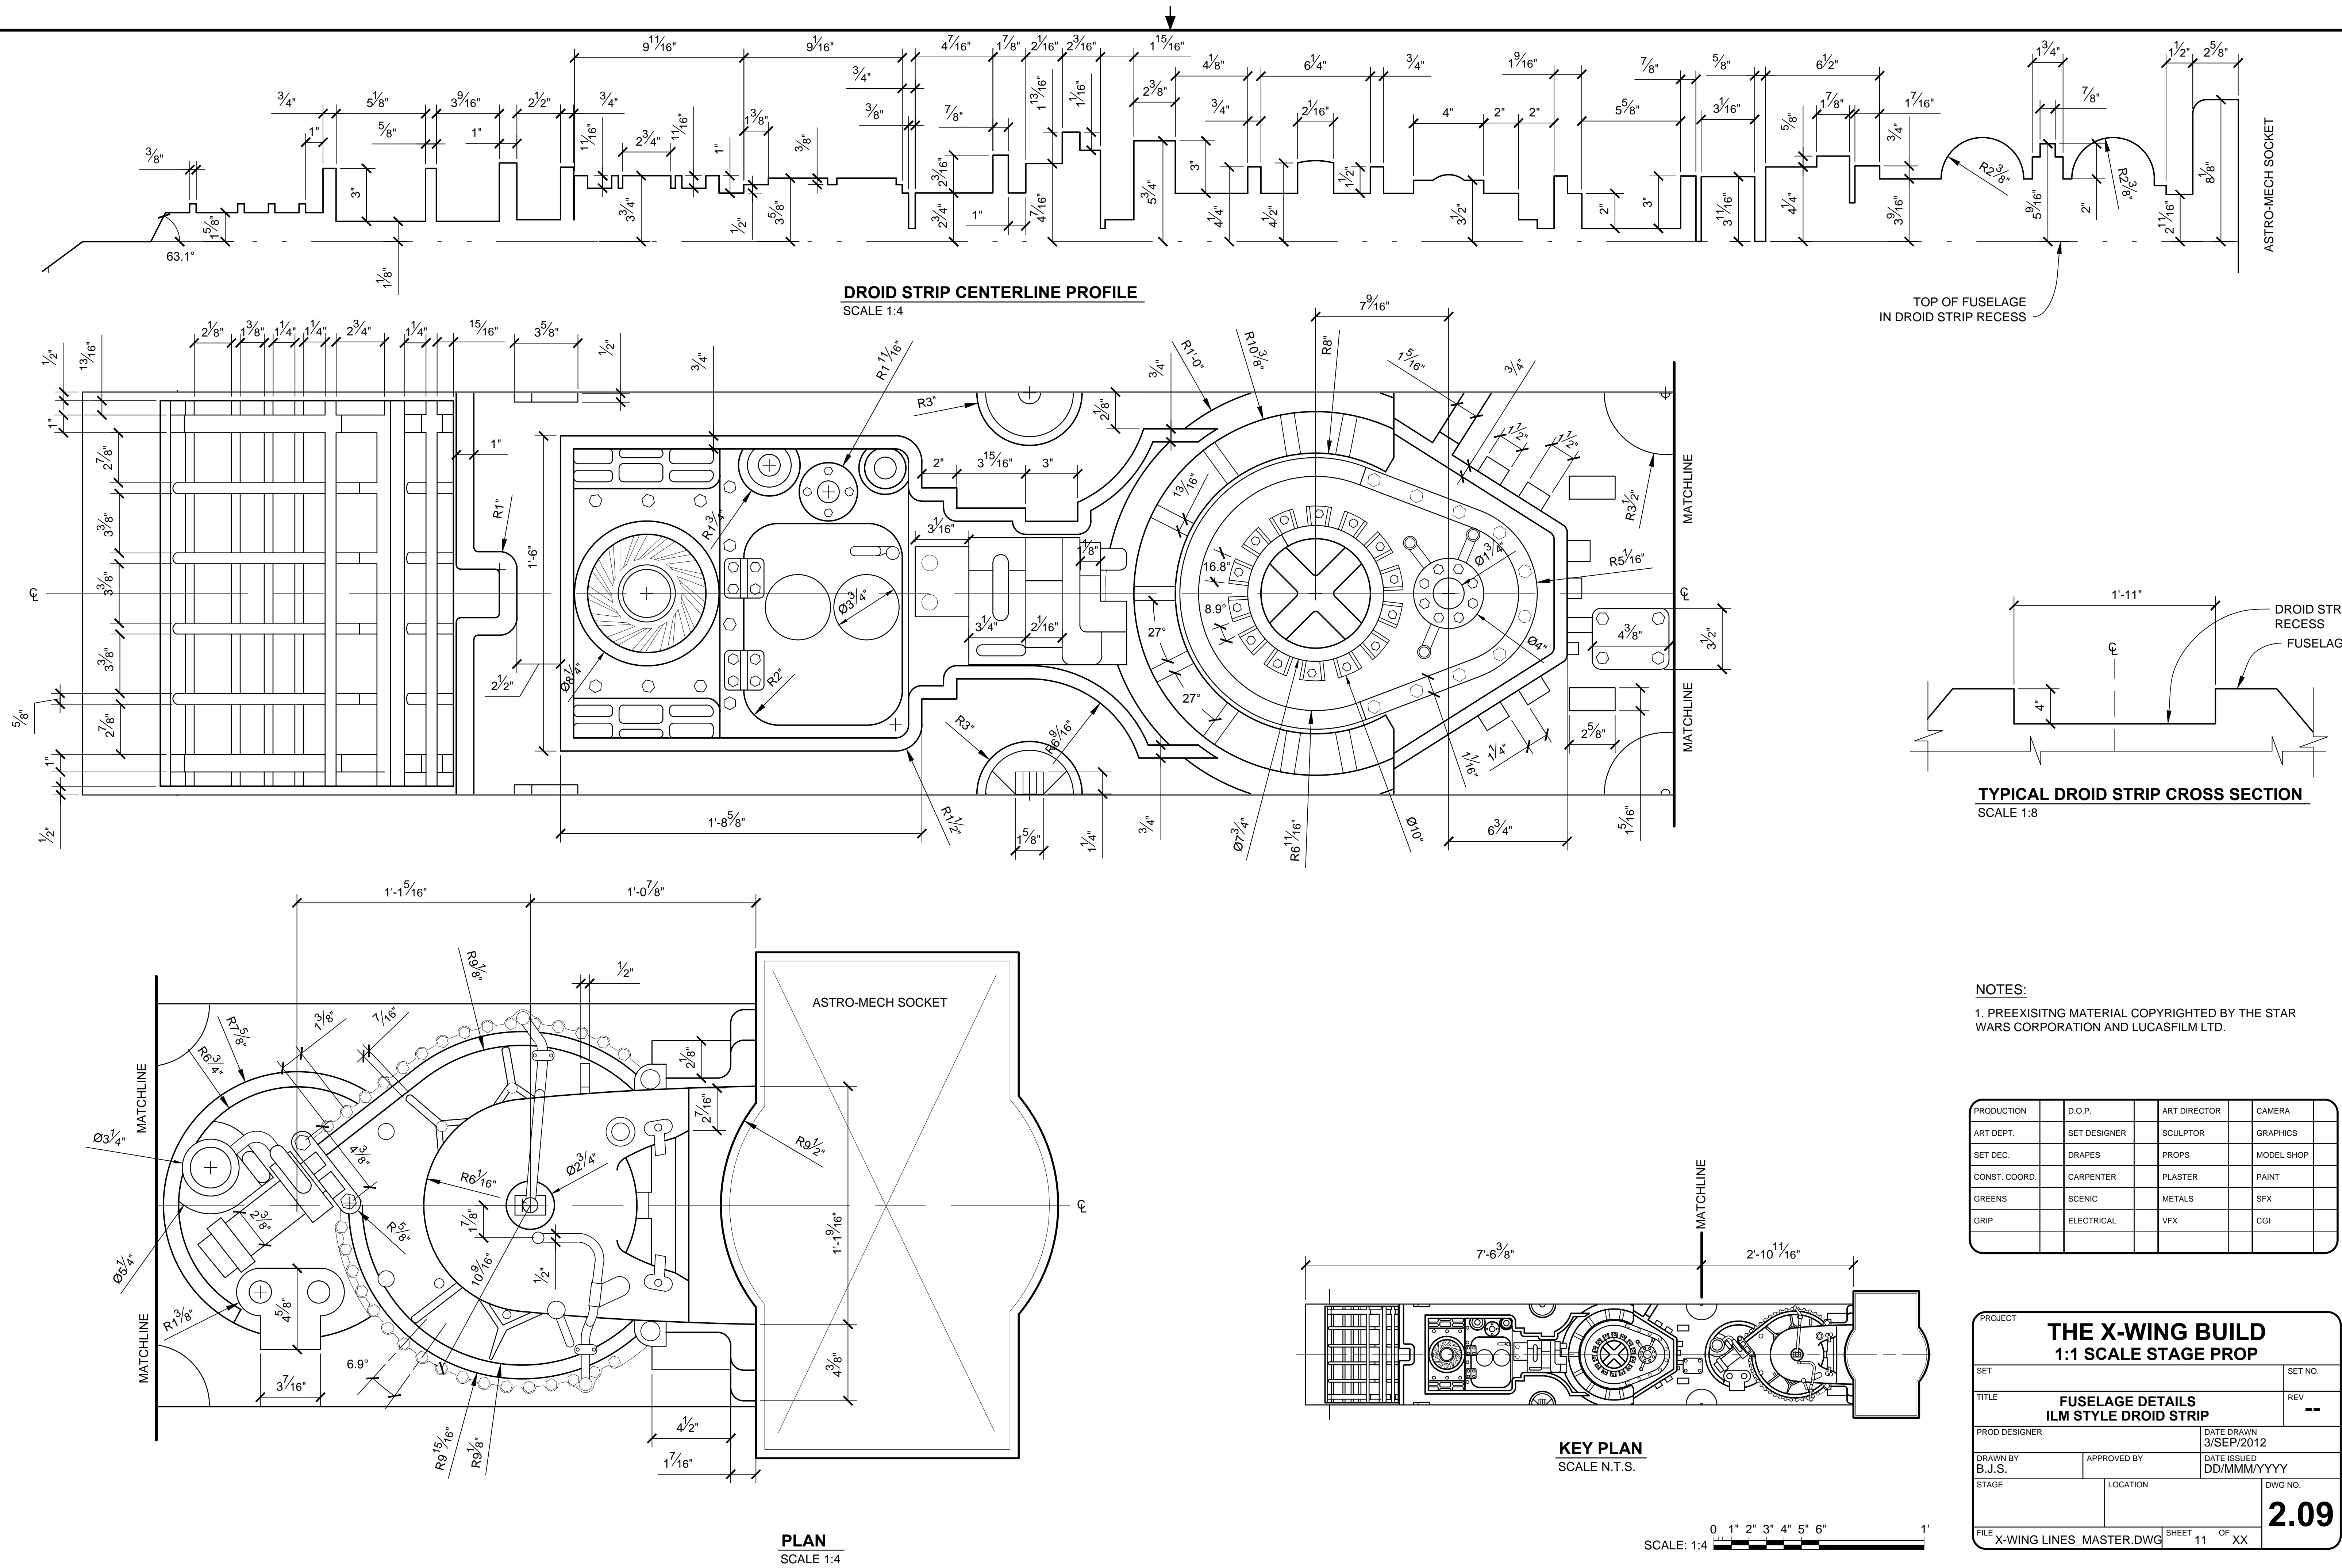

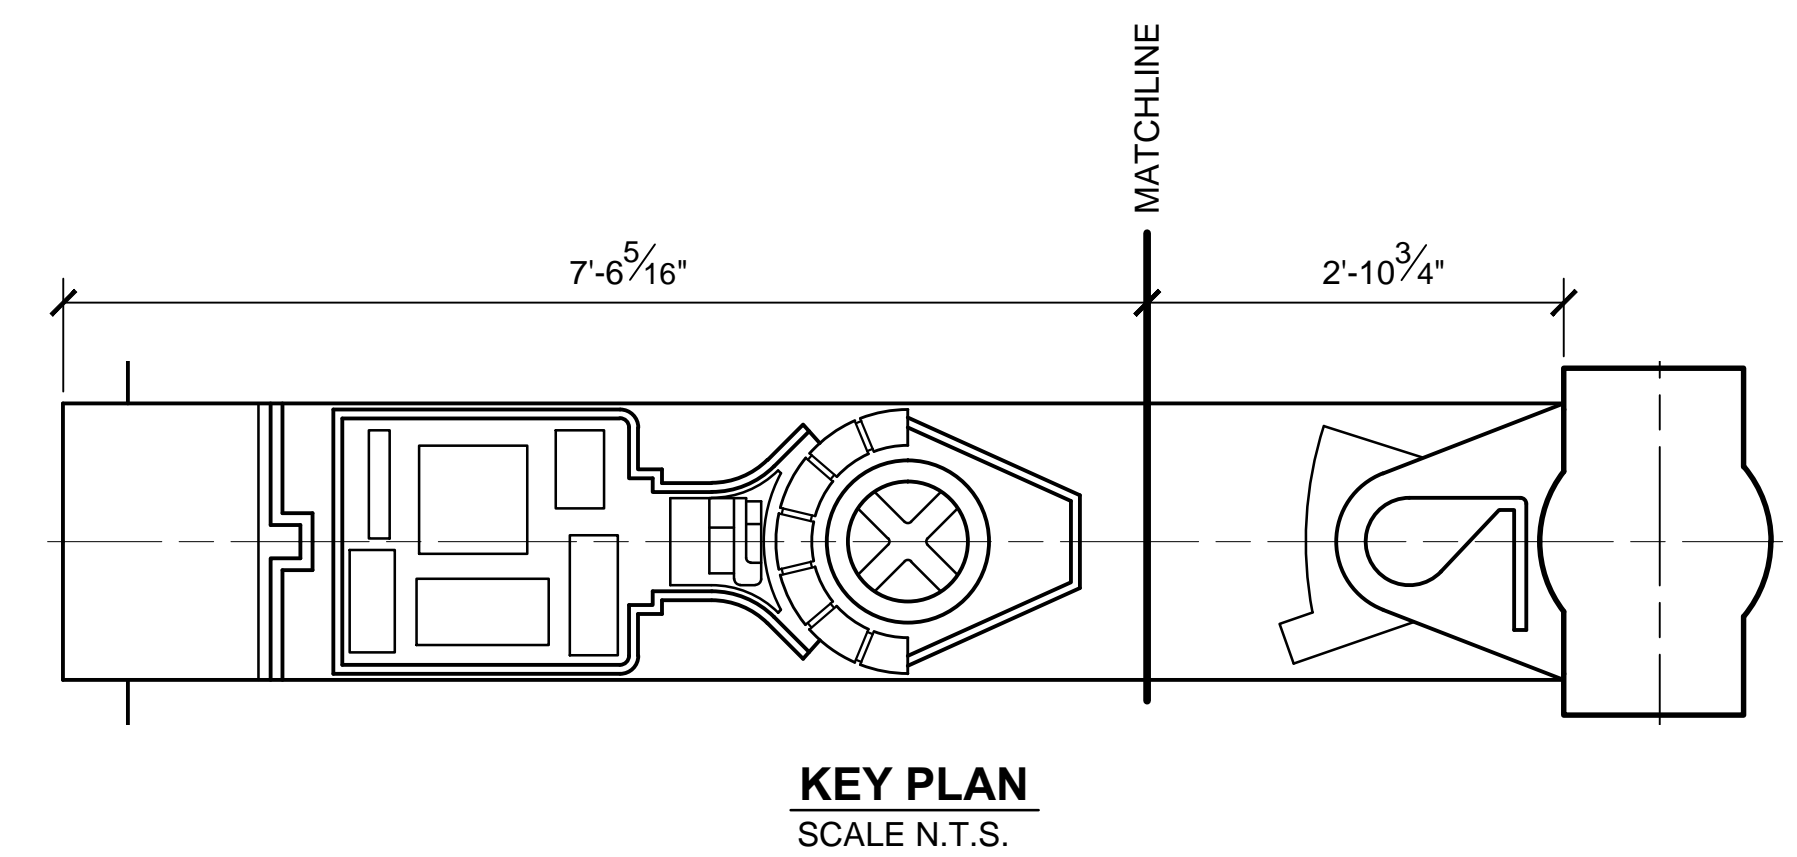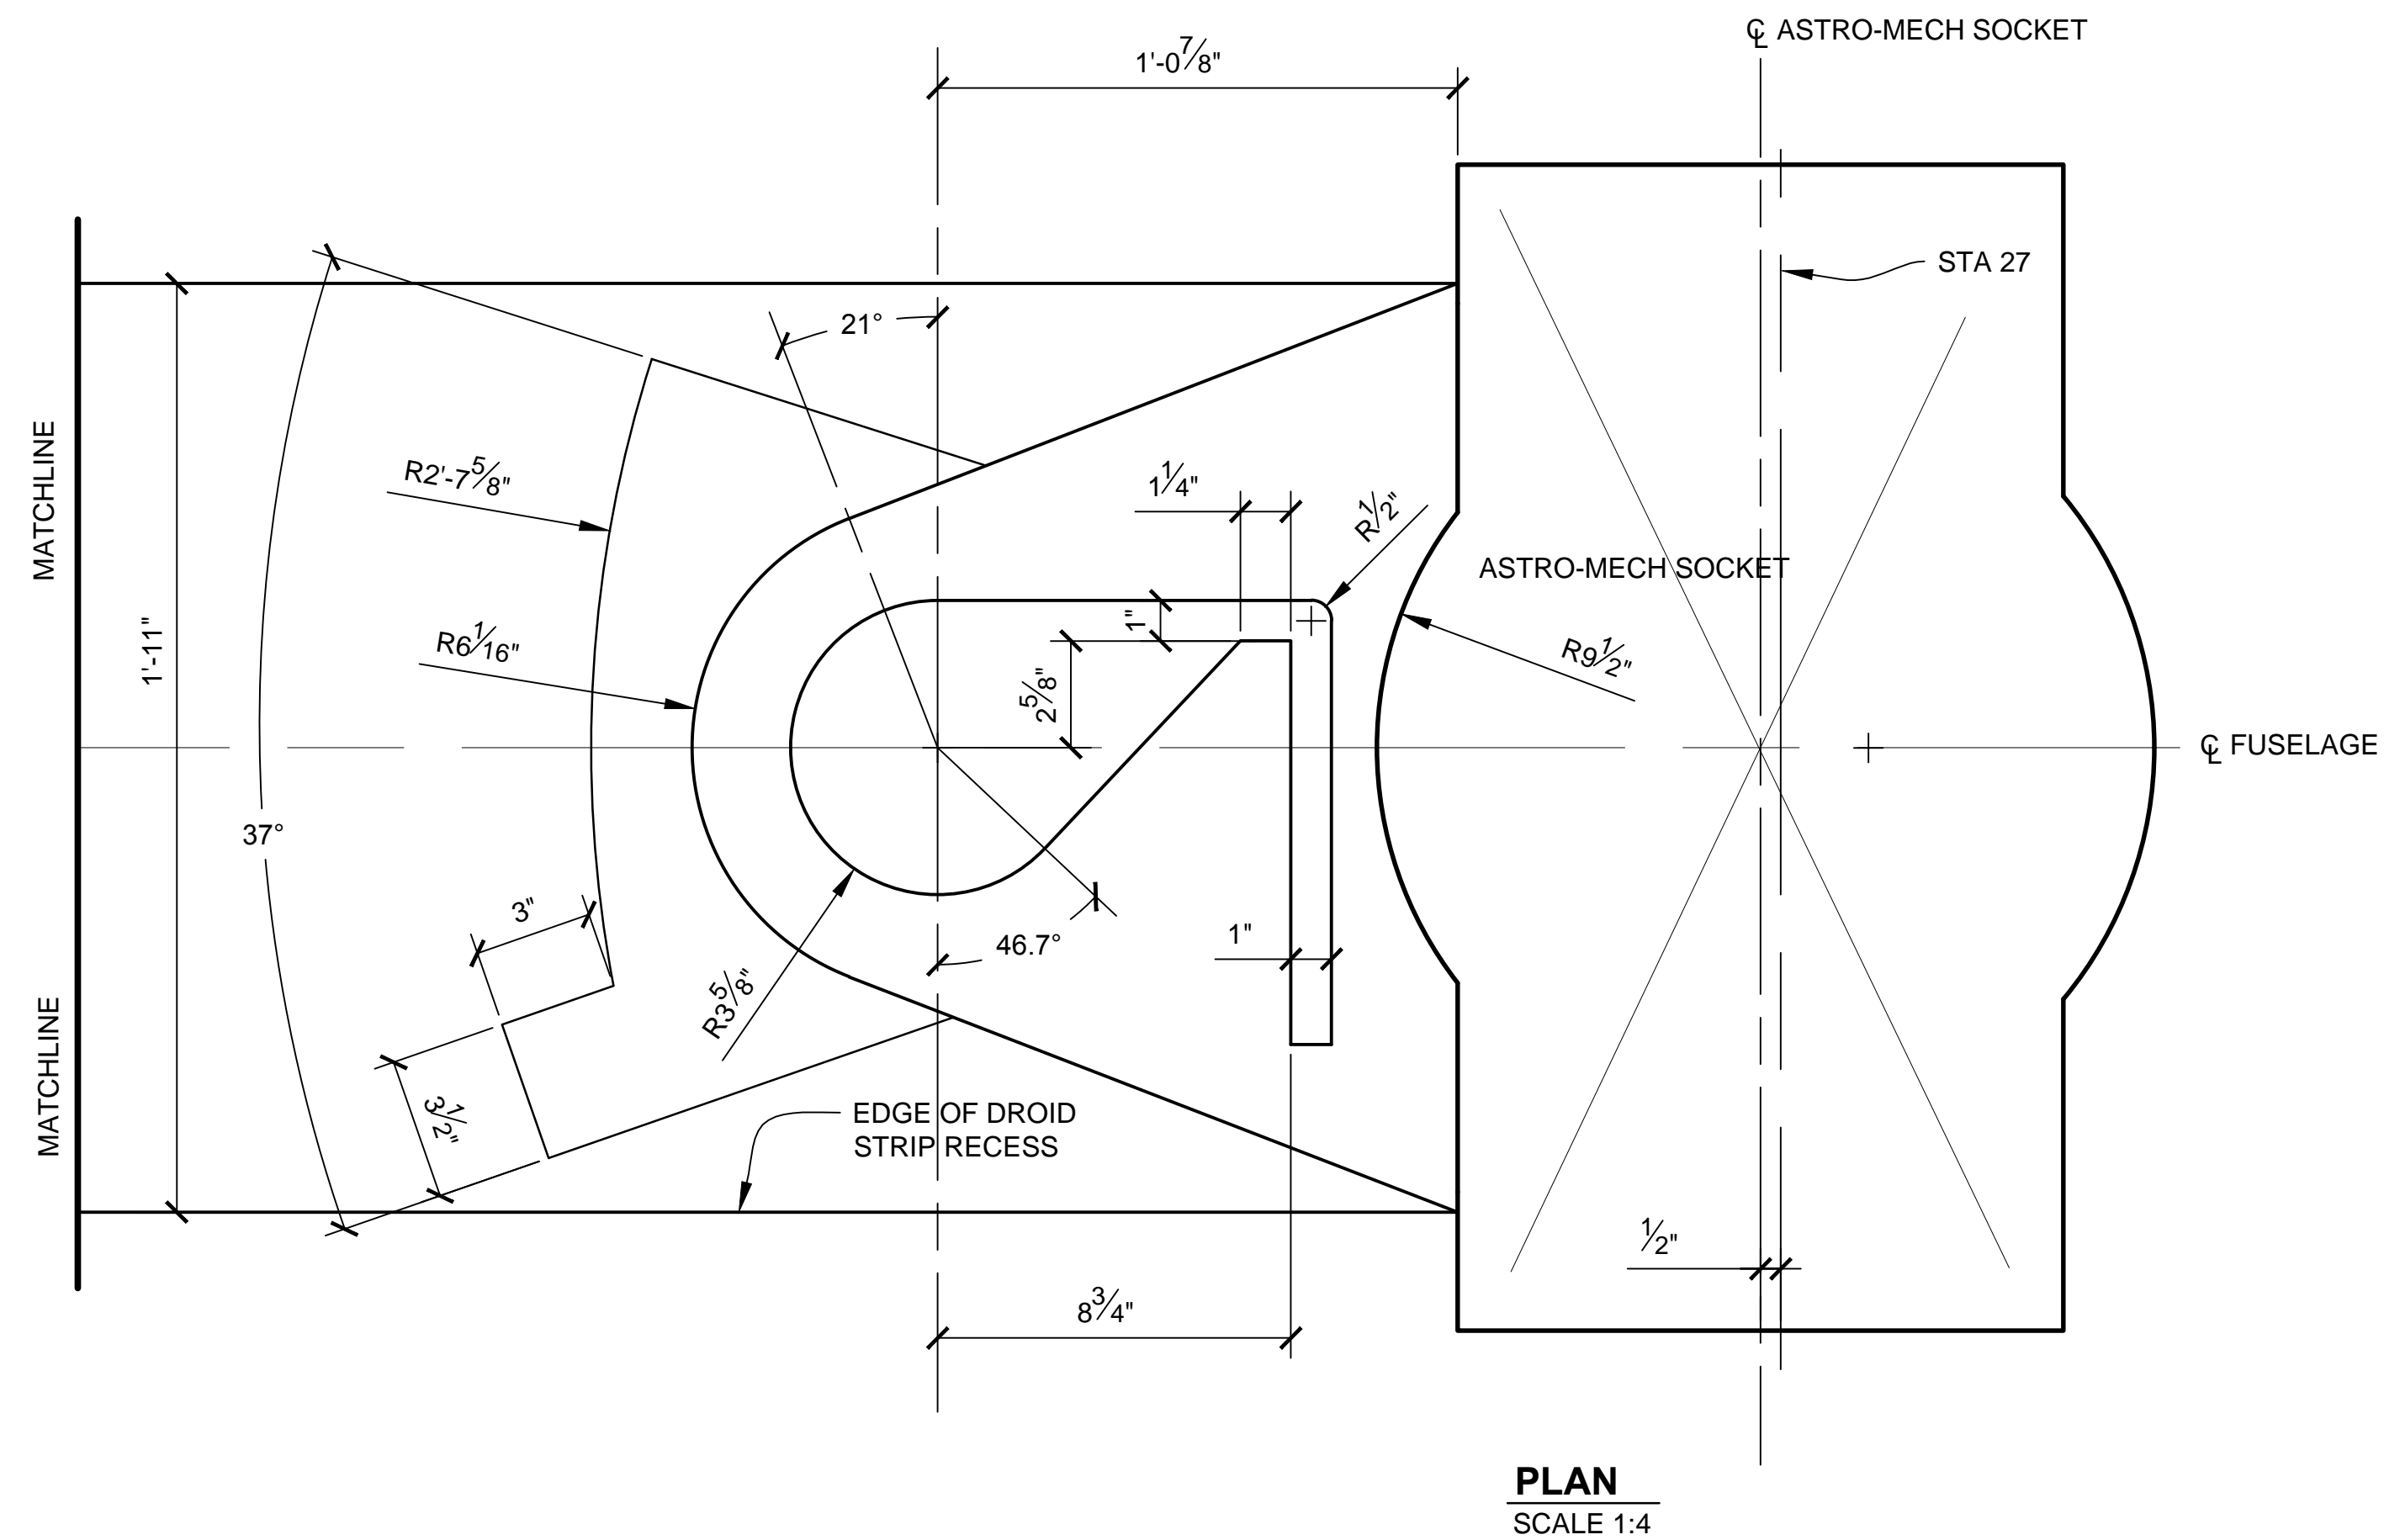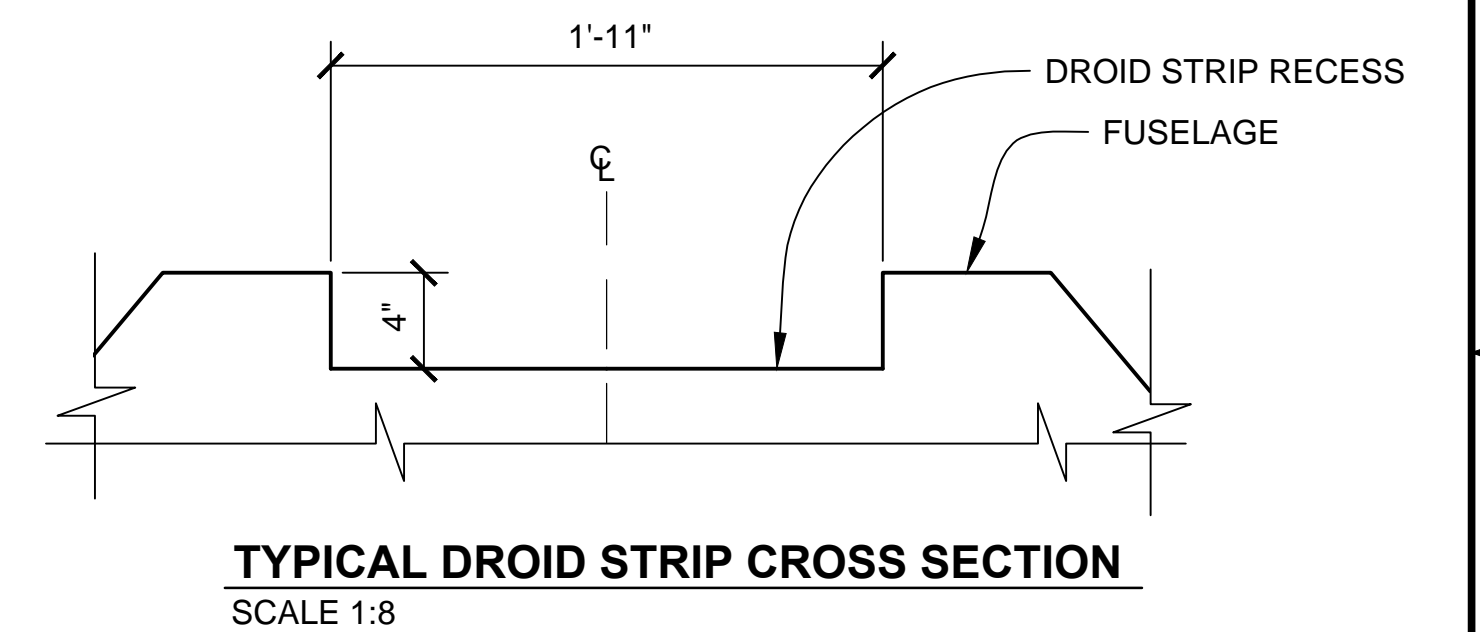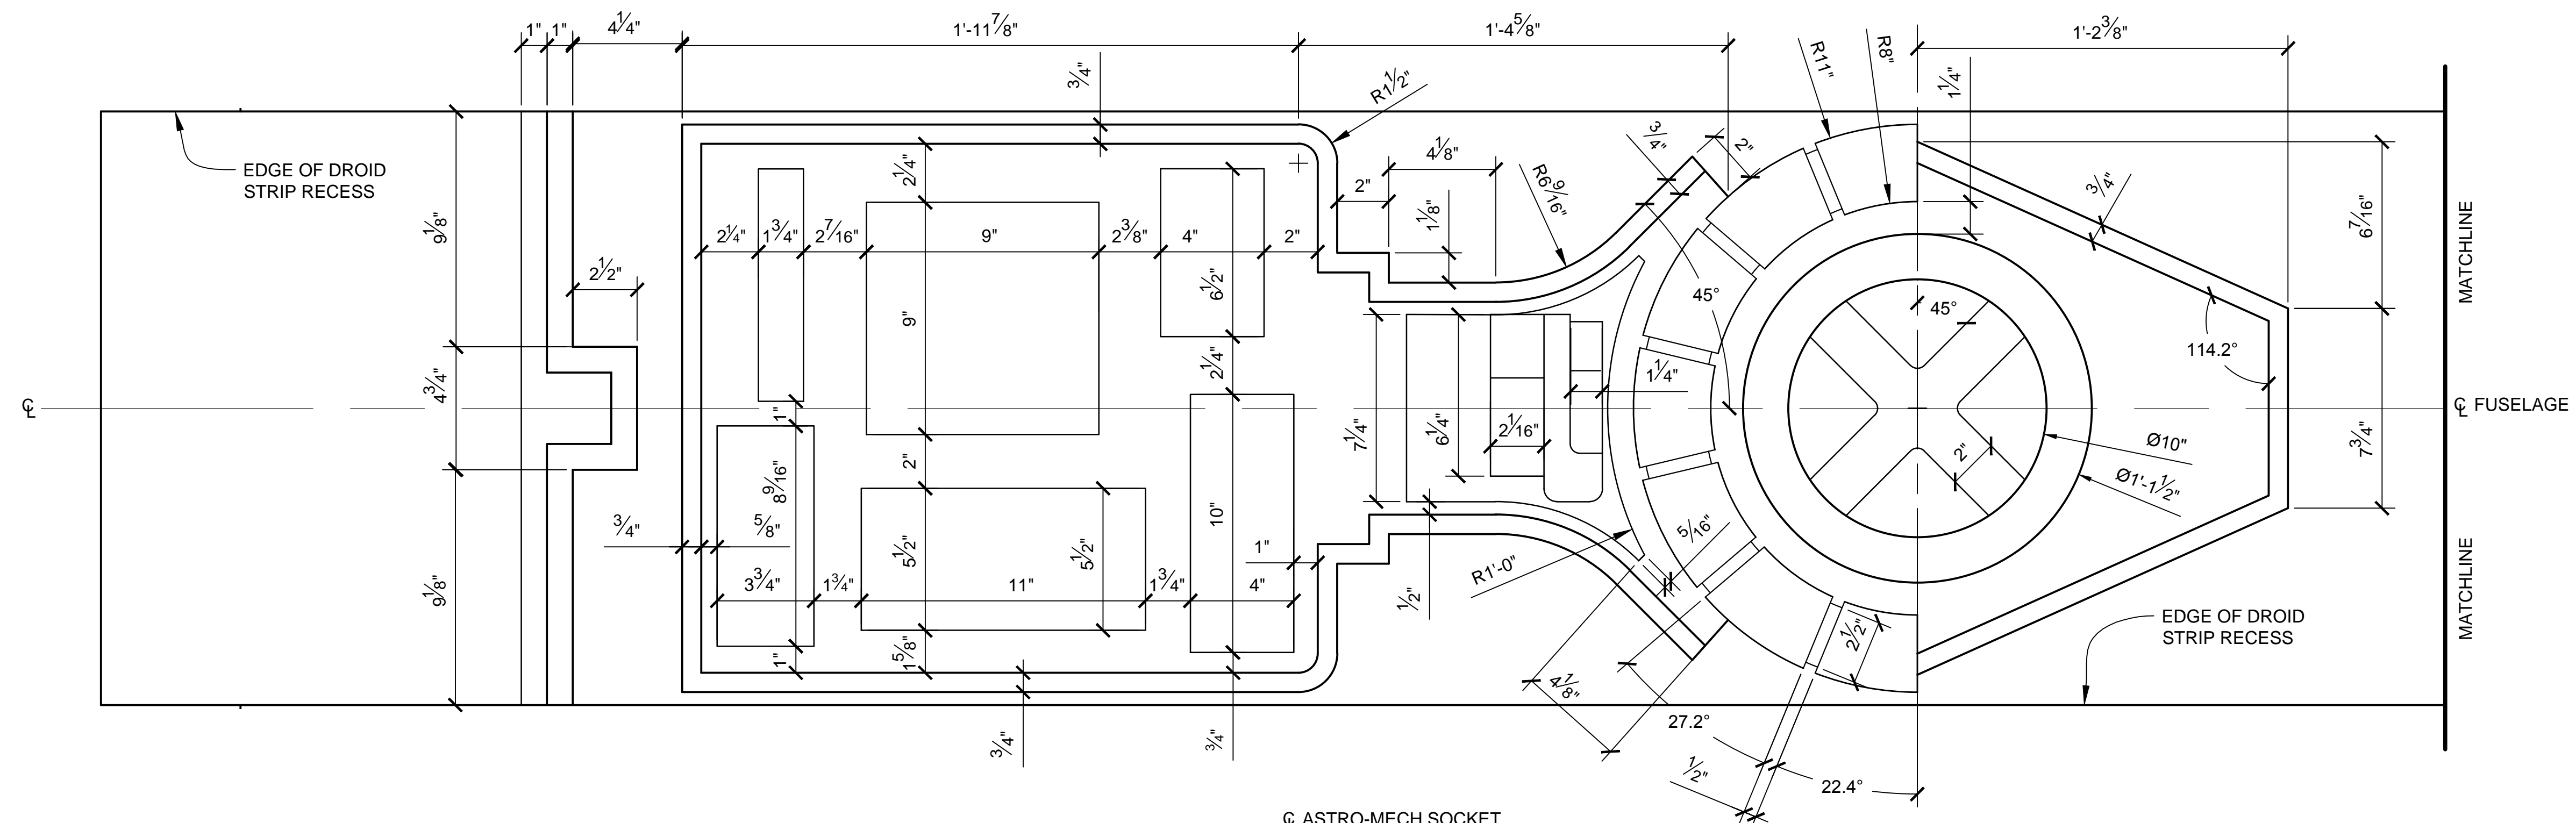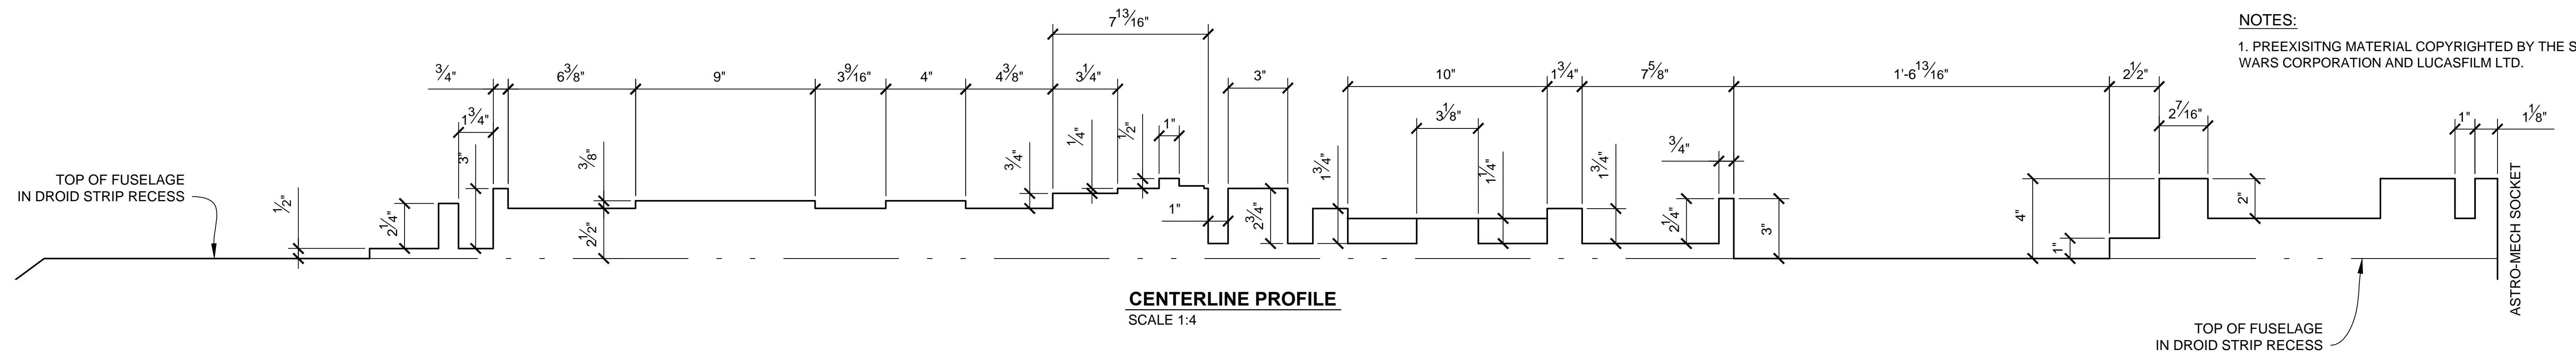


PRODUCTION	D.O.P.	ART DIRECTOR	CAMERA
ART DEPT.	SET DESIGNER	SCULPTOR	GRAPHICS
SET DEC.	DRAPES	PROPS	MODEL SHOP
CONST. COORD.	CARPENTER	PLASTER	PAINT
GREENS	SCENIC	METALS	SFX
GRIP	ELECTRICAL	VFX	CGI


PROJECT		<h1>THE X-WING BUILD</h1> <h2>1:1 SCALE STAGE PROP</h2>	
SET		SET NO.	
TITLE		REV	
FUSELAGE DETAILS		--	
EMPIRE STRIKES BACK DROID STRIP			
PROD DESIGNER		DATE DRAWN 4/NOV/2012	
DRAWN BY B.J.S.		DATE ISSUED DD/MMM/YYYY	
STAGE		LOCATION	
DWG NO.		2.10	
FILE		SHEET	
X-WING LINES MASTER.DWG		12 OF XX	

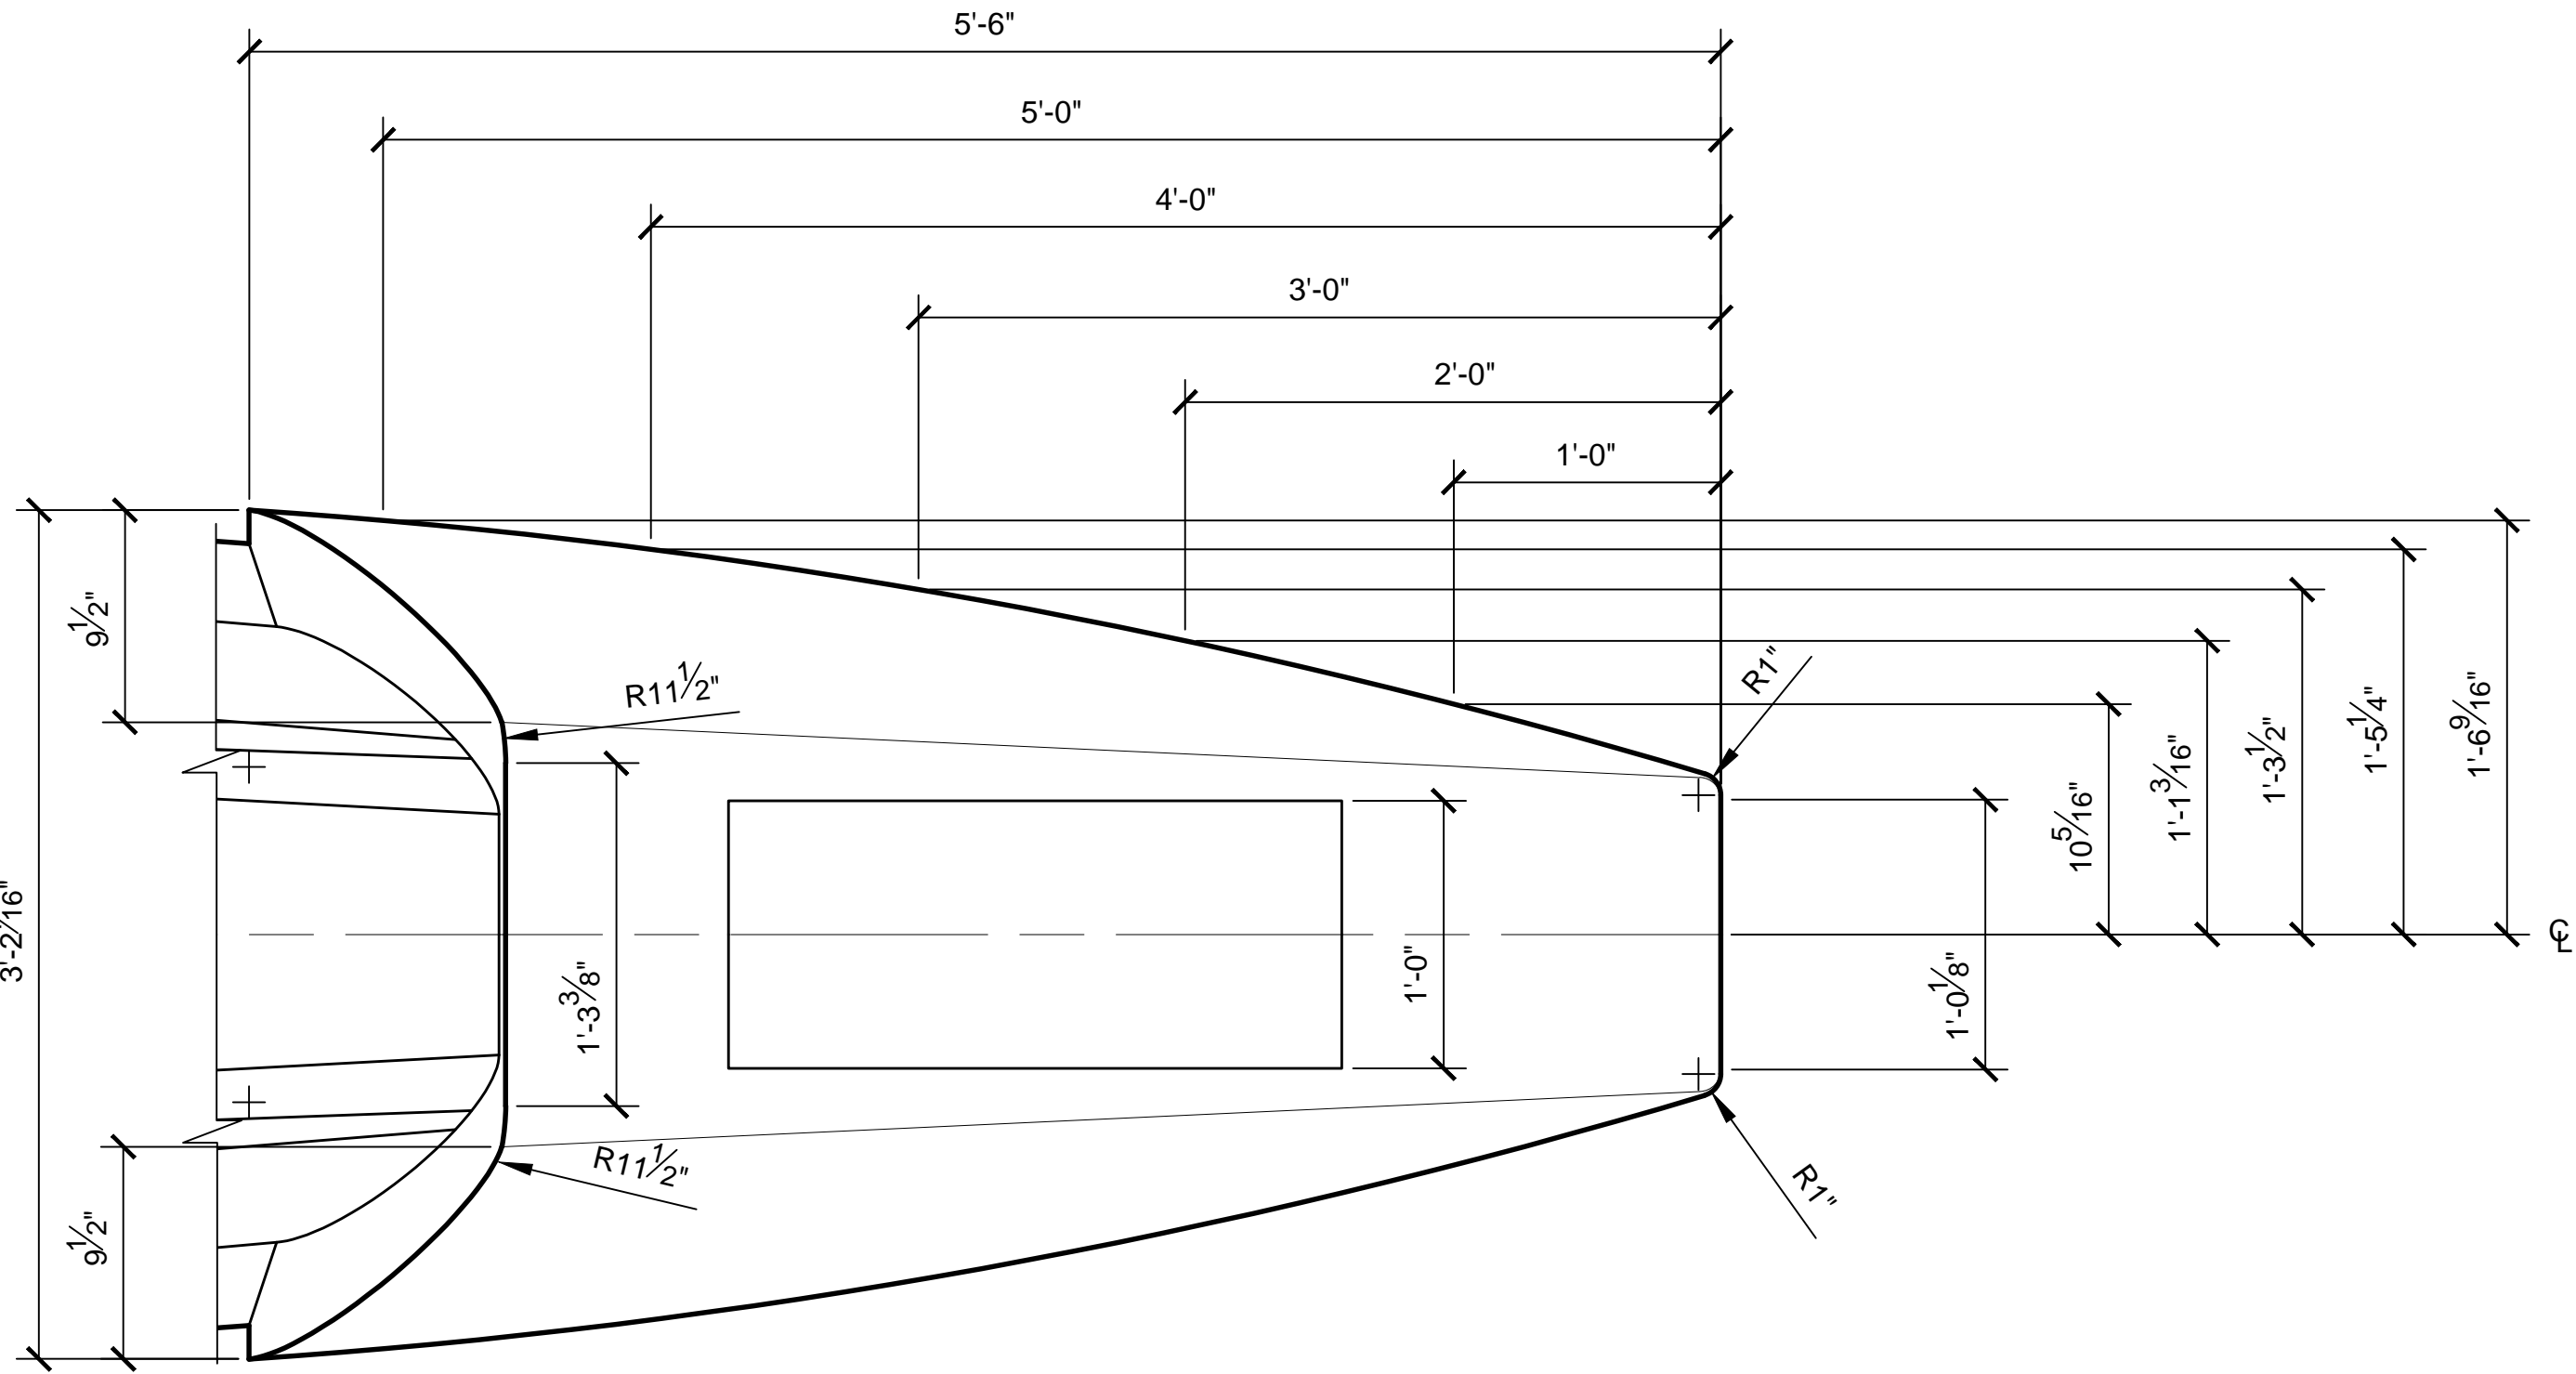


TOP VIEW
SCALE 1:8

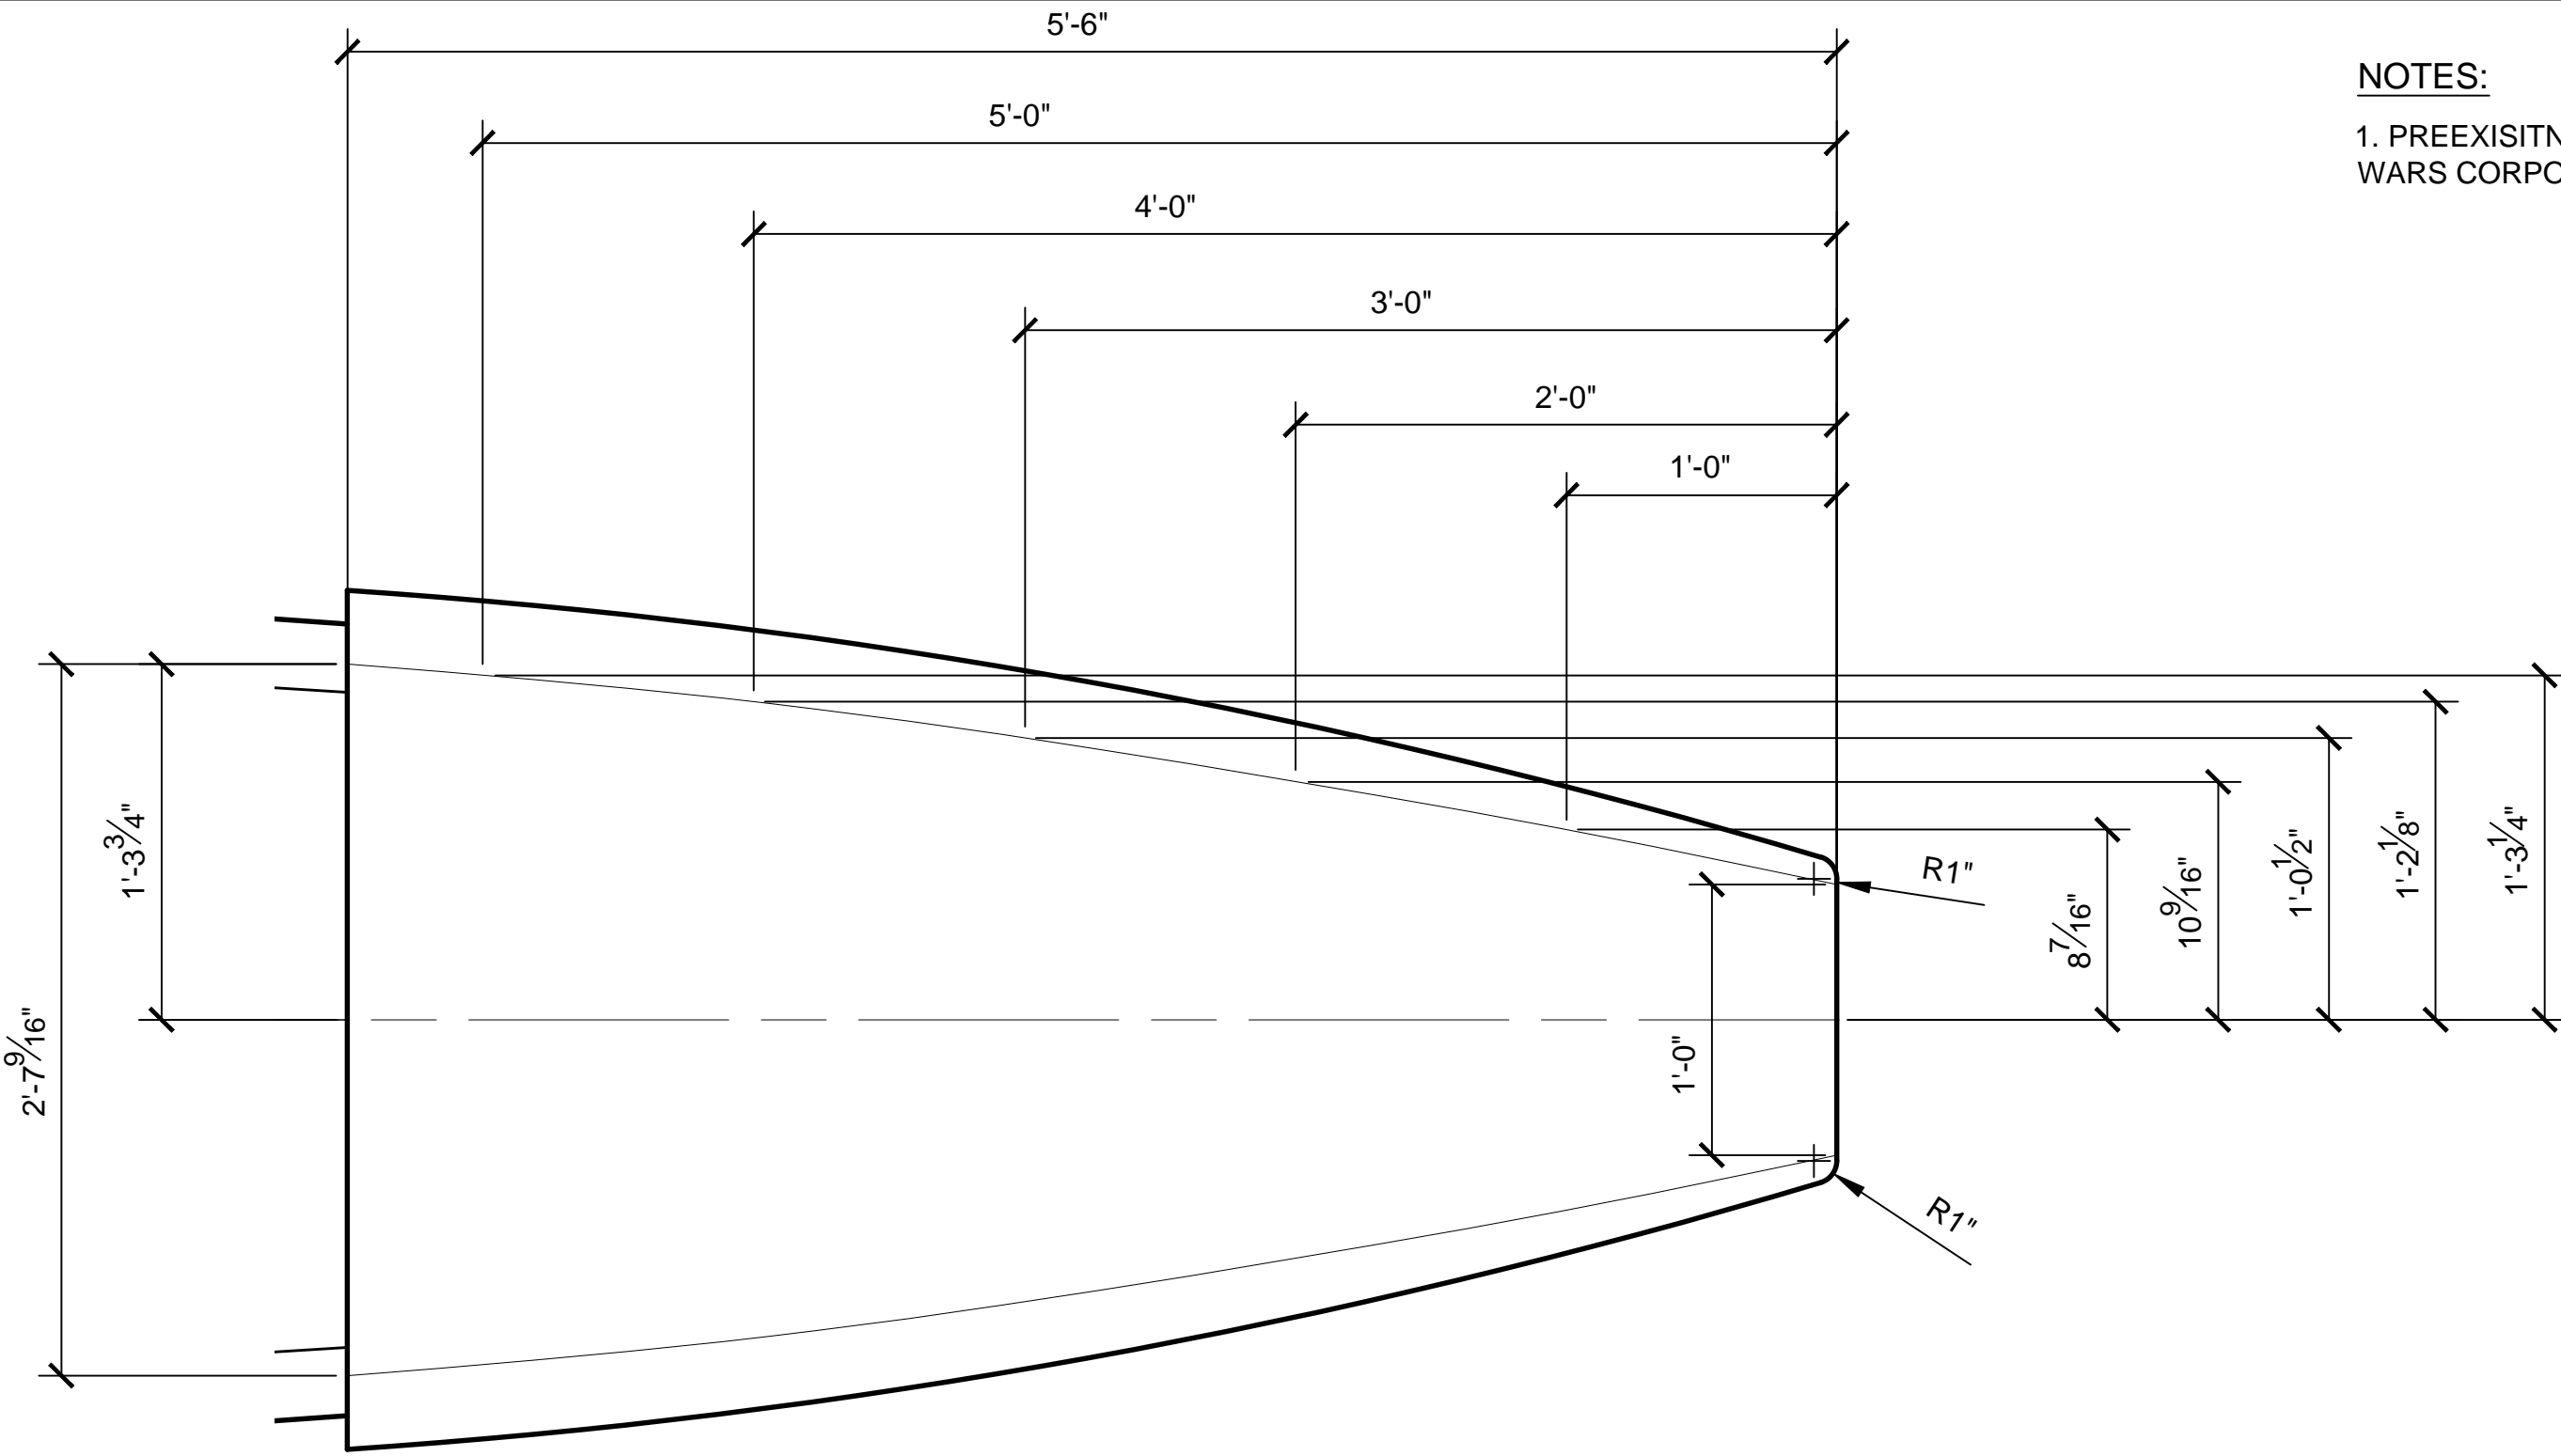

BOTTOM VIEW
SCALE 1:8

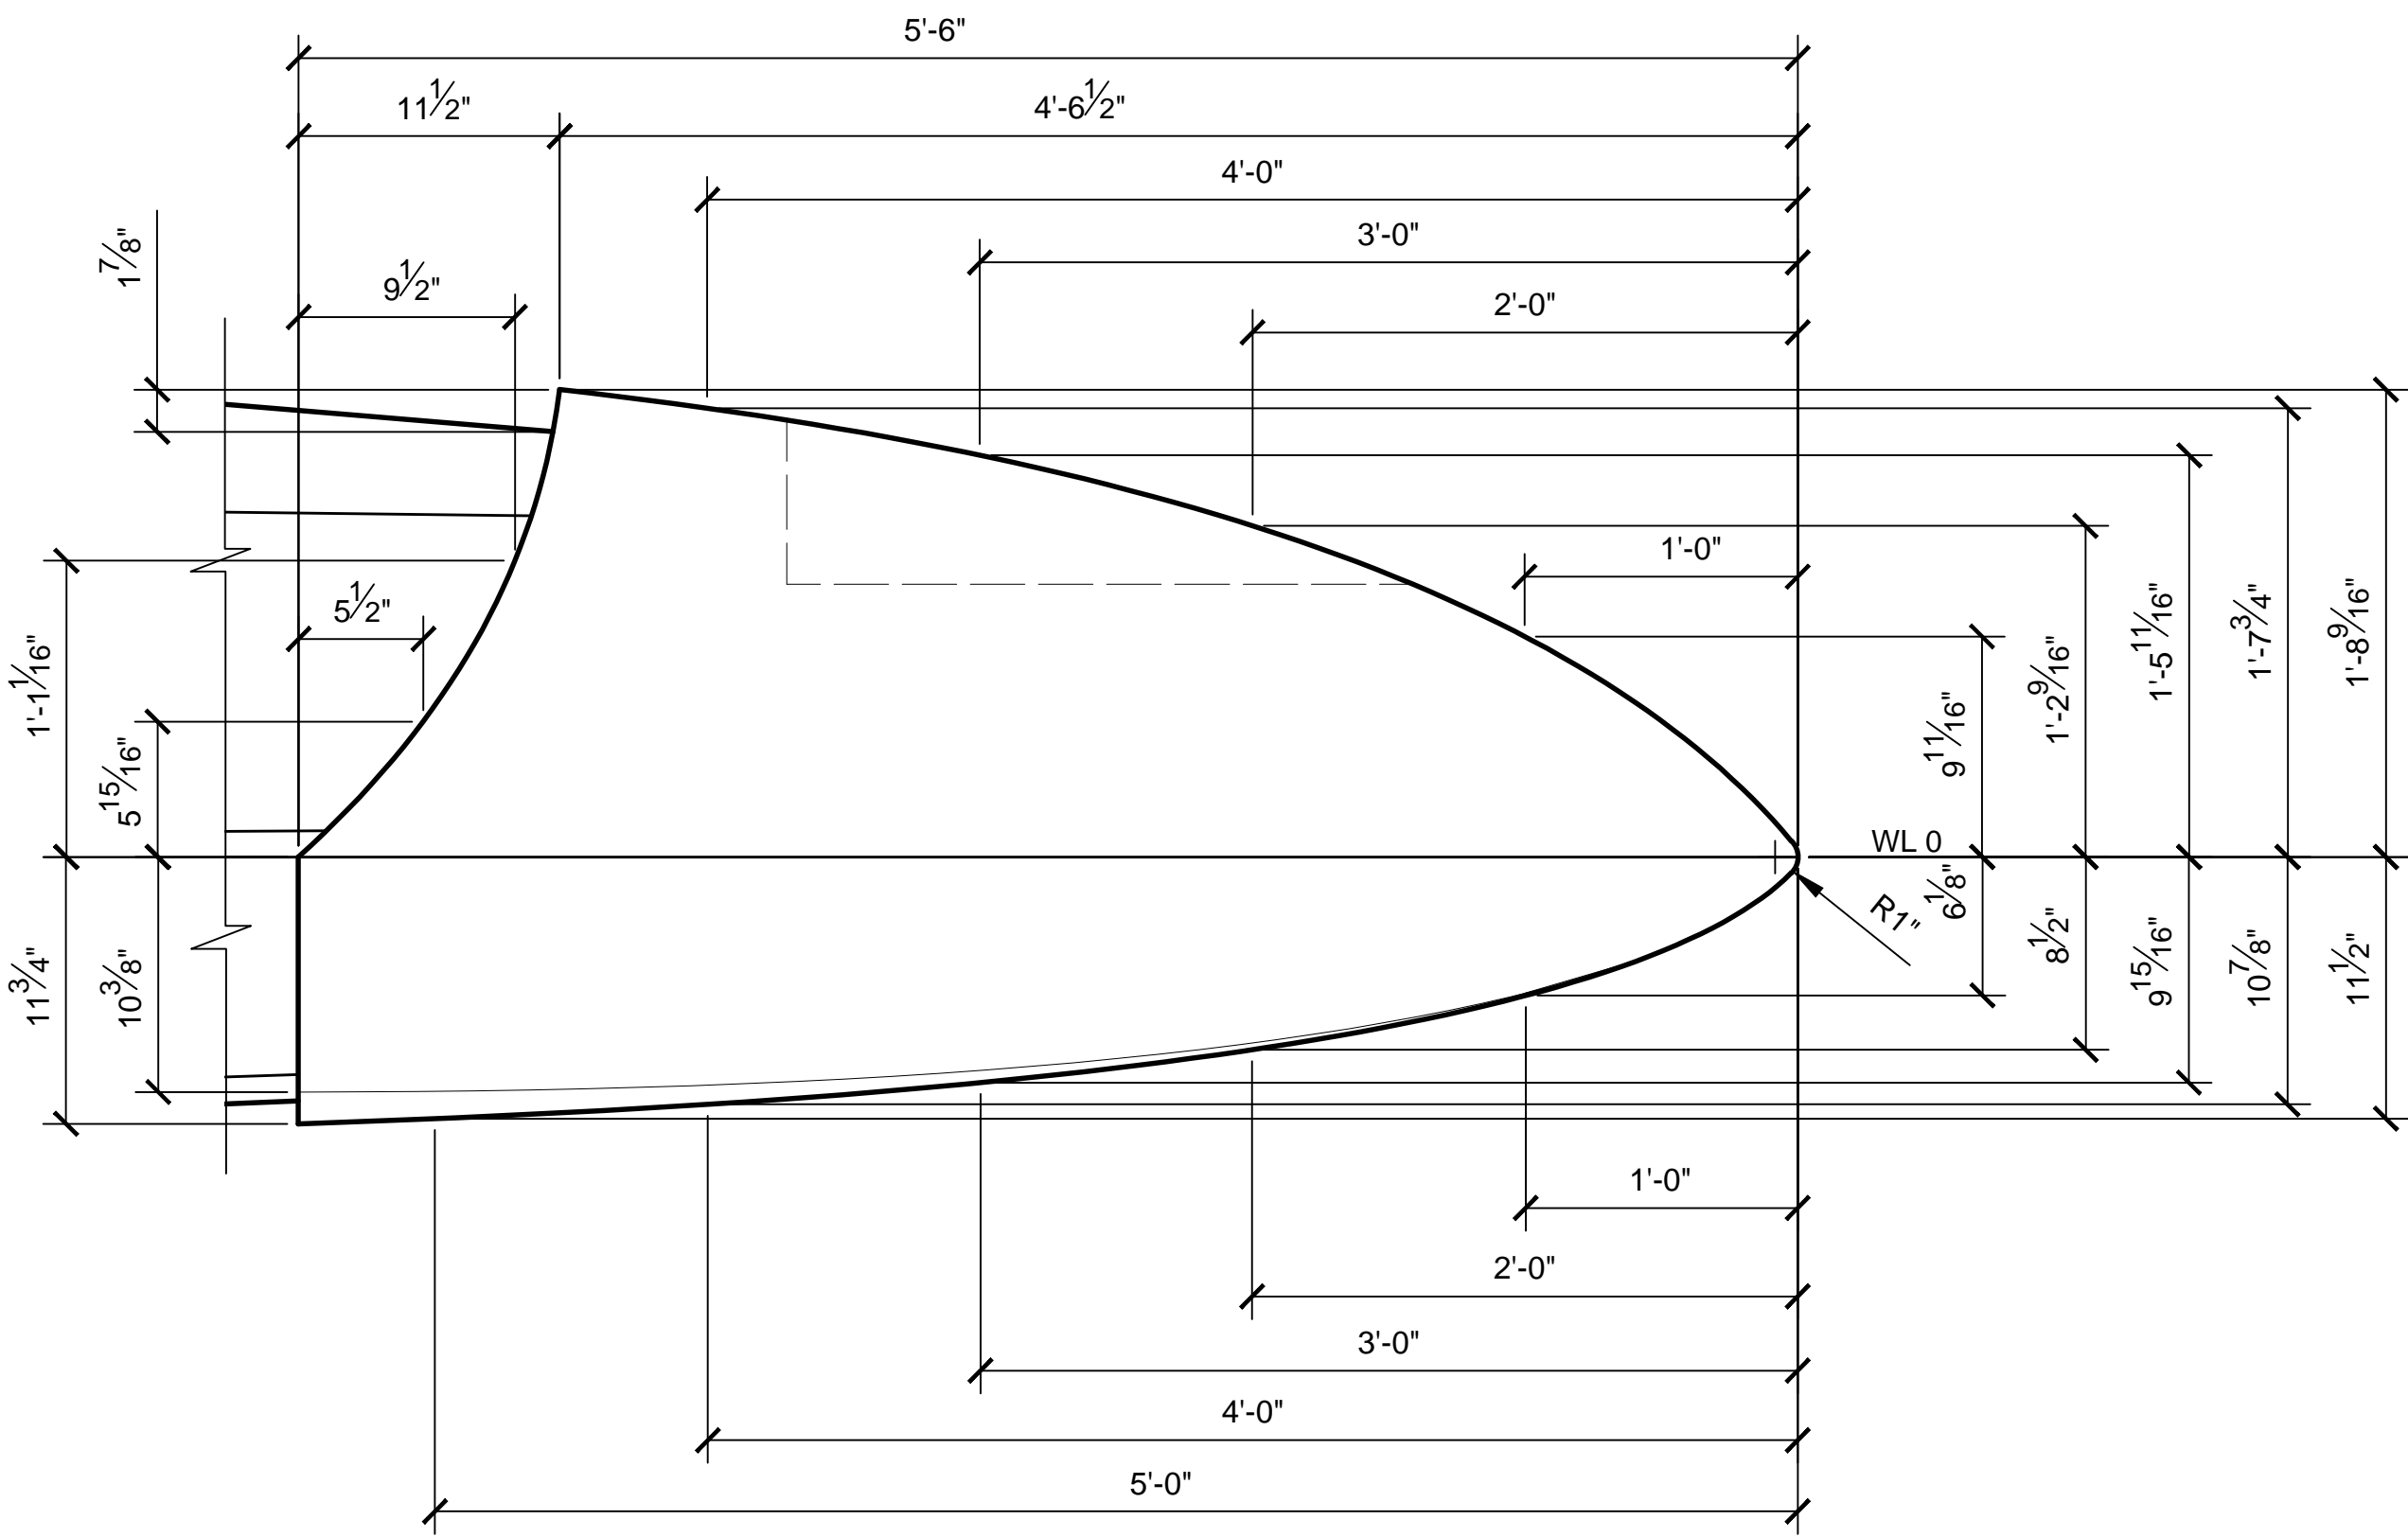

SIDE VIEW
SCALE 1:8

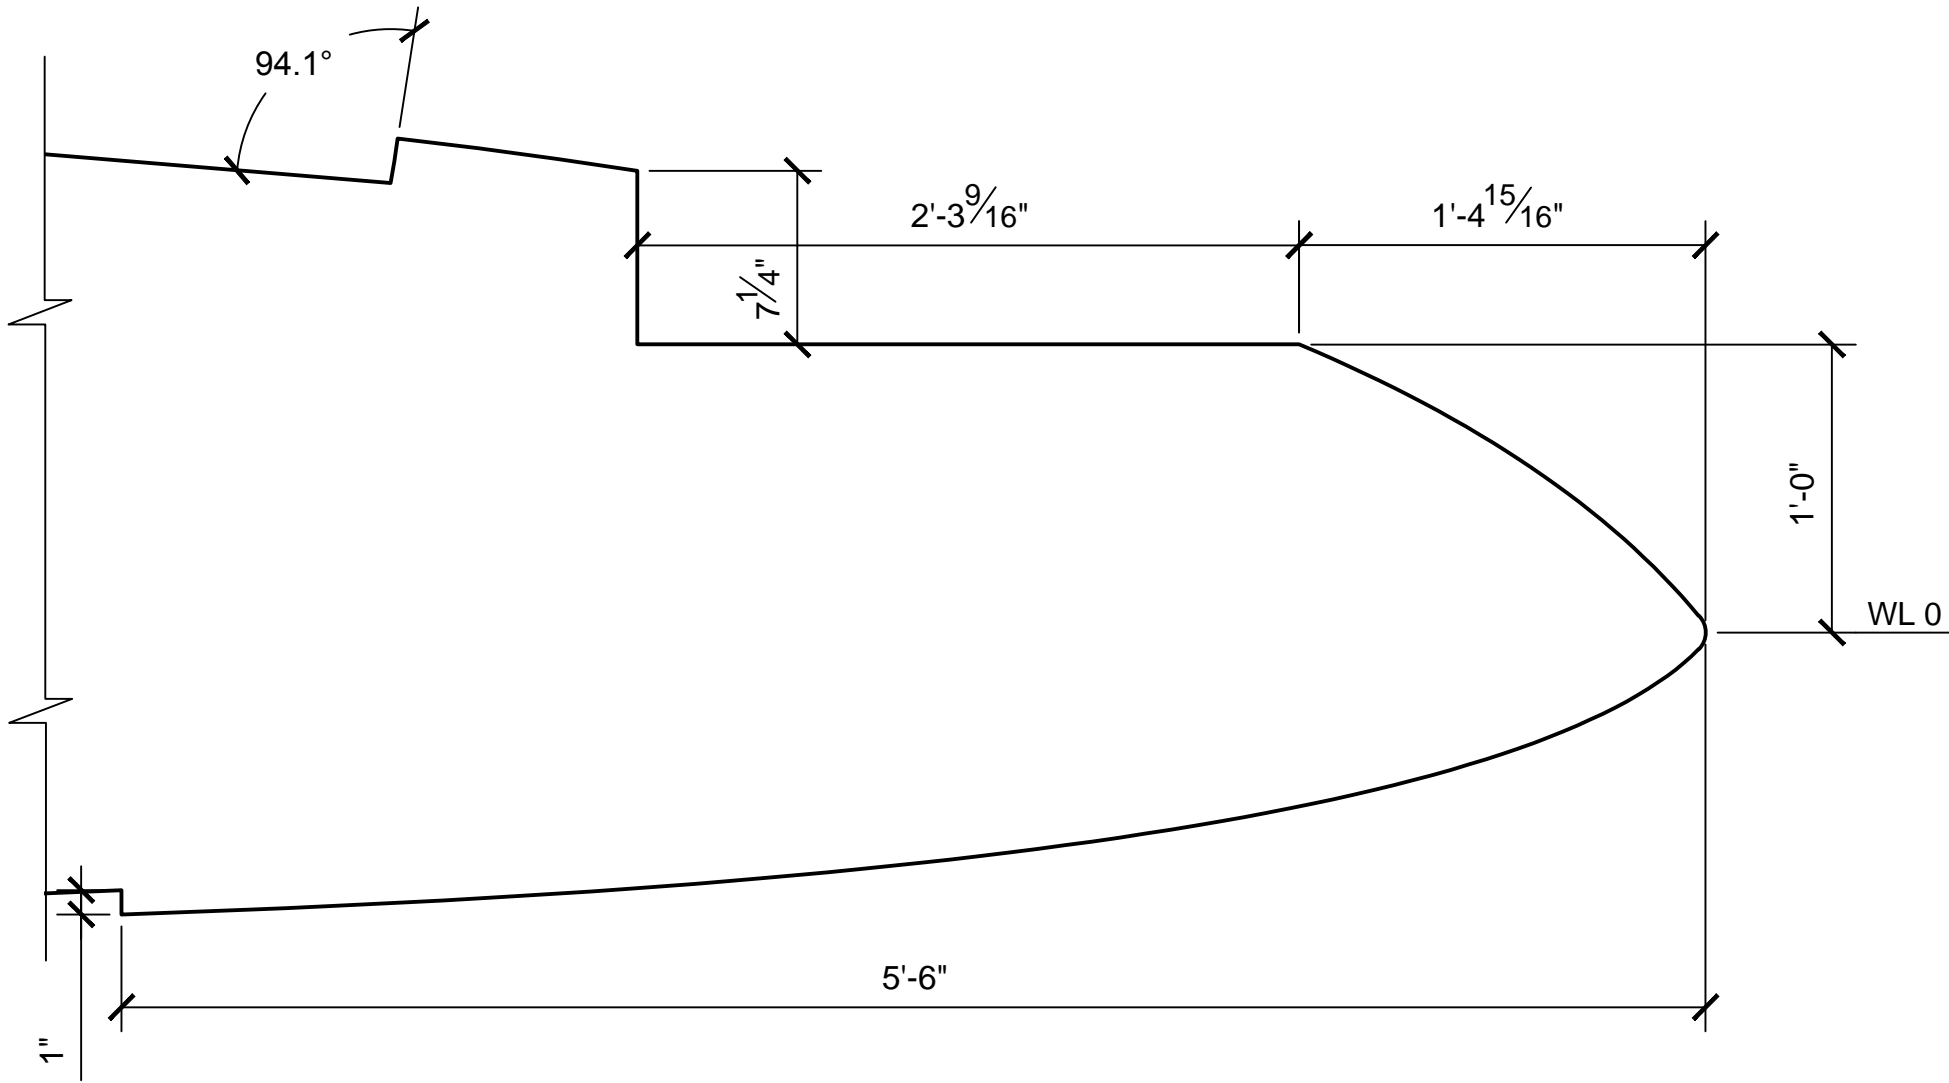





CENTERLINE PROFILE
SCALE 1:8

NOTES:
1. PREEXISITING MATERIAL COPYRIGHTED BY THE STAR WARS CORPORATION AND LUCASFILM LTD.




PRODUCTION	D.O.P.	ART DIRECTOR	CAMERA	
ART DEPT.	SET DESIGNER	SCULPTOR	GRAPHICS	
SET DEC.	DRAPES	PROPS	MODEL SHOP	
CONST. COORD.	CARPENTER	PLASTER	PAINT	
GREENS	SCENIC	METALS	SFX	
GRIP	ELECTRICAL	VFX	CGI	

PROJECT				
THE X-WING BUILD				
1:1 SCALE STAGE PROP				
SET				SET NO.
TITLE	FUSELAGE DETAILS NOSE CONE			REV --
PROD DESIGNER			DATE DRAWN 3/SEP/2012	
DRAWN BY B.J.S.		APPROVED BY		DATE ISSUED DD/MM/YYYY
STAGE		LOCATION		DWG NO.
FILE X-WING LINES_MASTER.DWG		SHEET 13 OF XX		2.11

 

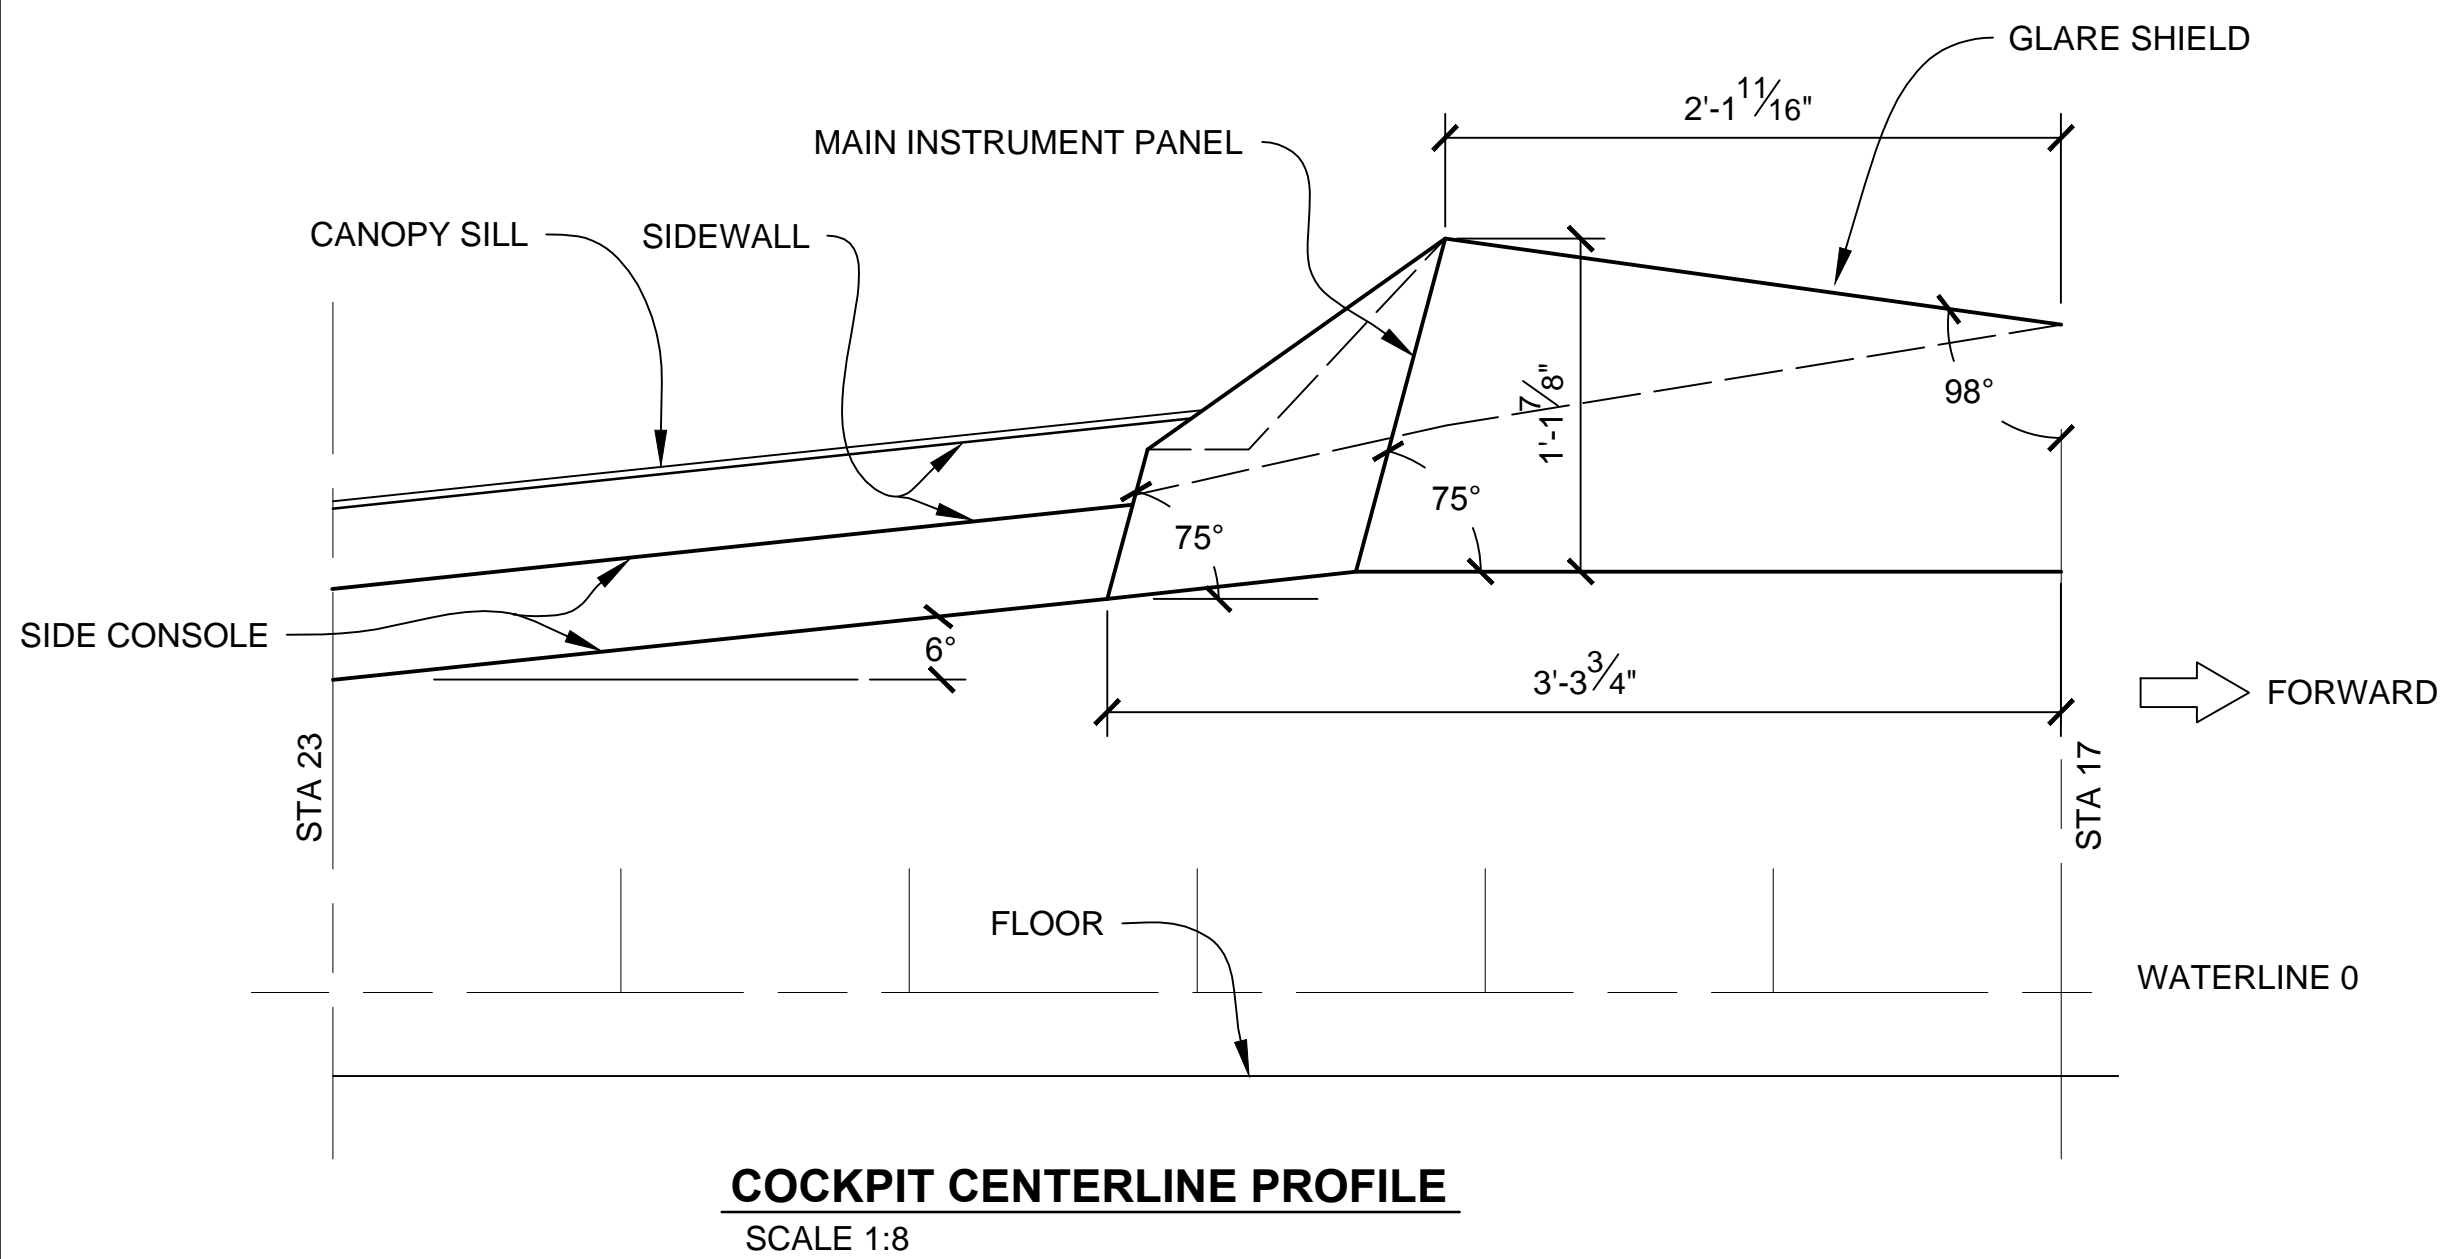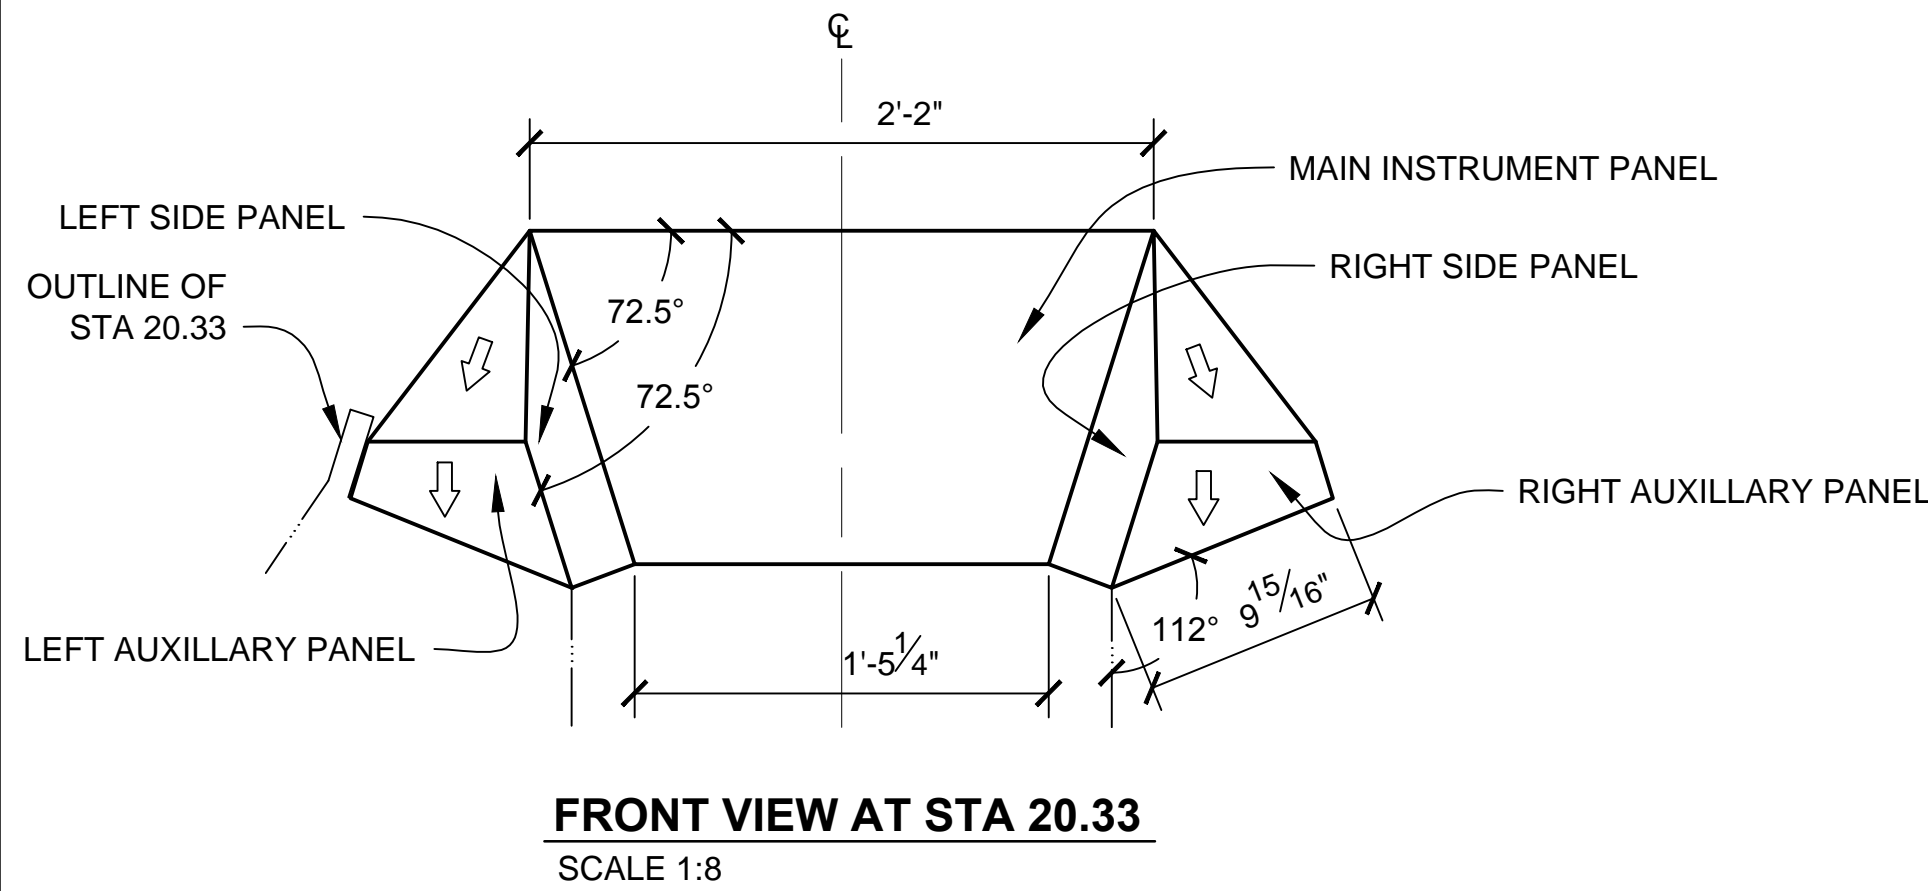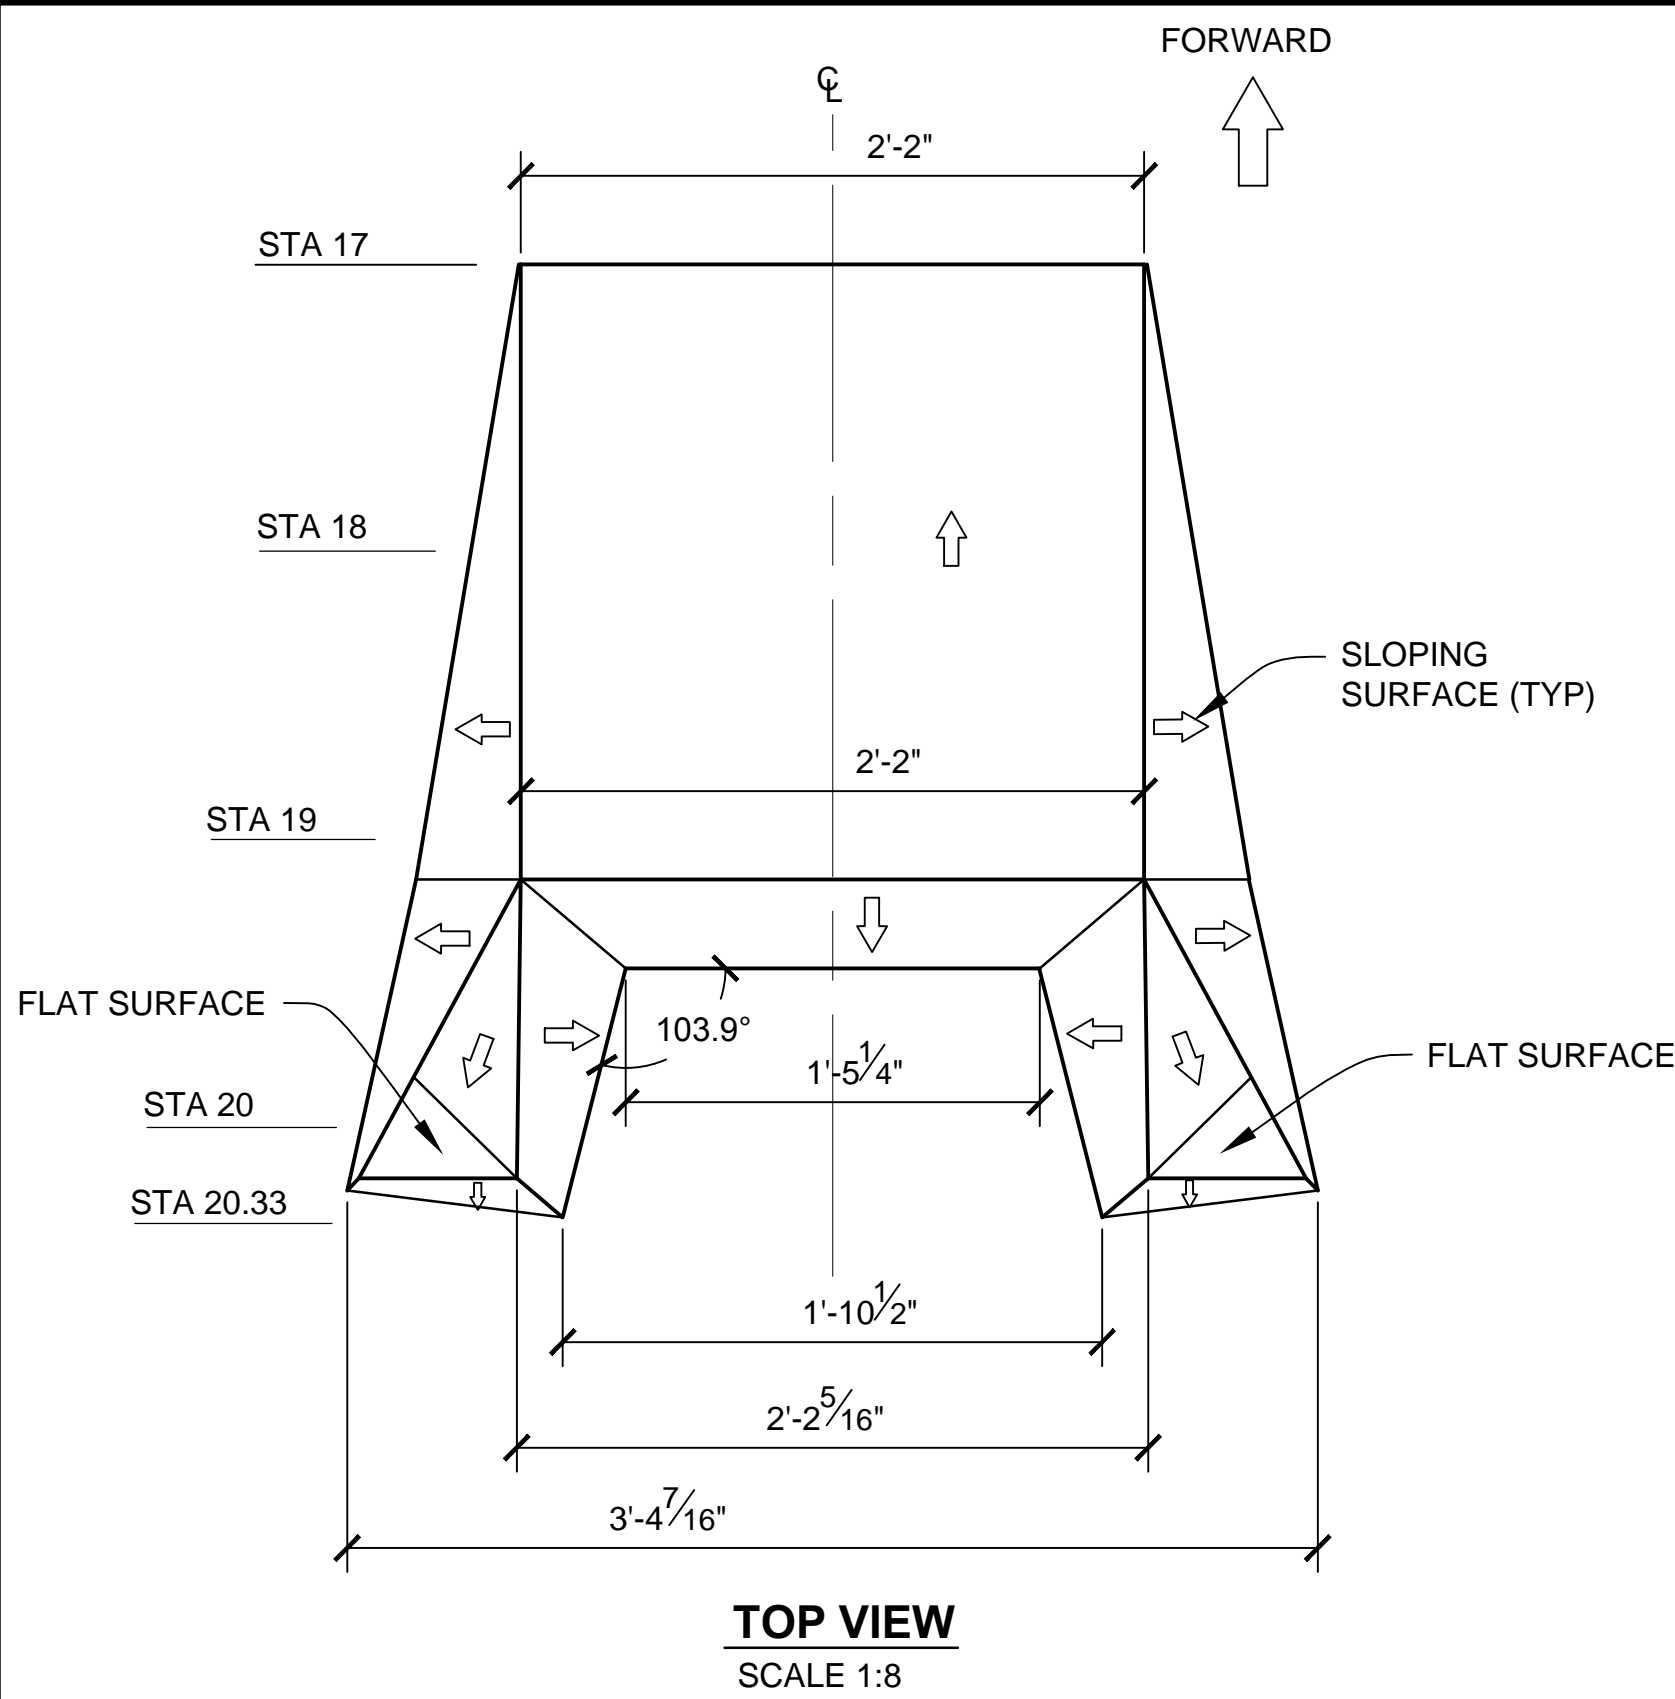

EMPIRE STRIKES BACK PANEL

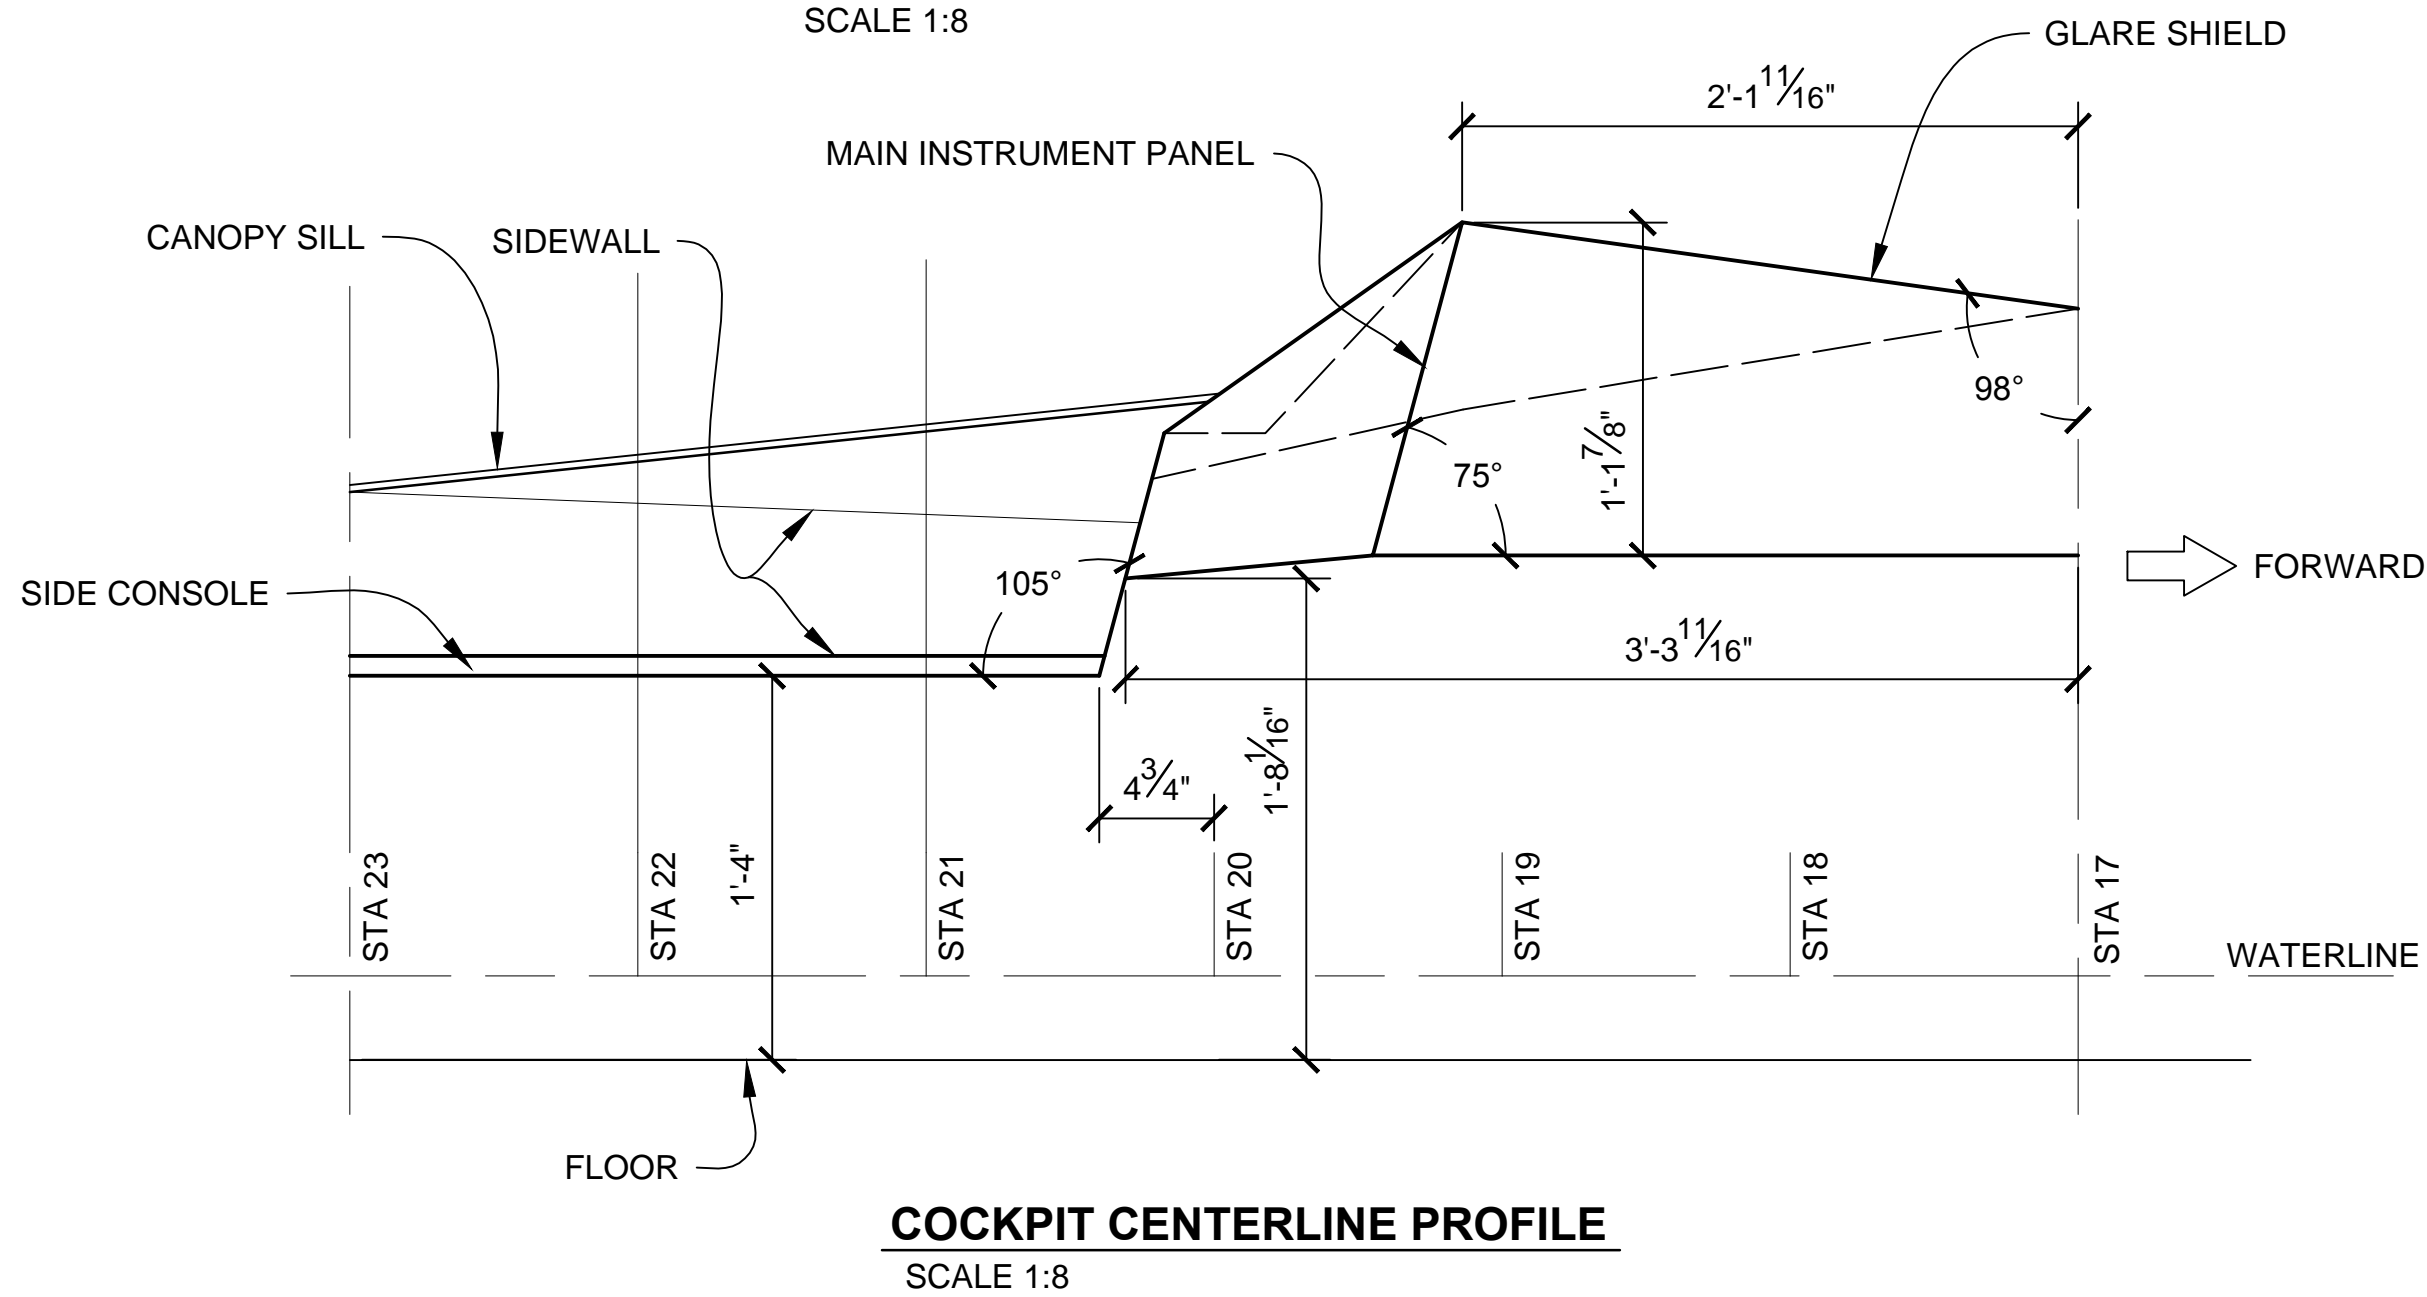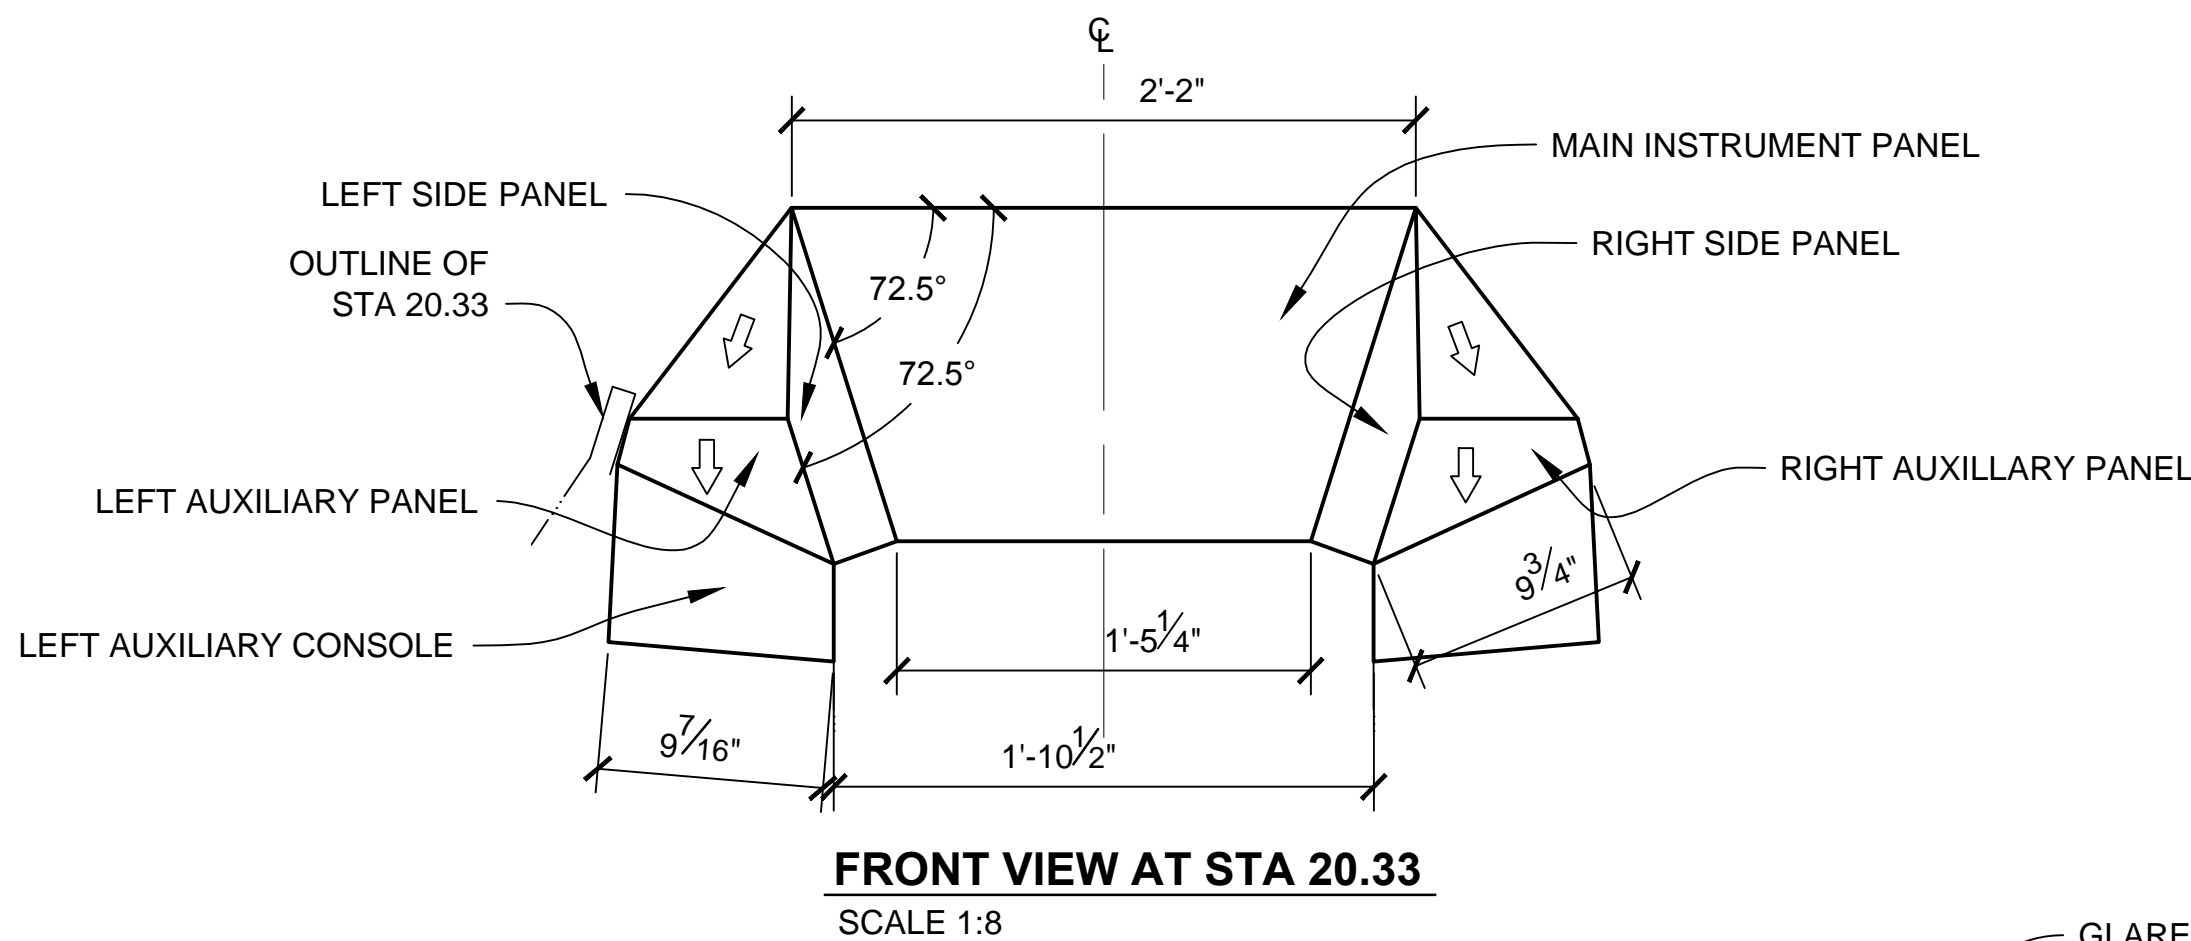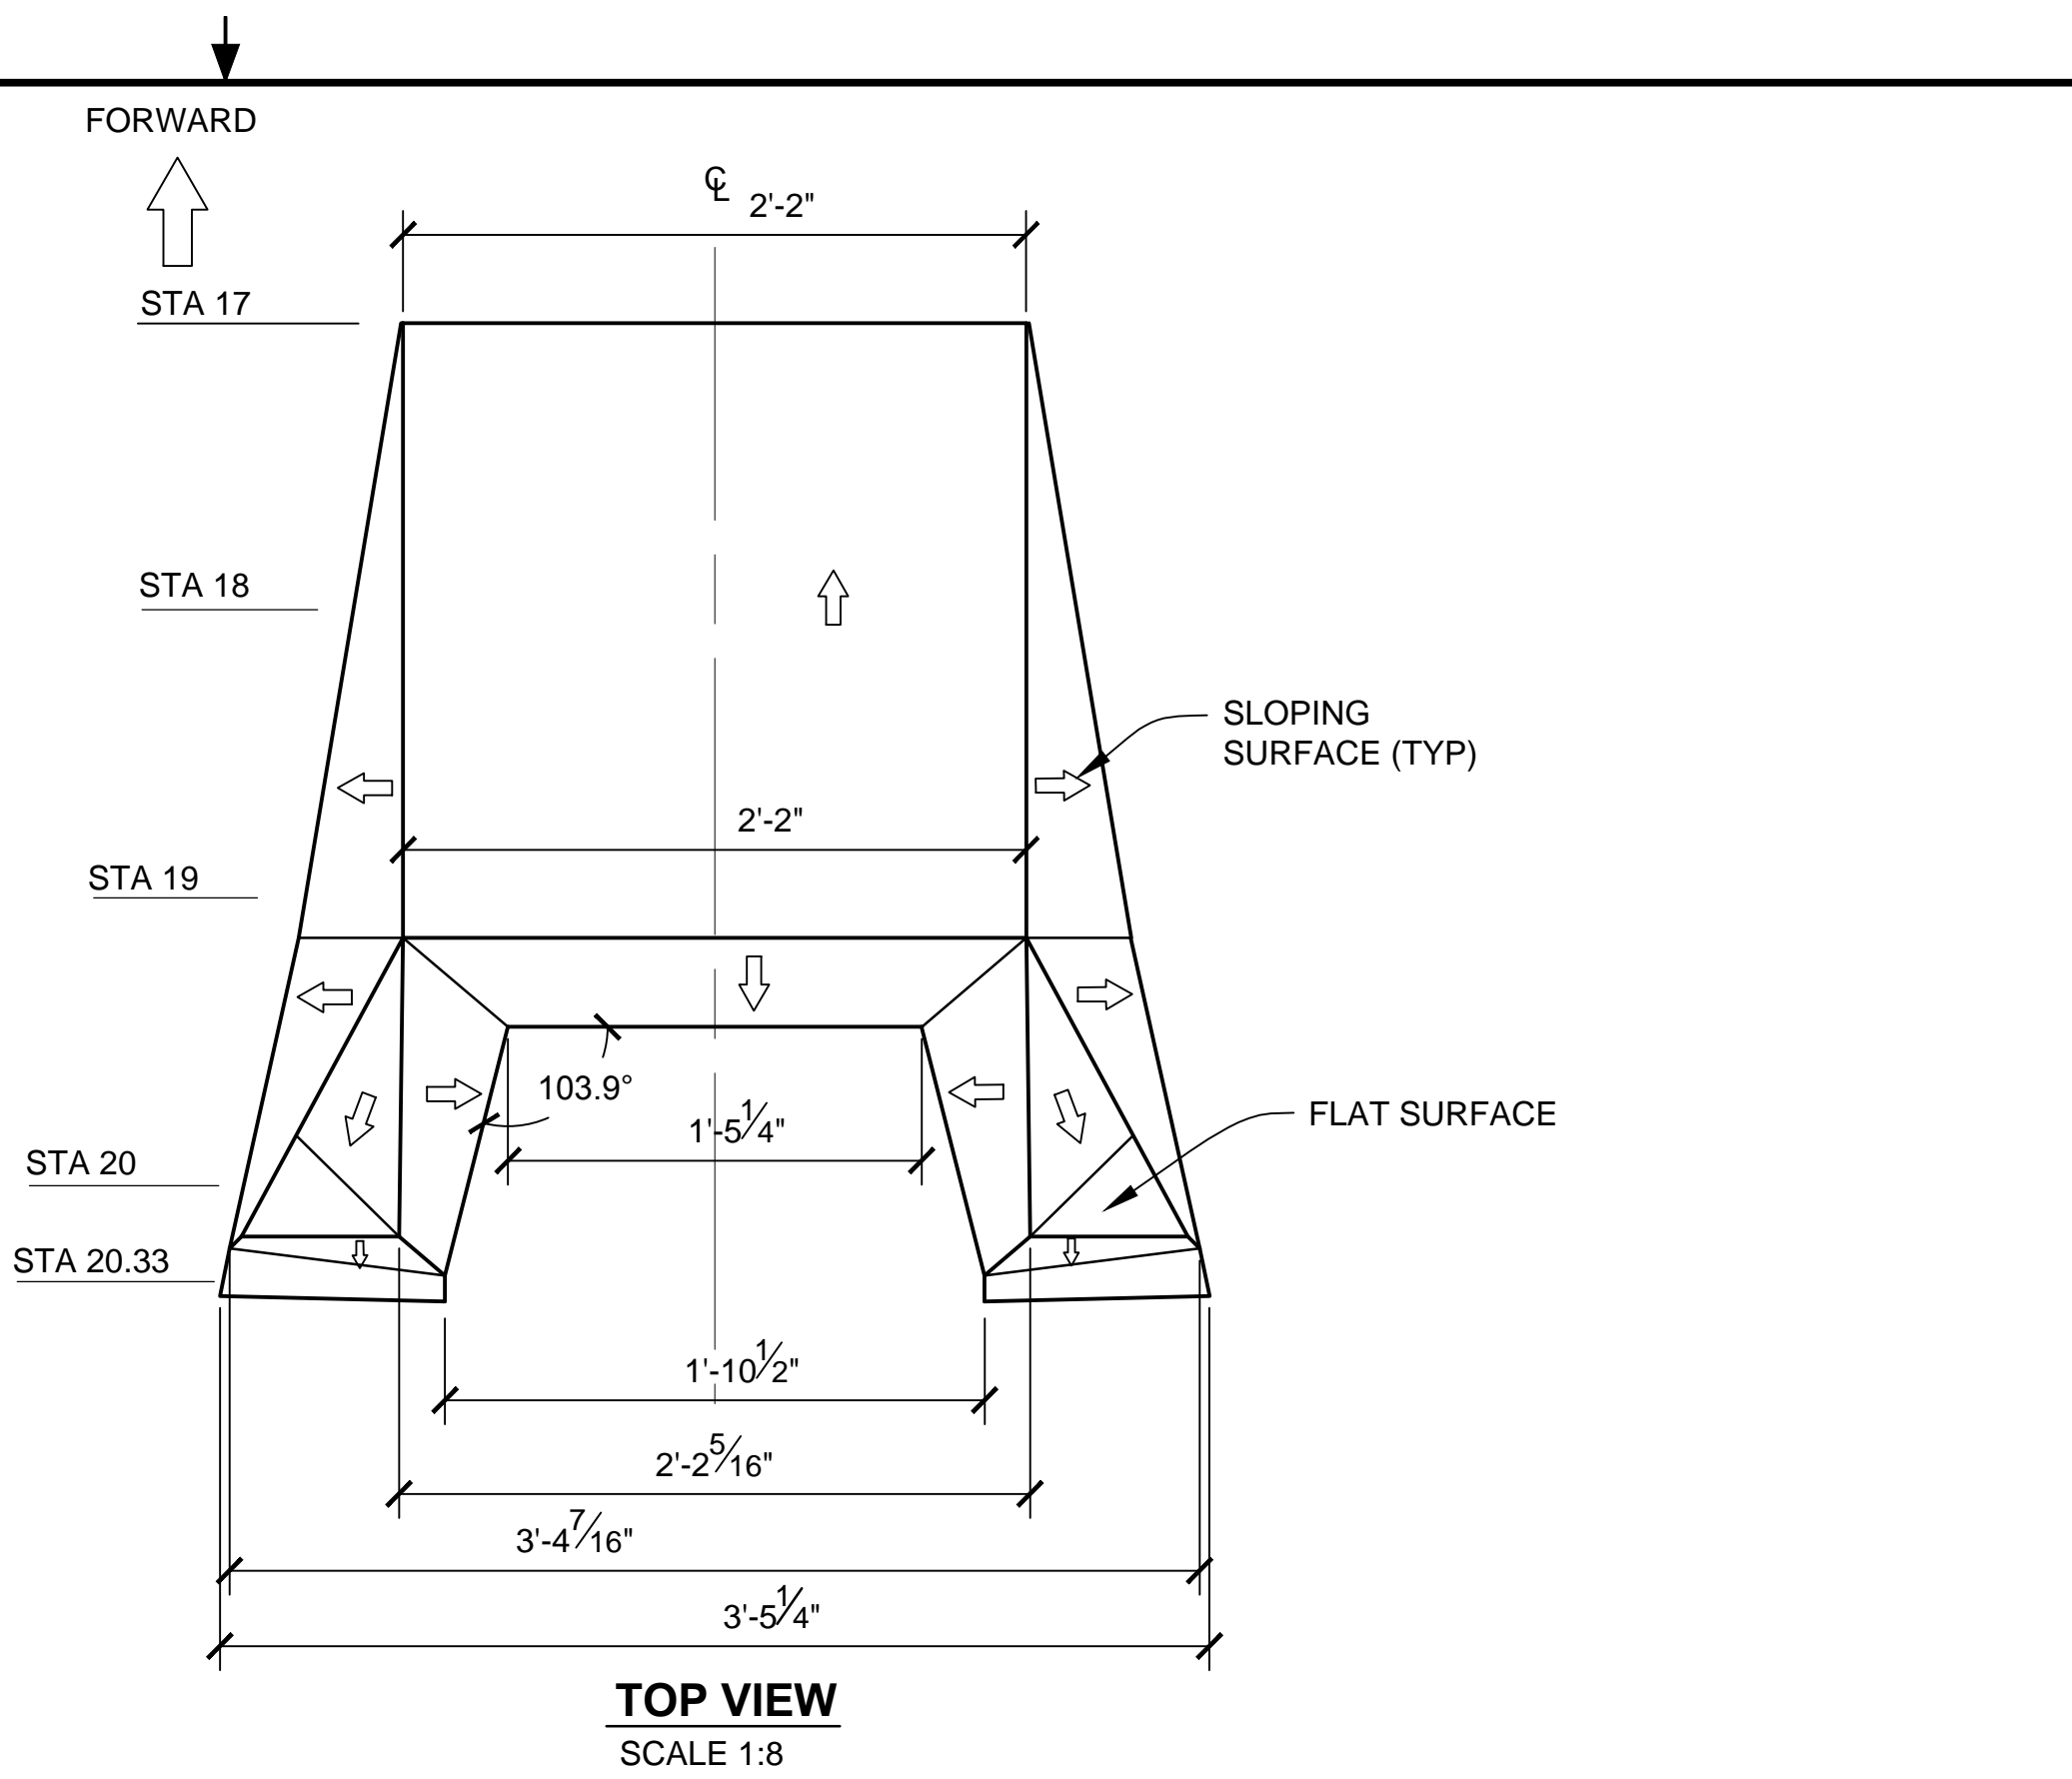

A NEW HOPE PANEL


NOTES:


1. PREEXISTING MATERIAL COPYRIGHTED BY THE STAR WARS CORPORATION AND LUCASFILM LTD.

PRODUCTION	D.O.P.	ART DIRECTOR	CAMERA
ART DEPT.	SET DESIGNER	SCULPTOR	GRAPHICS
SET DEC.	DRAPES	PROPS	MODEL SHOP
CONST. COORD.	CARPENTER	PLASTER	PAINT
GREENS	SCENIC	METALS	SFX
GRIP	ELECTRICAL	VFX	CGI


PROJECT			
THE X-WING BUILD			
1:1 SCALE STAGE PROP			
SET	SET NO.		
TITLE	FUSELAGE DETAILS		REV
PROD DESIGNER		DATE DRAWN	
B.J.S.		14/NOV/2012	
APPROVED BY		DATE ISSUED	
		DD/MM/YYYY	
STAGE	LOCATION	DWG NO.	
FILE X-WING LINES_MASTER.DWG		SHEET 14 OF XX	

 2.12




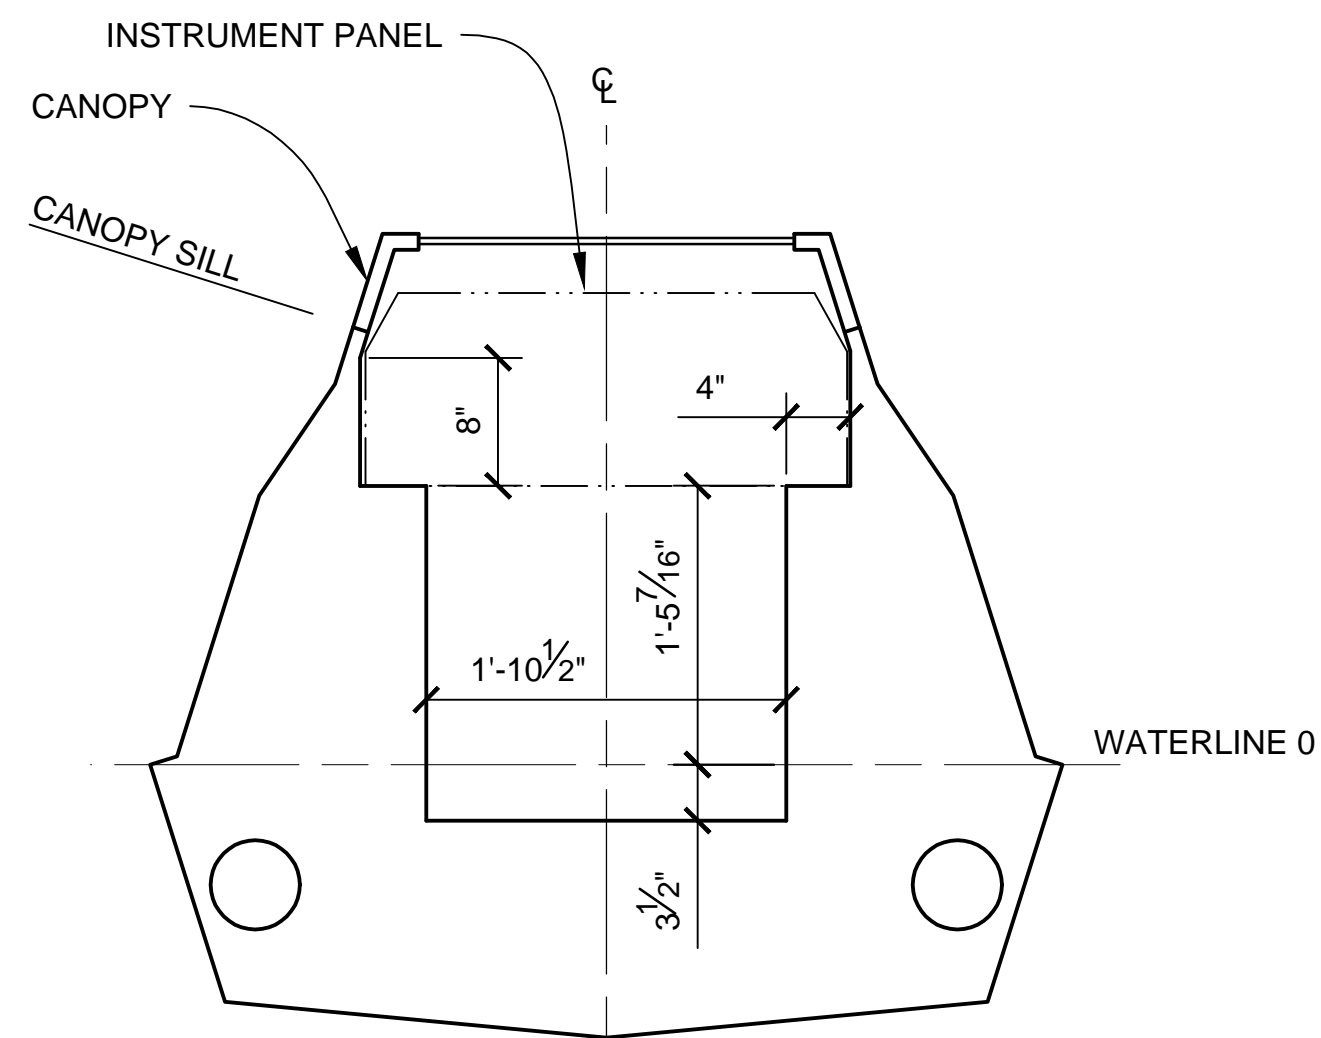


STA 18
SCALE 1:12

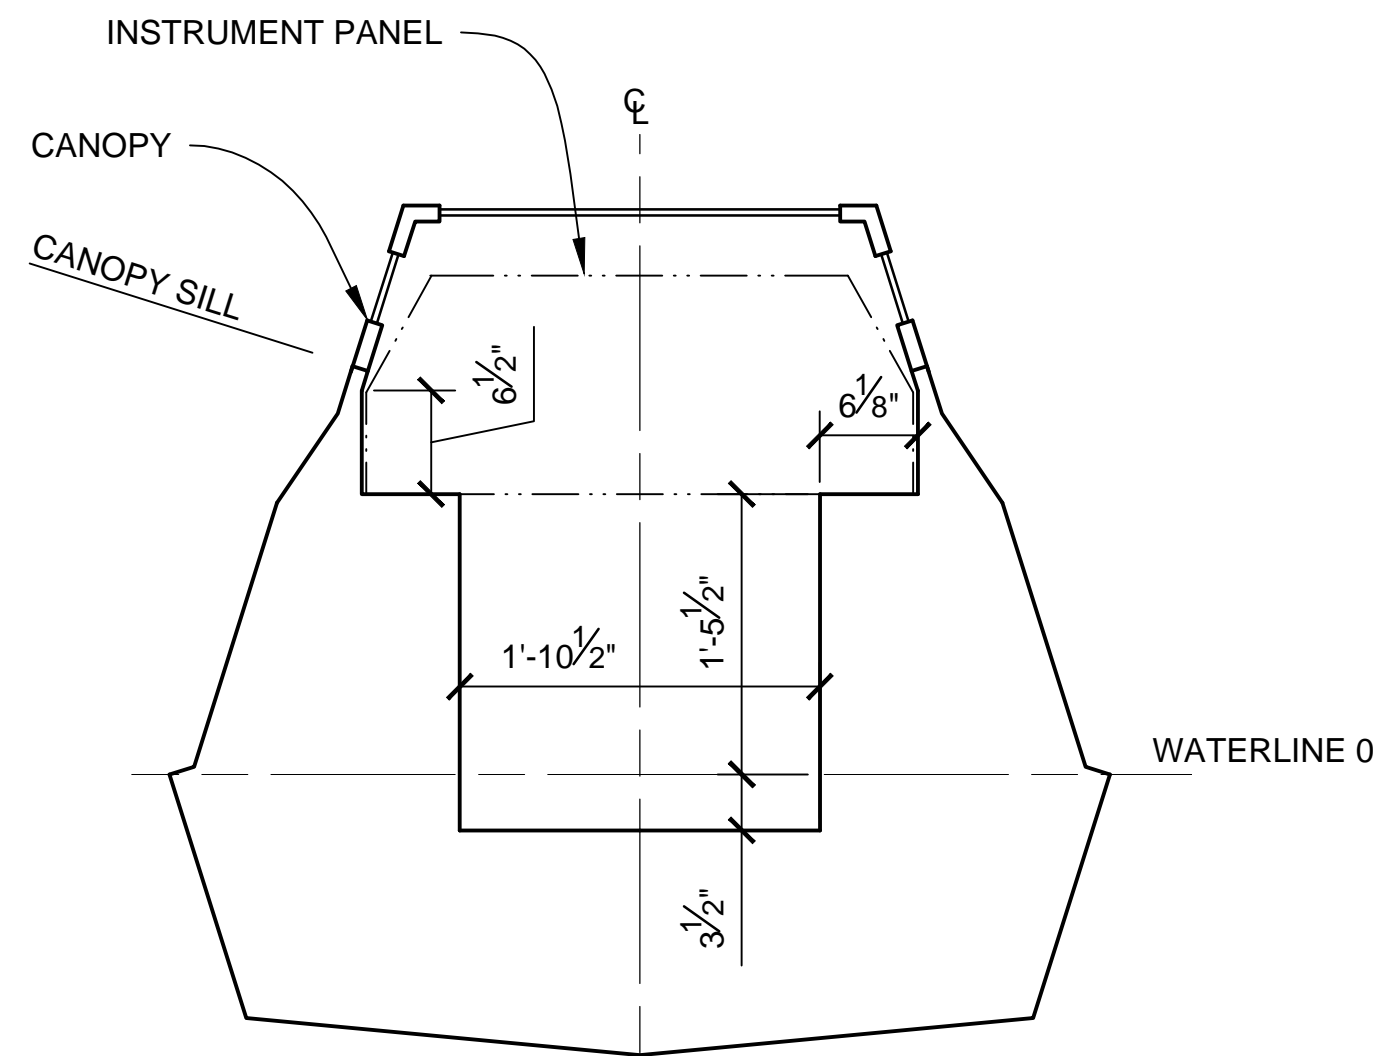


STA 19
SCALE 1:12

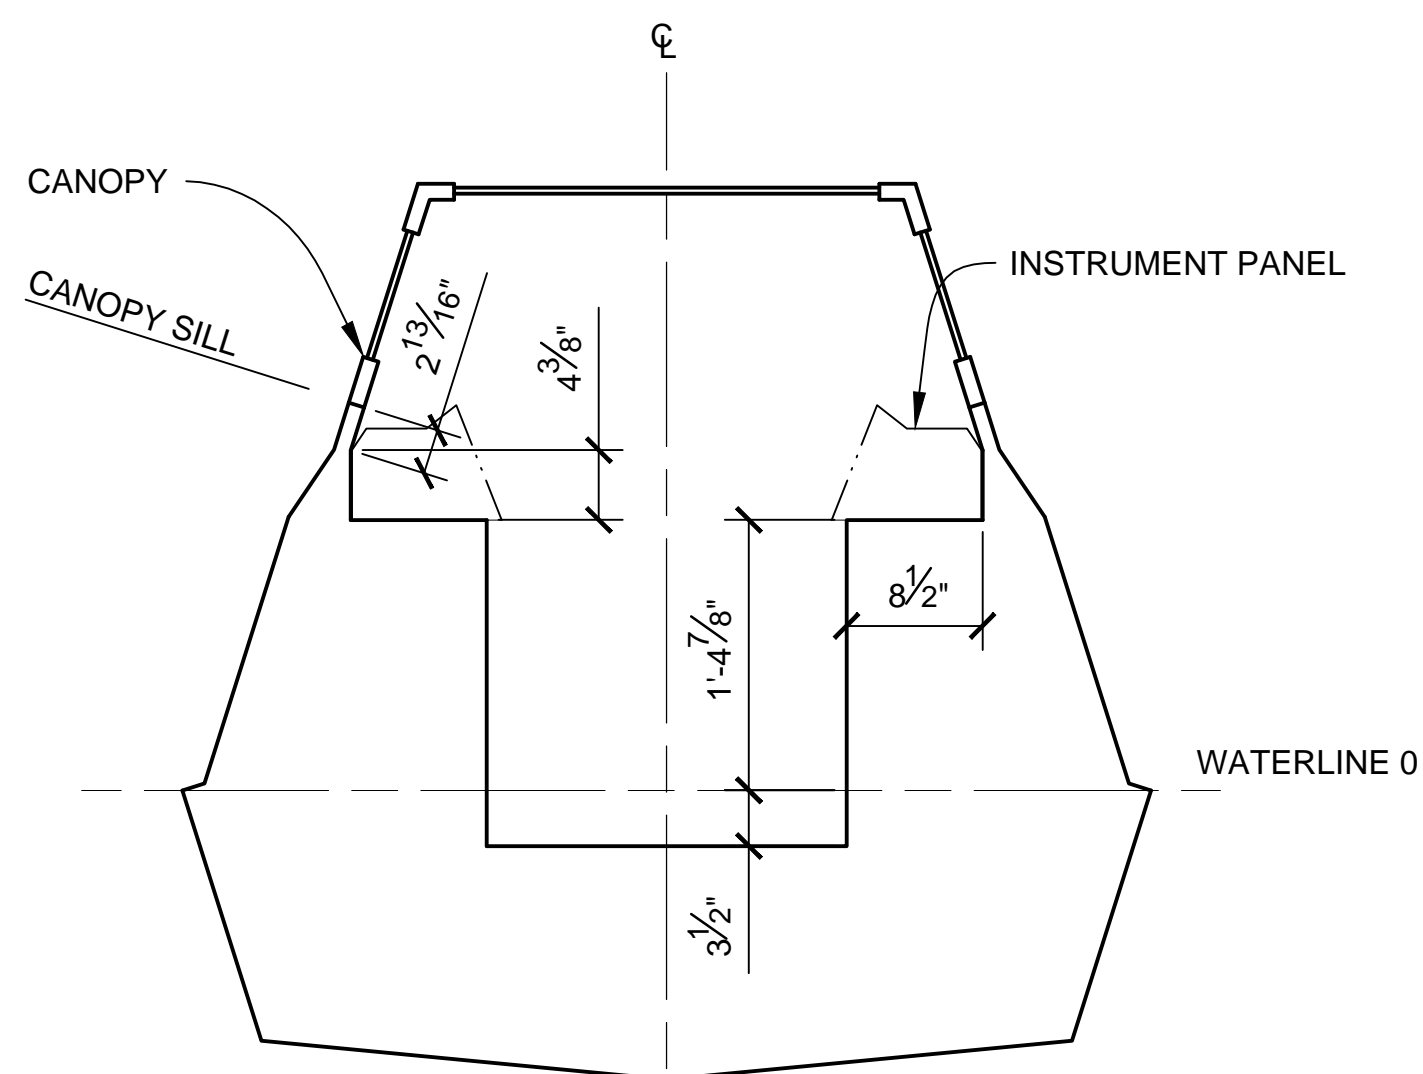


STA 20
SCALE 1:12

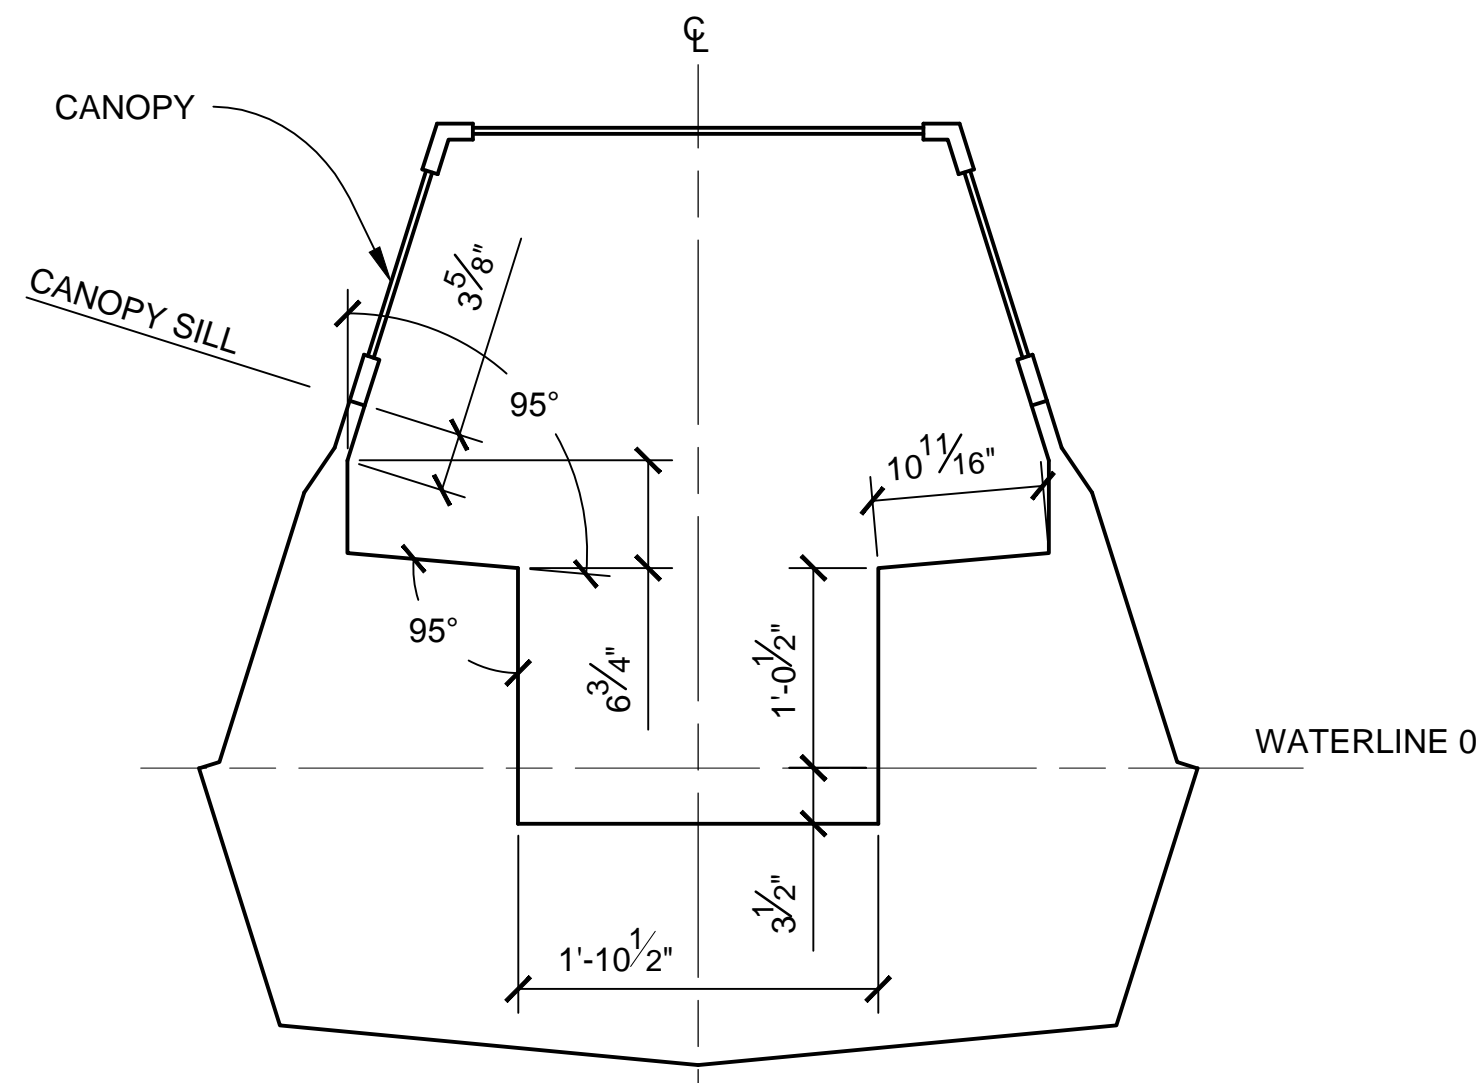


STA 21
SCALE 1:12

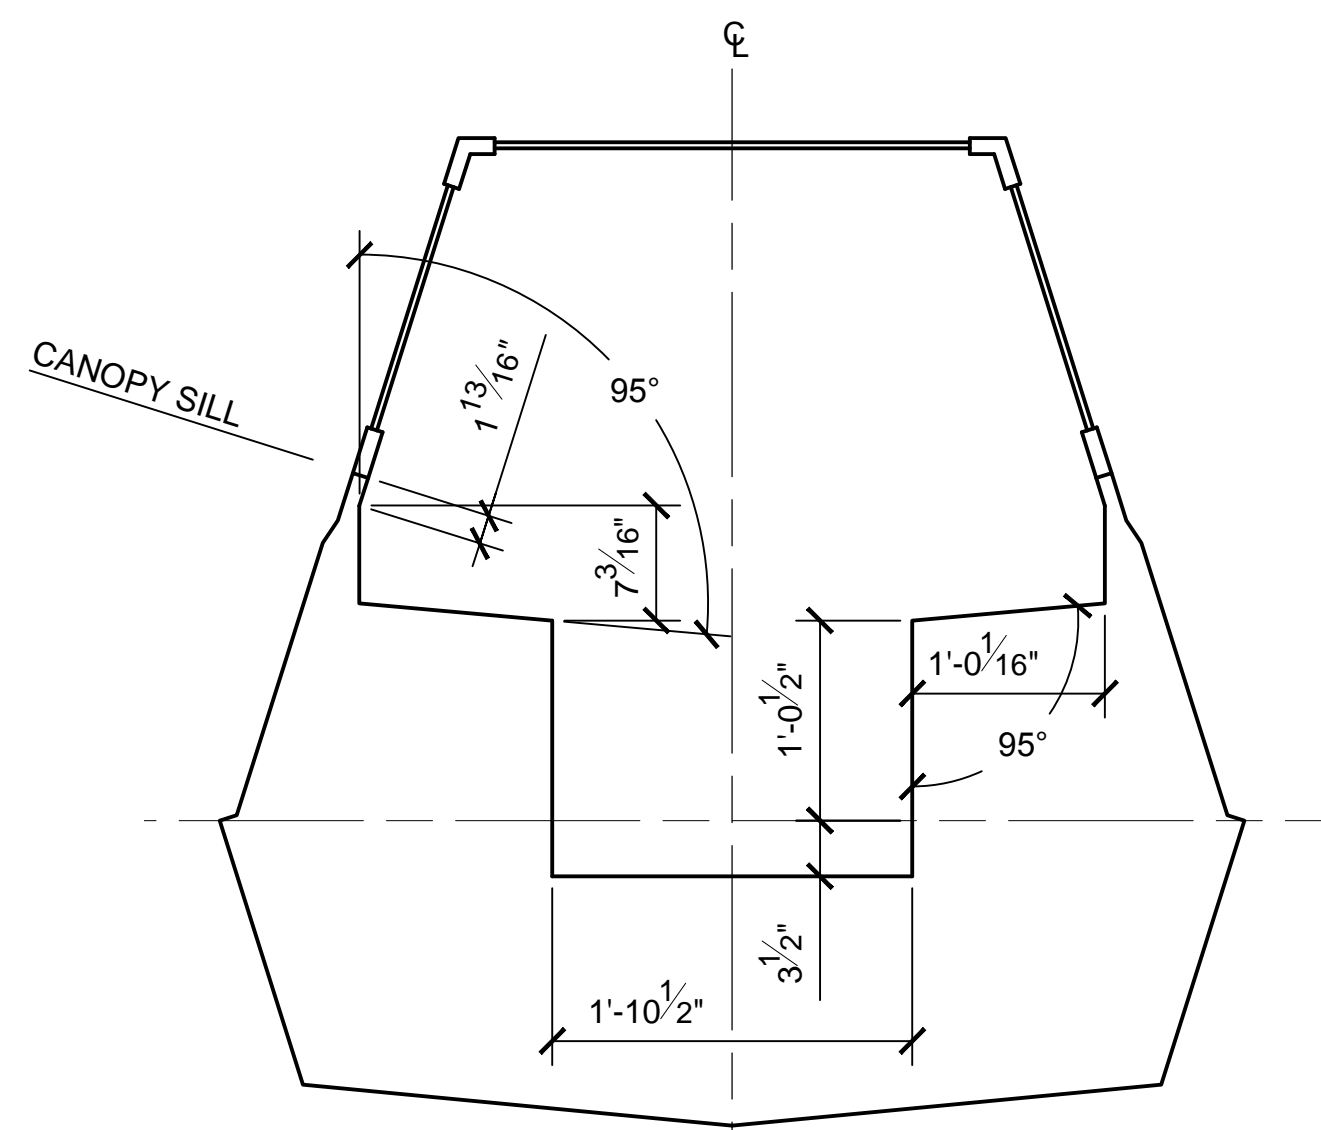

STA 22
SCALE 1:12

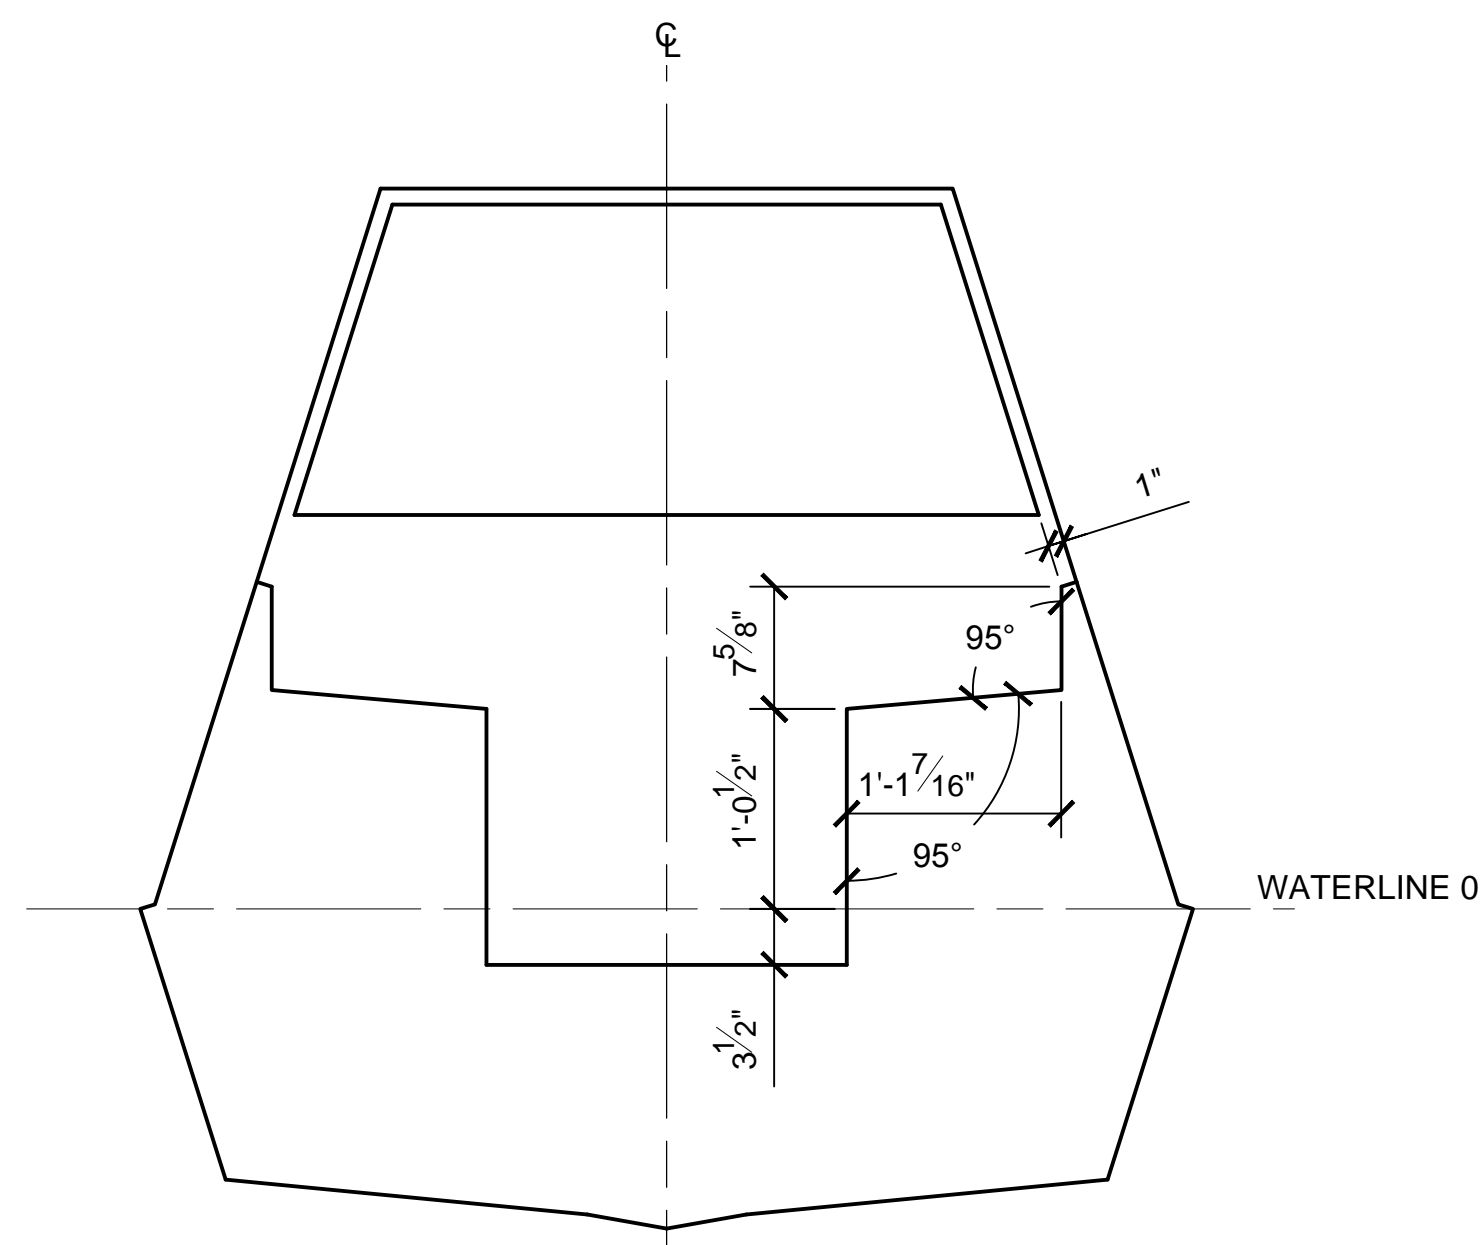

STA 23
SCALE 1:12

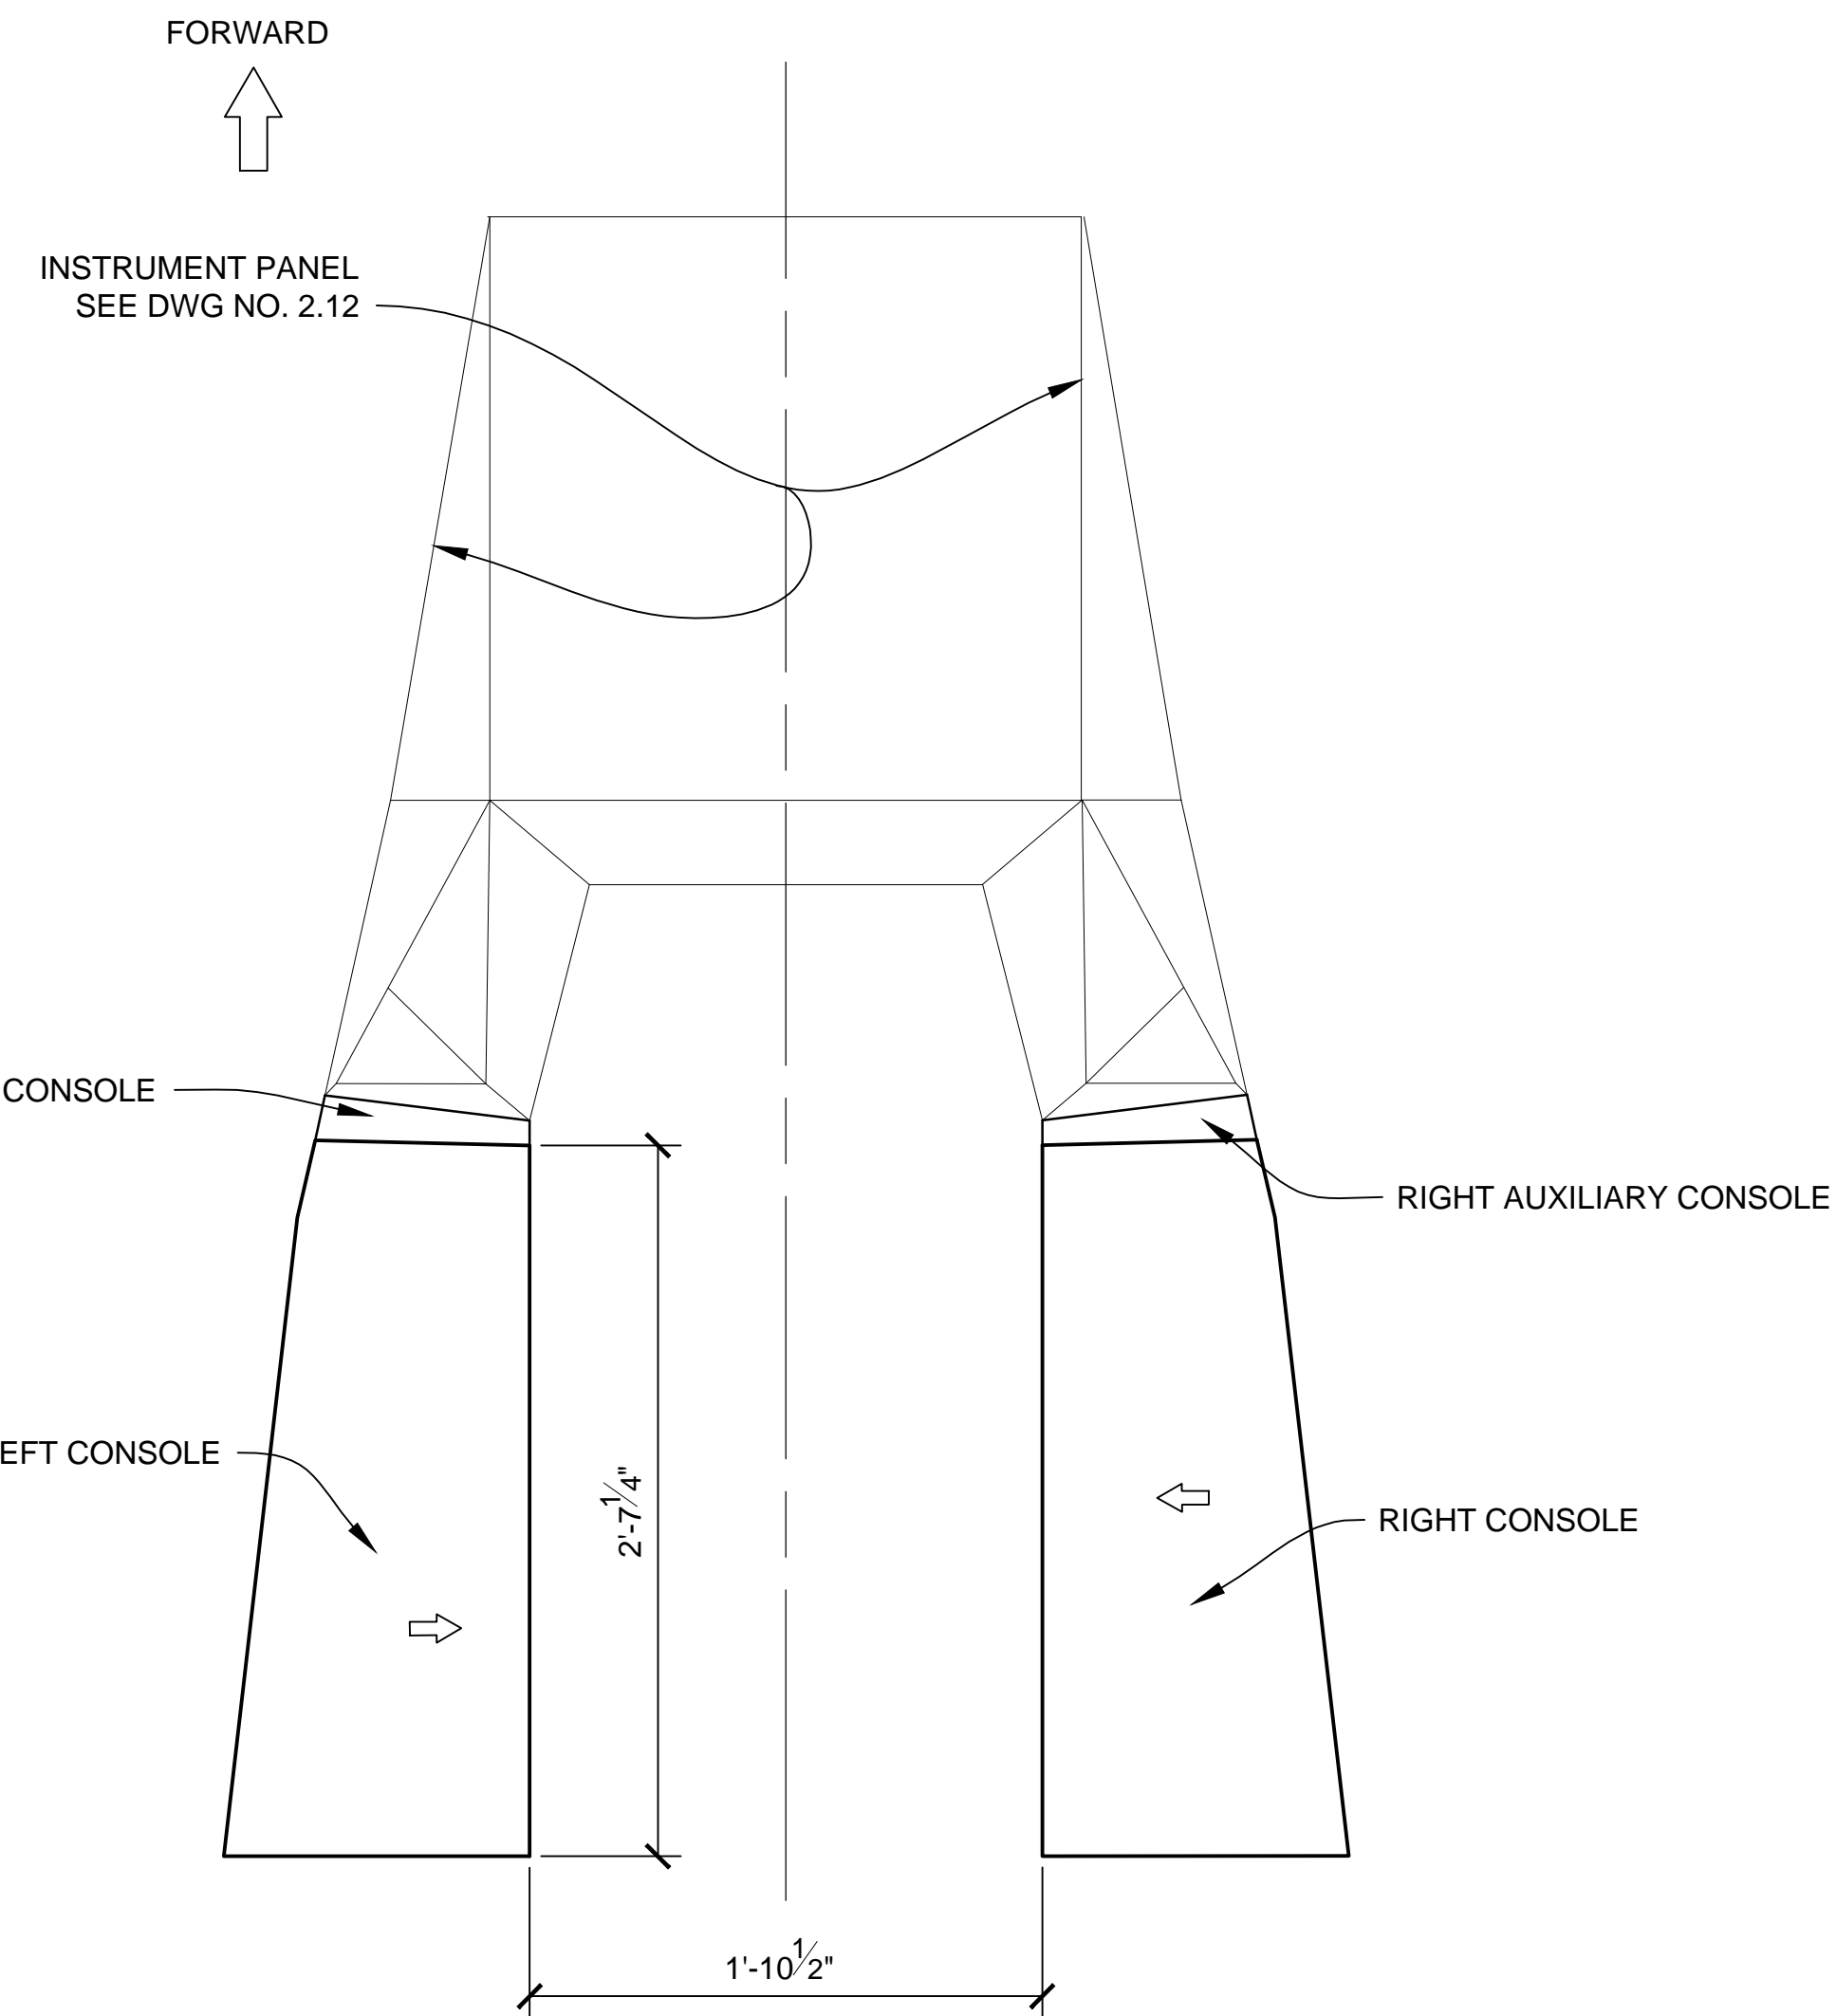


COCKPIT PLAN
SCALE 1:8



- NOTES:**
1. PREEXISTING MATERIAL COPYRIGHTED BY THE STAR WARS CORPORATION AND LUCASFILM LTD.
 2. SEE DWG NO. 2.04 FOR COMPLETE CROSS SECTION DIMENSIONS.

PRODUCTION	D.O.P.	ART DIRECTOR	CAMERA	
ART DEPT.	SET DESIGNER	SCULPTOR	GRAPHICS	
SET DEC.	DRAPES	PROPS	MODEL SHOP	
CONST. COORD.	CARPENTER	PLASTER	PAINT	
GREENS	SCENIC	METALS	SFX	
GRIP	ELECTRICAL	VFX	CGI	

PROJECT		THE X-WING BUILD	
1:1 SCALE STAGE PROP			
SET		SET NO.	
TITLE		REV	
FUSELAGE DETAILS		--	
"A NEW HOPE" COCKPIT SECTIONS			
PROD DESIGNER		DATE DRAWN	
		29/NOV/2012	
DRAWN BY	APPROVED BY	DATE ISSUED	
B.J.S.		DD/MMM/YYYY	
STAGE	LOCATION	DWG NO.	
		2.13	
FILE	X-WING LINES_MASTER.DWG	SHEET	15 OF XX

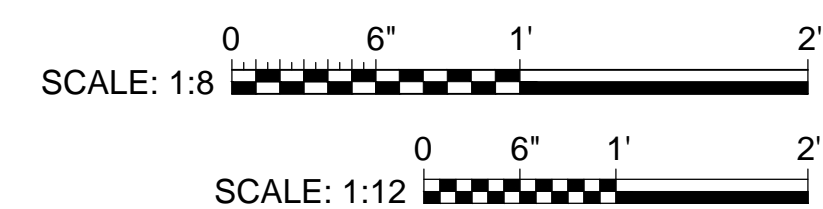

NOTES:
1. PREEXISITING MATERIAL COPYRIGHTED BY THE STAR WARS CORPORATION AND LUCASFILM LTD.

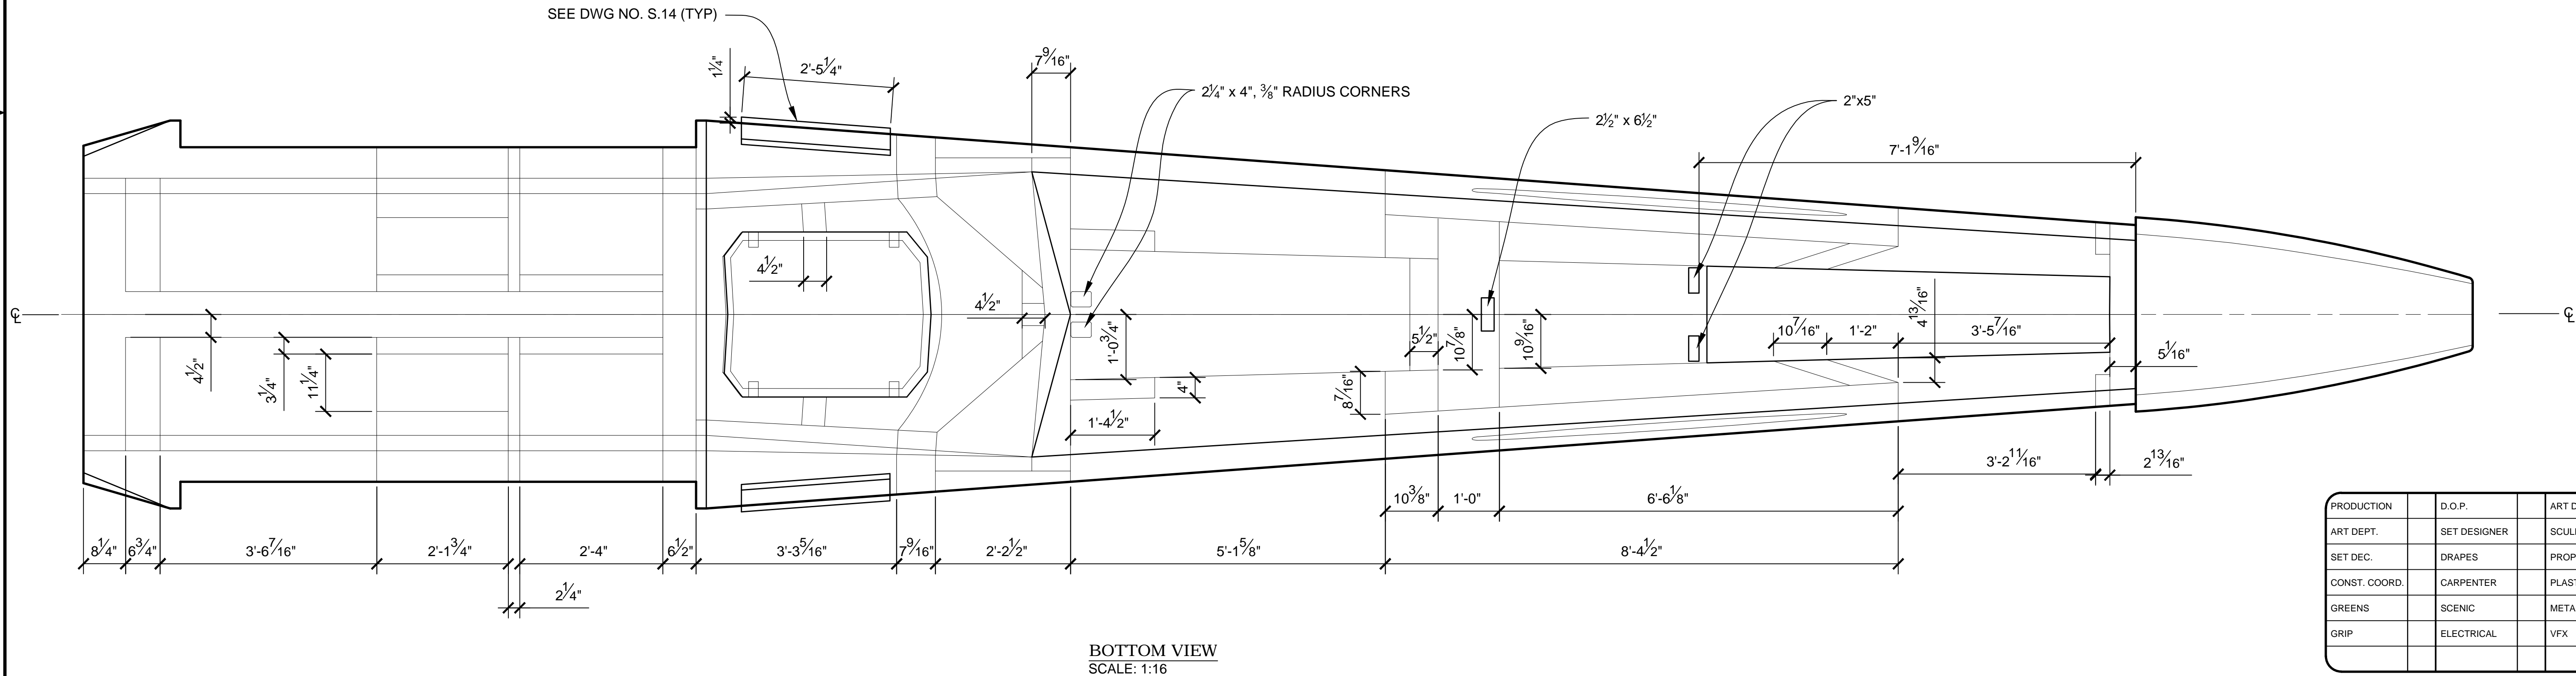
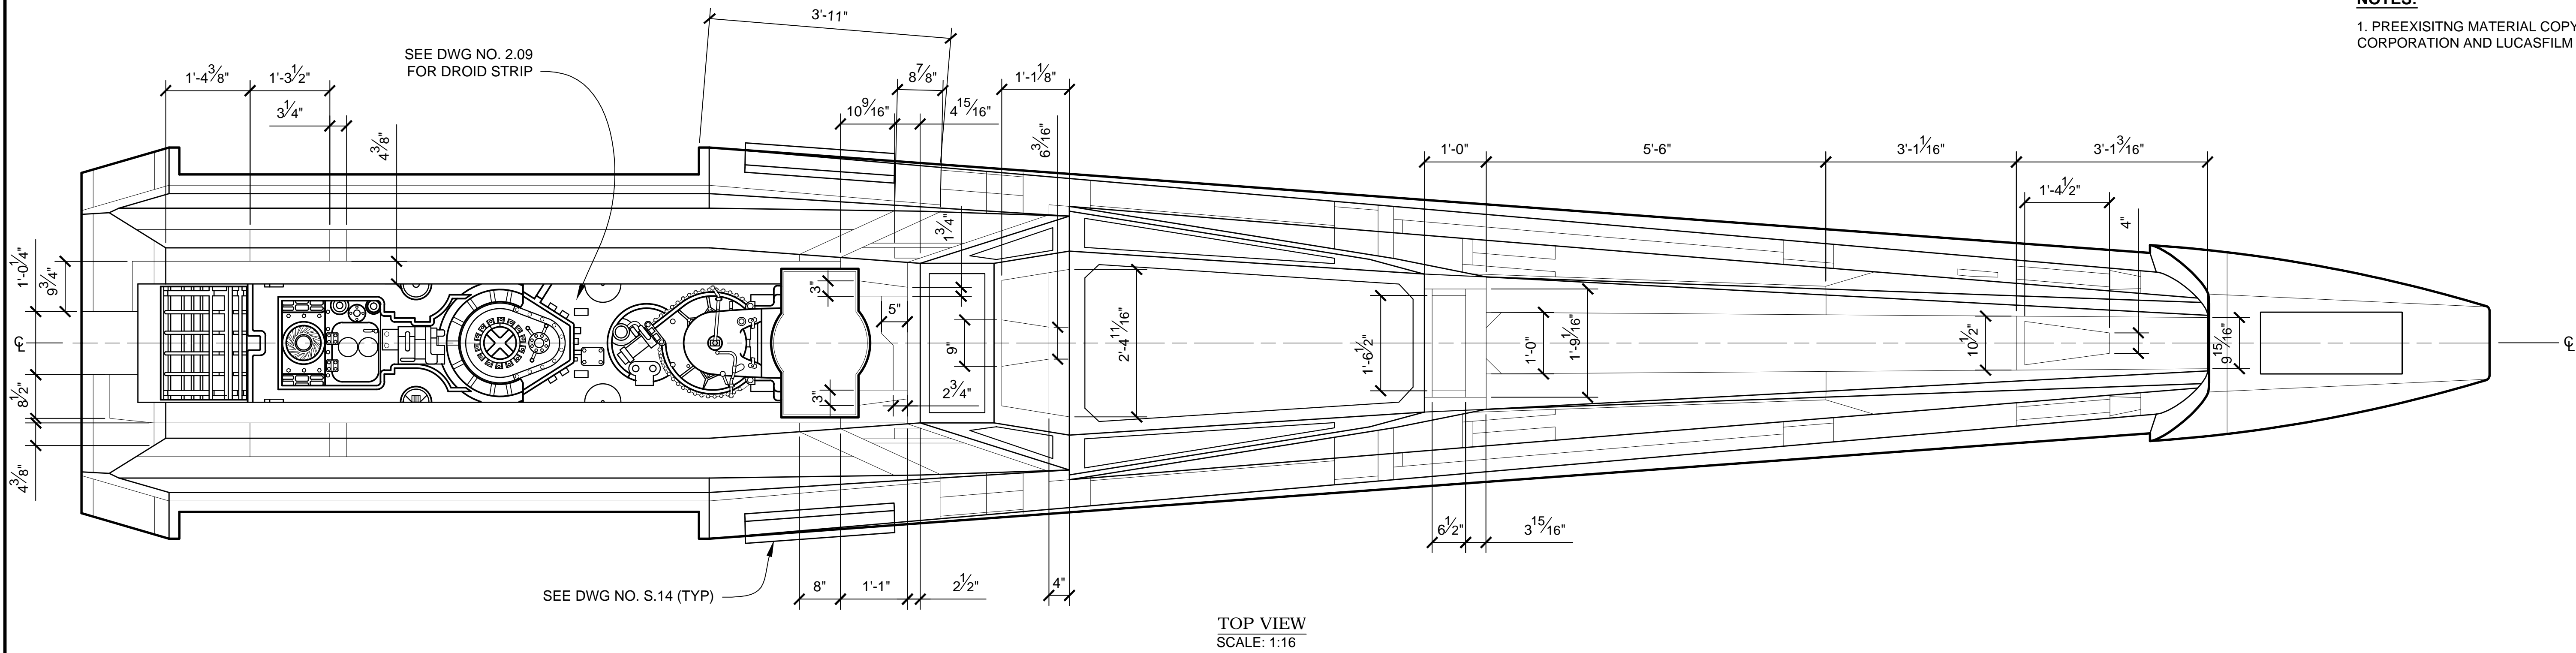


PRODUCTION	D.O.P.	ART DIRECTOR	CAMERA
ART DEPT.	SET DESIGNER	SCULPTOR	GRAPHICS
SET DEC.	DRAPES	PROPS	MODEL SHOP
CONST. COORD.	CARPENTER	PLASTER	PAINT
GREENS	SCENIC	METALS	SFX
GRIP	ELECTRICAL	VFX	CGI




PROJECT			
THE X-WING BUILD			
1:1 SCALE STAGE PROP			
SET			SET NO.
TITLE	FUSELAGE PANEL LINES & GREEBLIES		REV --
PROD DESIGNER		DATE DRAWN 3/SEP/2012	
DRAWN BY B.J.S.	APPROVED BY		DATE ISSUED DD/MM/YYYY
STAGE	LOCATION		DWG NO. 2.13
FILE X-WING LINES_MASTER.DWG	SHEET 16	OF XX	


NOTES:
1. PREEXISTING MATERIAL COPYRIGHTED BY THE STAR WARS CORPORATION AND LUCASFILM LTD.

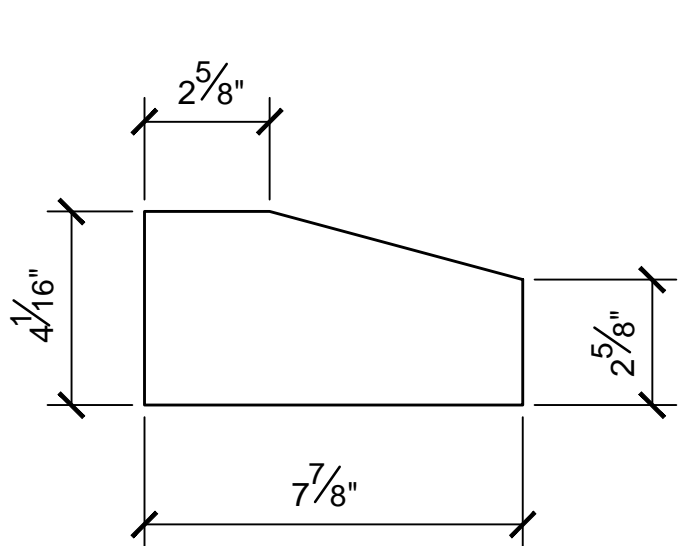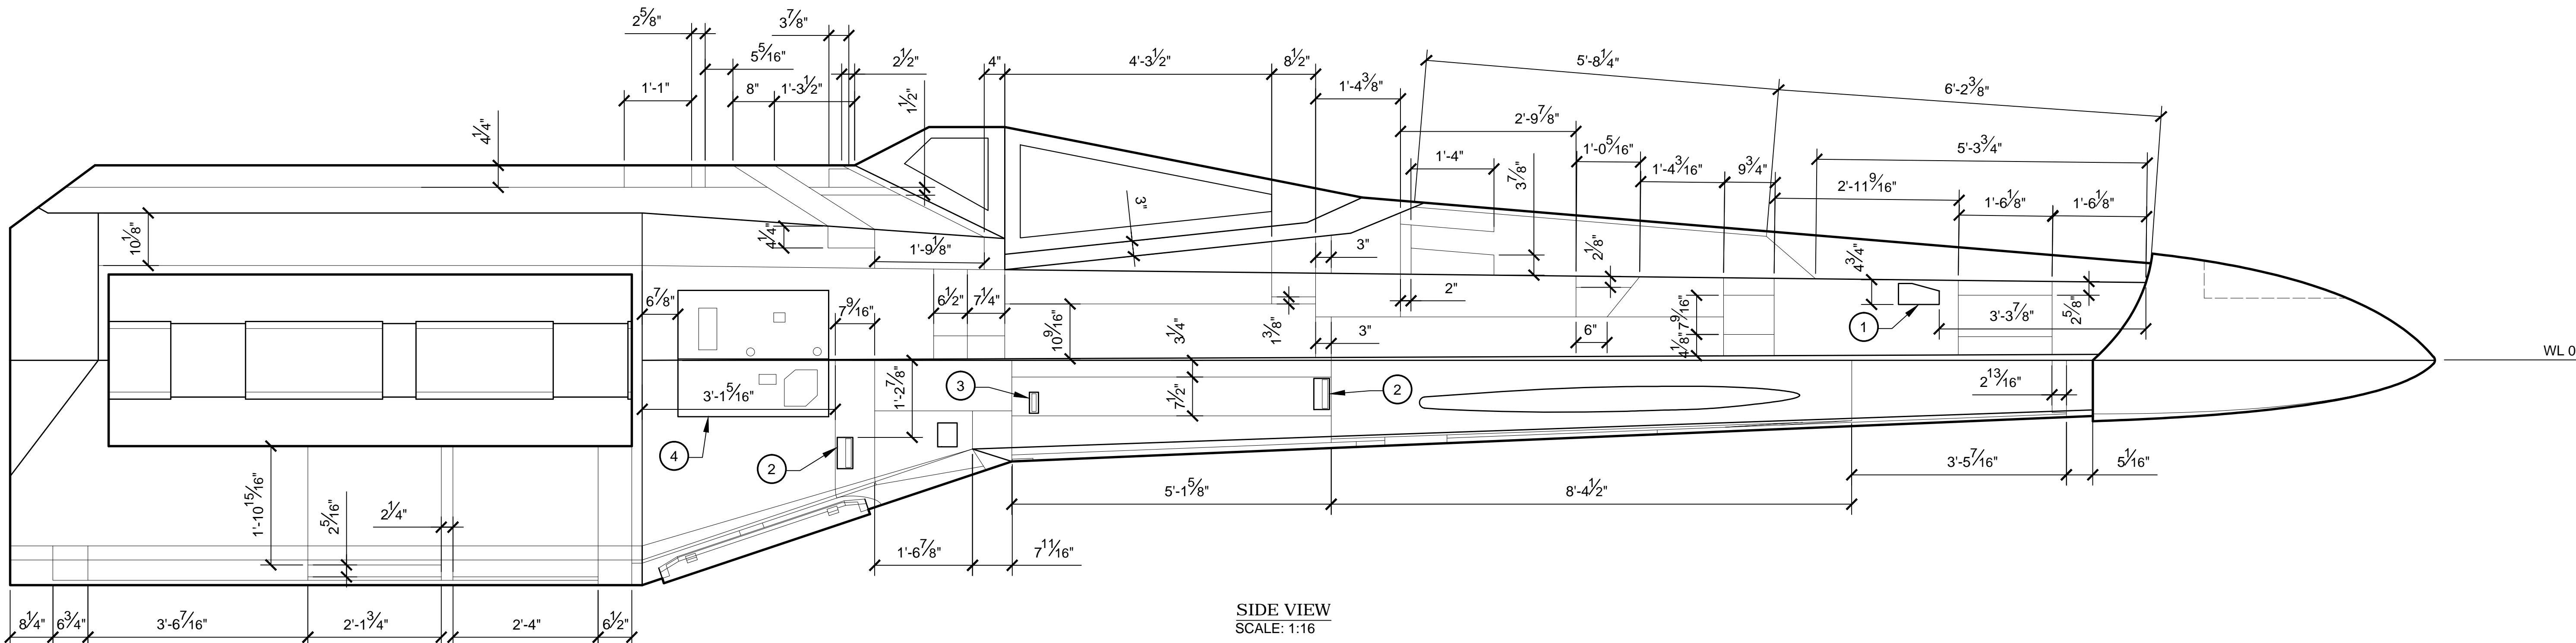


1 GREEBLIE
SCALE: 1:4

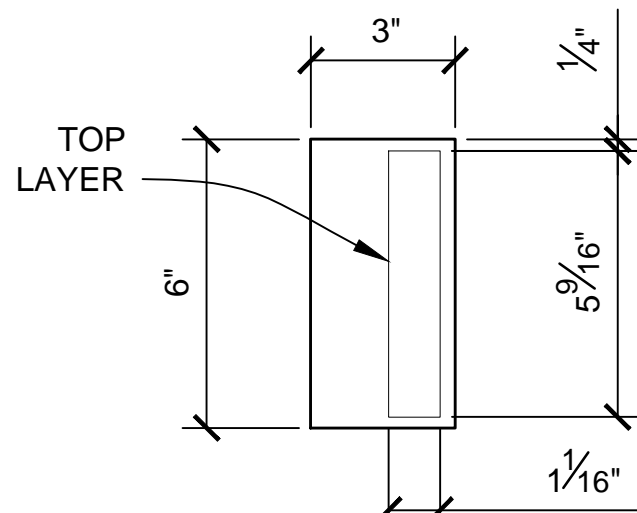

2 GREEBLIE
SCALE: 1:4

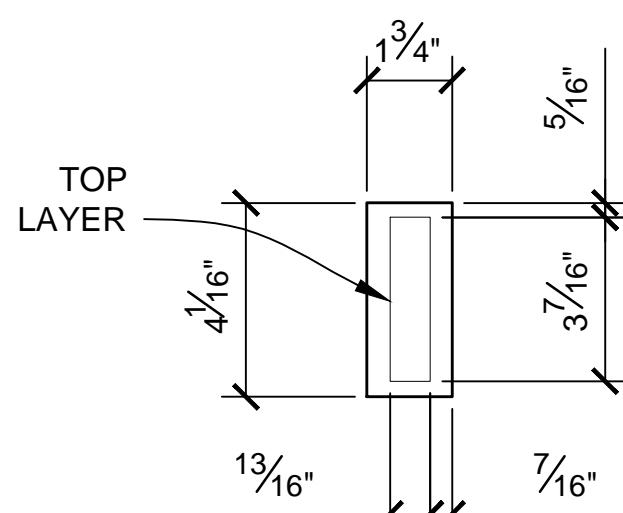


3 GREEBLIE
SCALE: 1:4

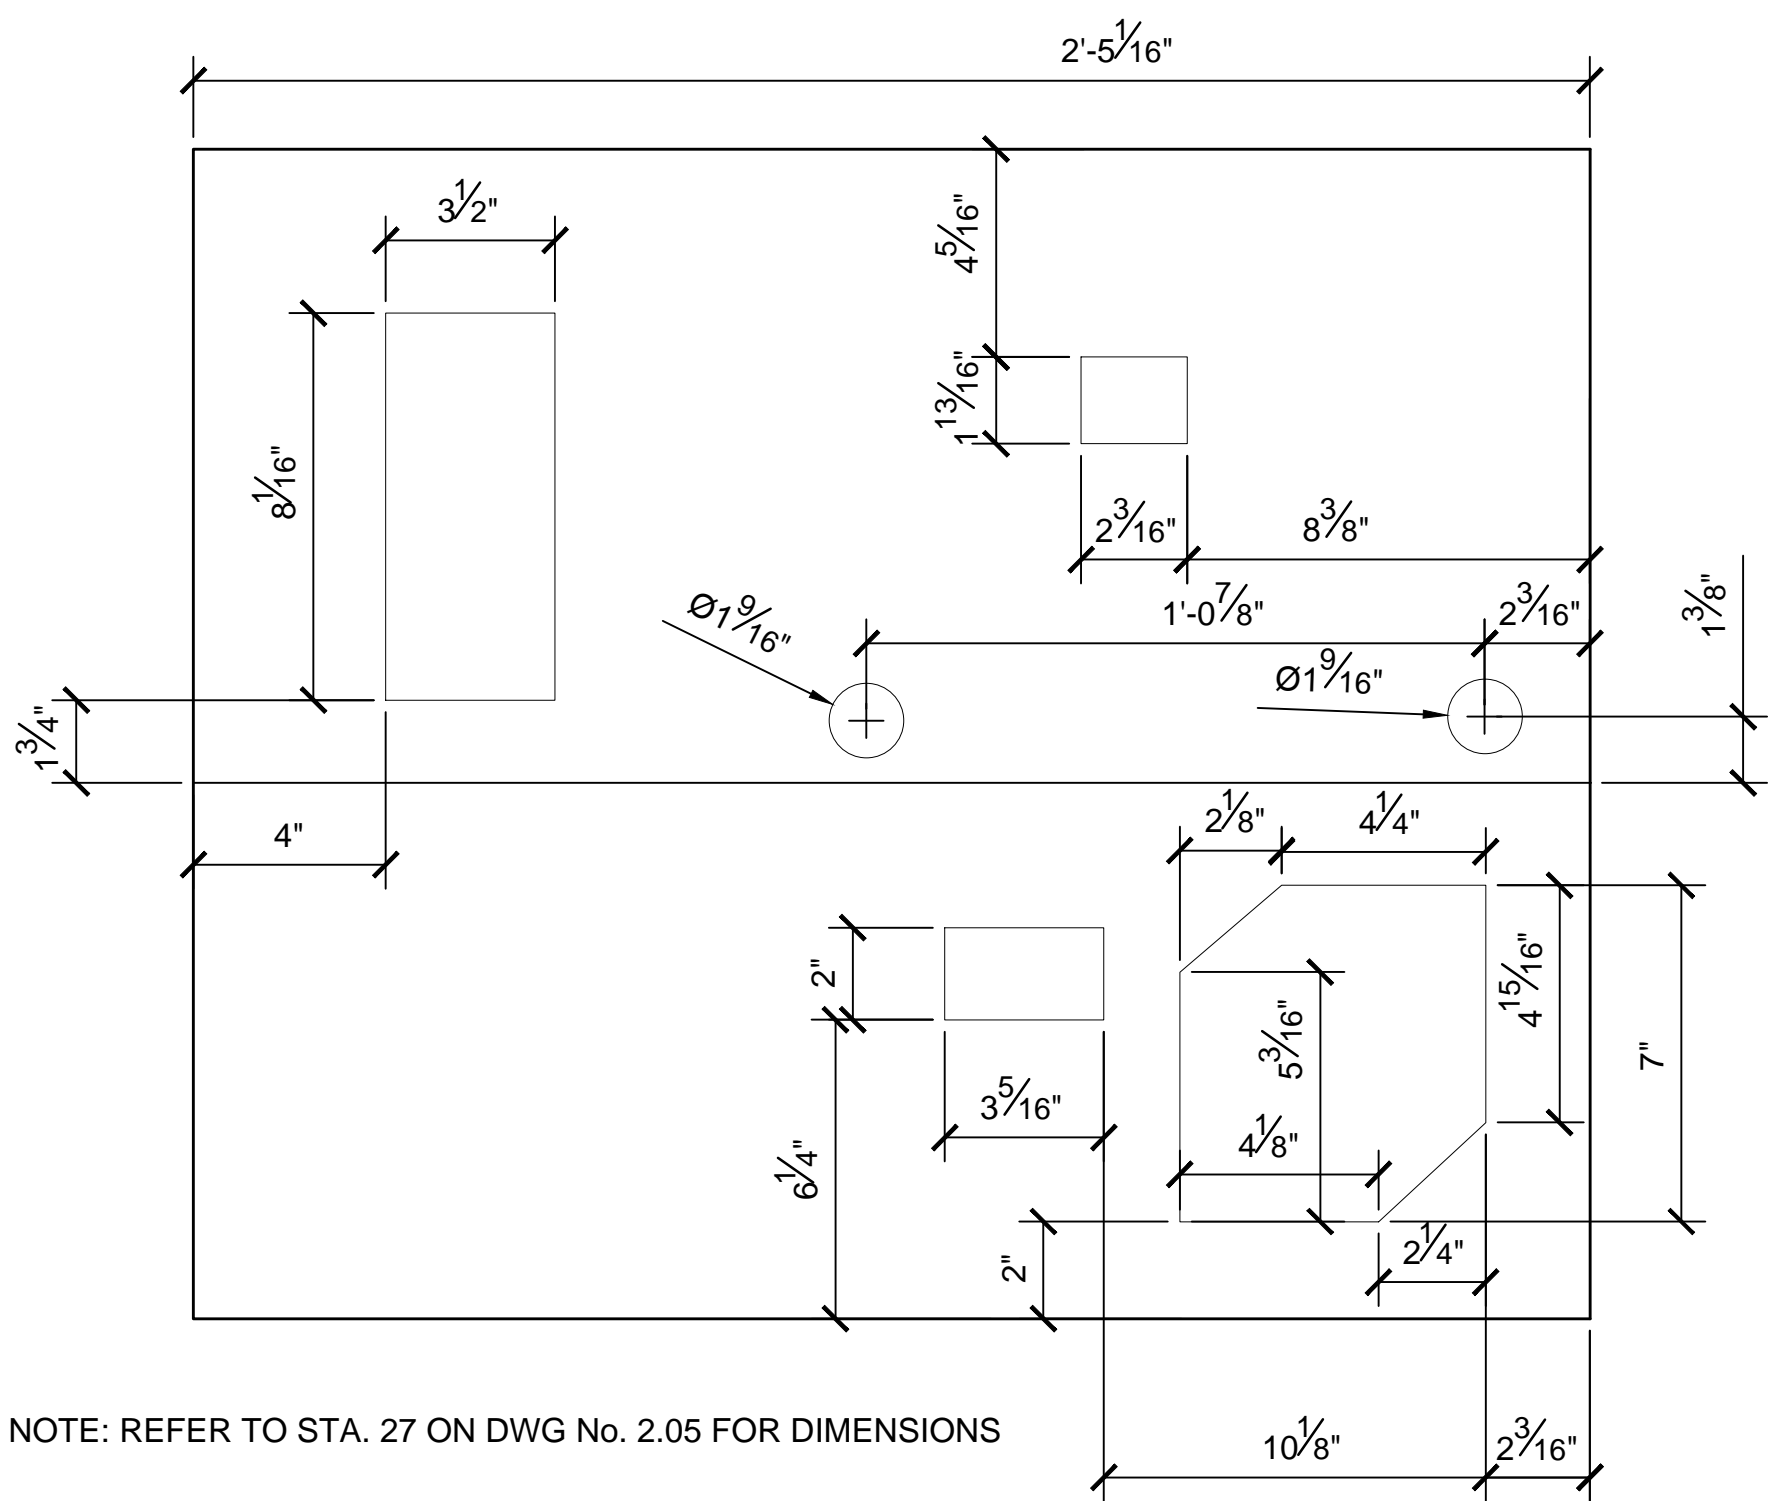


NOTE: REFER TO STA. 27 ON DWG No. 2.05 FOR DIMENSIONS

4 GREEBLIE
SCALE: 1:4

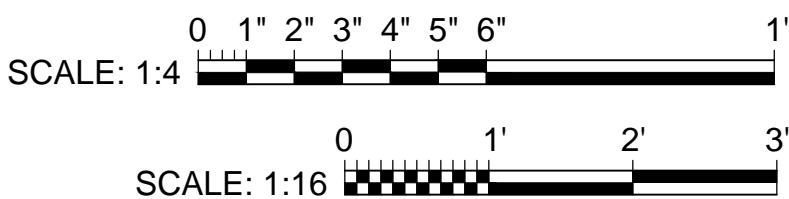

PRODUCTION	D.O.P.	ART DIRECTOR	CAMERA	
ART DEPT.	SET DESIGNER	SCULPTOR	GRAPHICS	
SET DEC.	DRAPES	PROPS	MODEL SHOP	
CONST. COORD.	CARPENTER	PLASTER	PAINT	
GREENS	SCENIC	METALS	SFX	
GRIP	ELECTRICAL	VFX	CGI	

PROJECT				
THE X-WING BUILD 1:1 SCALE STAGE PROP				SET NO.
TITLE FUSELAGE PANEL LINES & GREEBLIES				REV --
PROD DESIGNER			DATE DRAWN 3/SEP/2012	
DRAWN BY B.J.S.			DATE ISSUED DD/MMM/YYYY	
STAGE		LOCATION		DWG NO. 2.14
FILE X-WING LINES_MASTER.DWG		SHEET 17 OF XX		

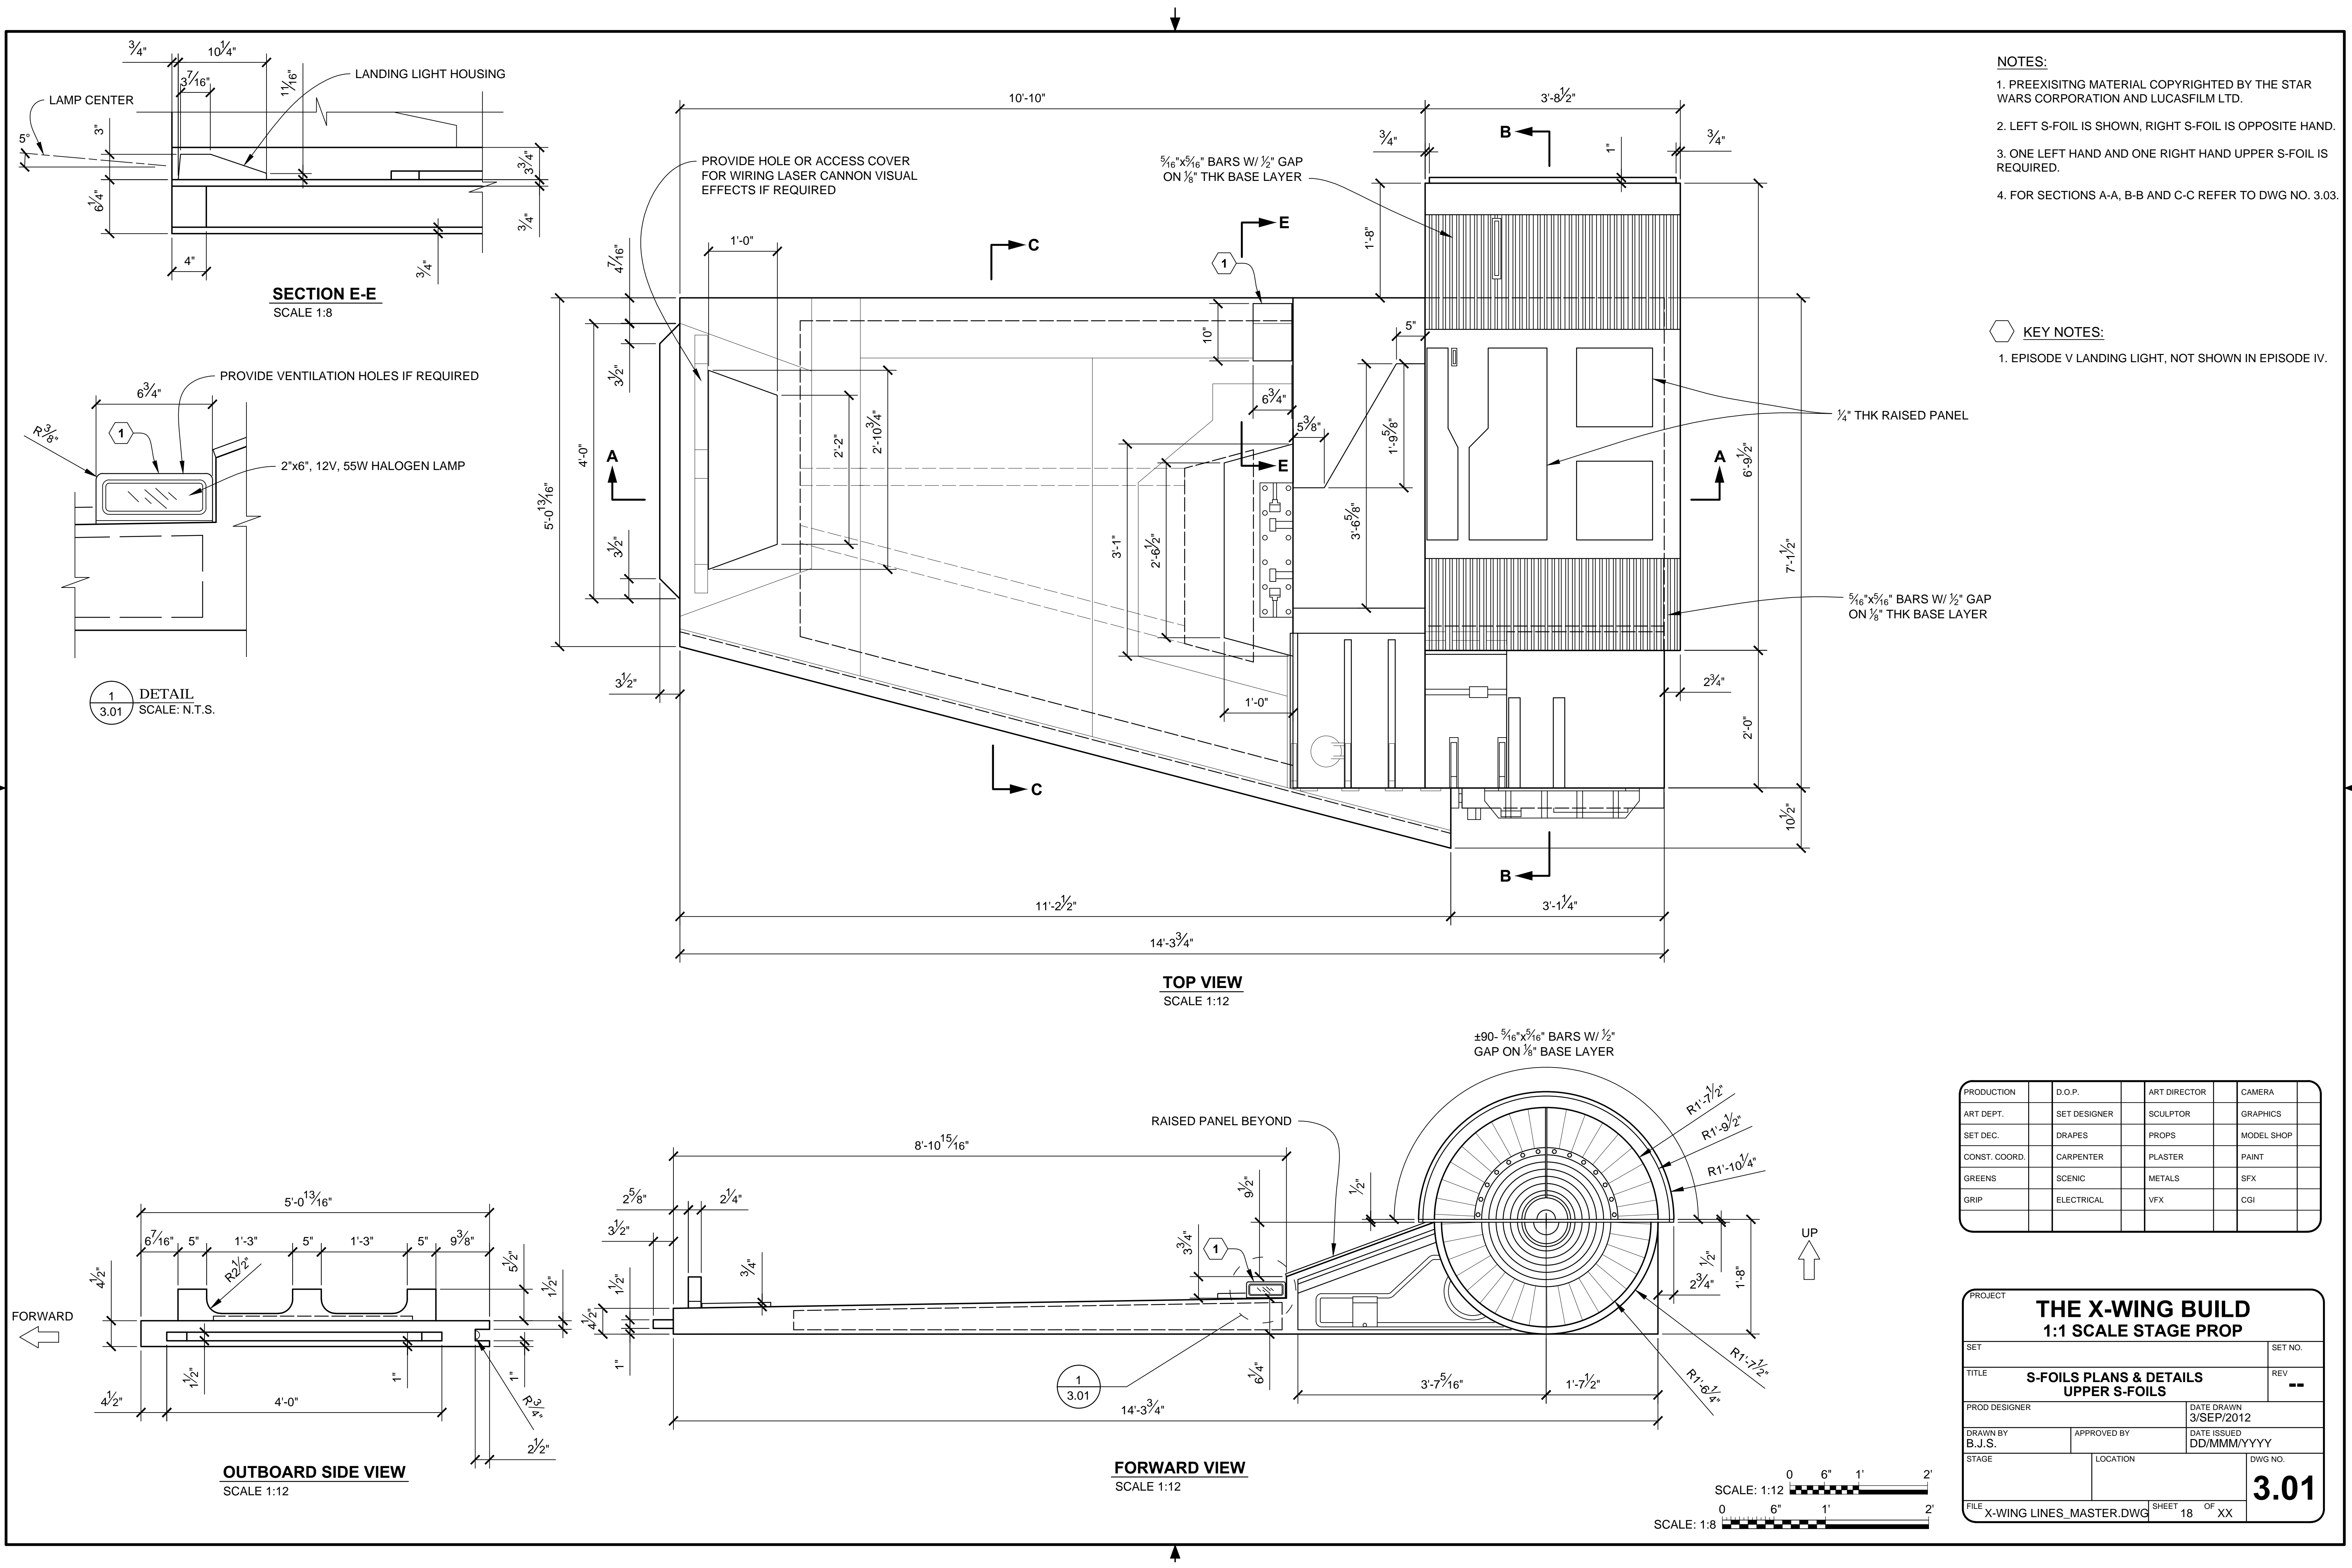


- NOTES:**
1. PREEXISITNG MATERIAL COPYRIGHTED BY THE STAR WARS CORPORATION AND LUCASFILM LTD.
 2. LEFT S-FOIL IS SHOWN, RIGHT S-FOIL IS OPPOSITE HAND.
 3. ONE LEFT HAND AND ONE RIGHT HAND UPPER S-FOIL IS REQUIRED.
 4. FOR SECTIONS A-A, B-B AND C-C REFER TO DWG NO. 3.03.


- KEY NOTES:**
1. EPISODE V LANDING LIGHT, NOT SHOWN IN EPISODE IV.

PRODUCTION	D.O.P.	ART DIRECTOR	CAMERA
ART DEPT.	SET DESIGNER	SCULPTOR	GRAPHICS
SET DEC.	DRAPES	PROPS	MODEL SHOP
CONST. COORD.	CARPENTER	PLASTER	PAINT
GREENS	SCENIC	METALS	SFX
GRIP	ELECTRICAL	VFX	CGI



PROJECT			
THE X-WING BUILD			
1:1 SCALE STAGE PROP			
SET	TITLE		SET NO.
	S-FOILS PLANS & DETAILS		REV
	UPPER S-FOILS		--
PROD DESIGNER		DATE DRAWN	
		3/SEP/2012	
DRAWN BY		DATE ISSUED	
B.J.S.		DD/MM/YYYY	
STAGE		LOCATION	DWG NO.
FILE		SHEET	OF
X-WING LINES_MASTER.DWG		18	XX
3.01			

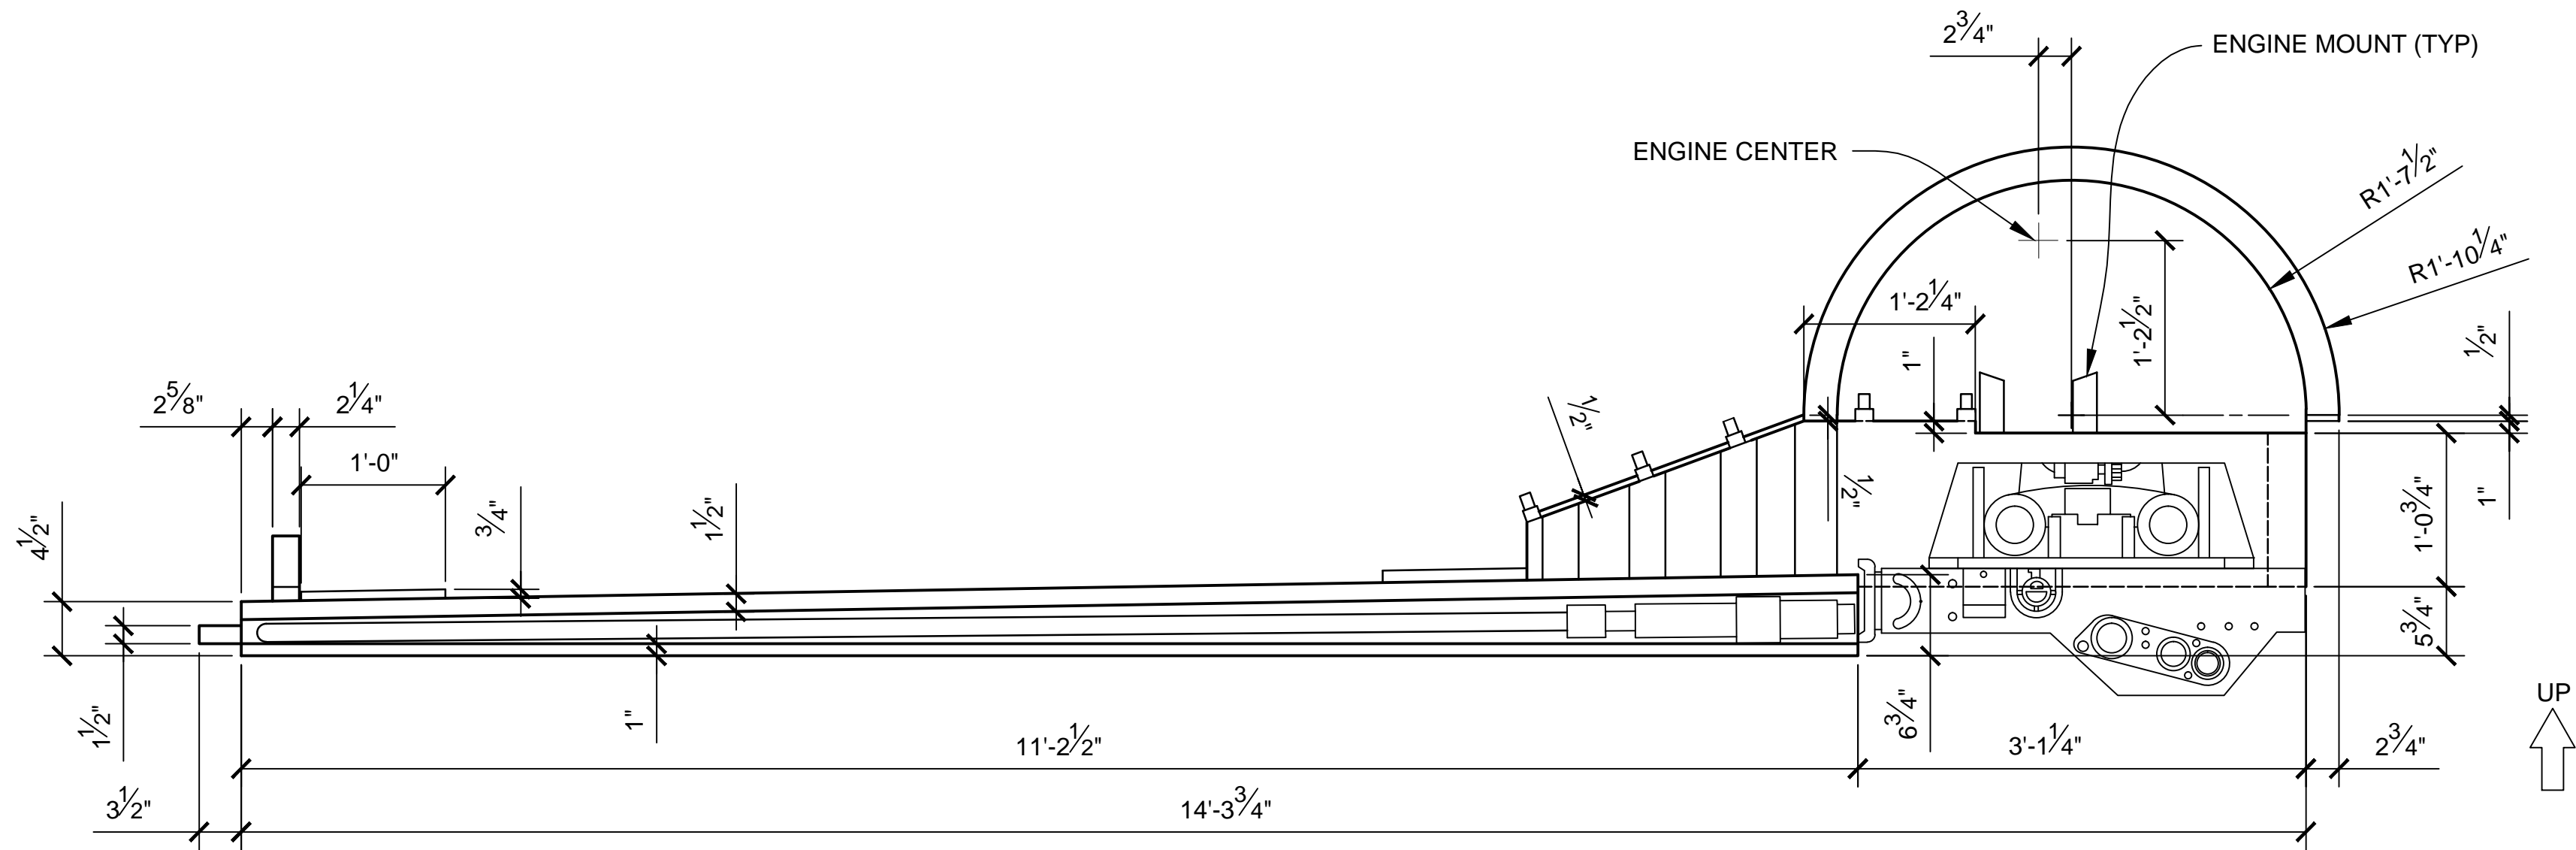

AFT VIEW
SCALE 1:12

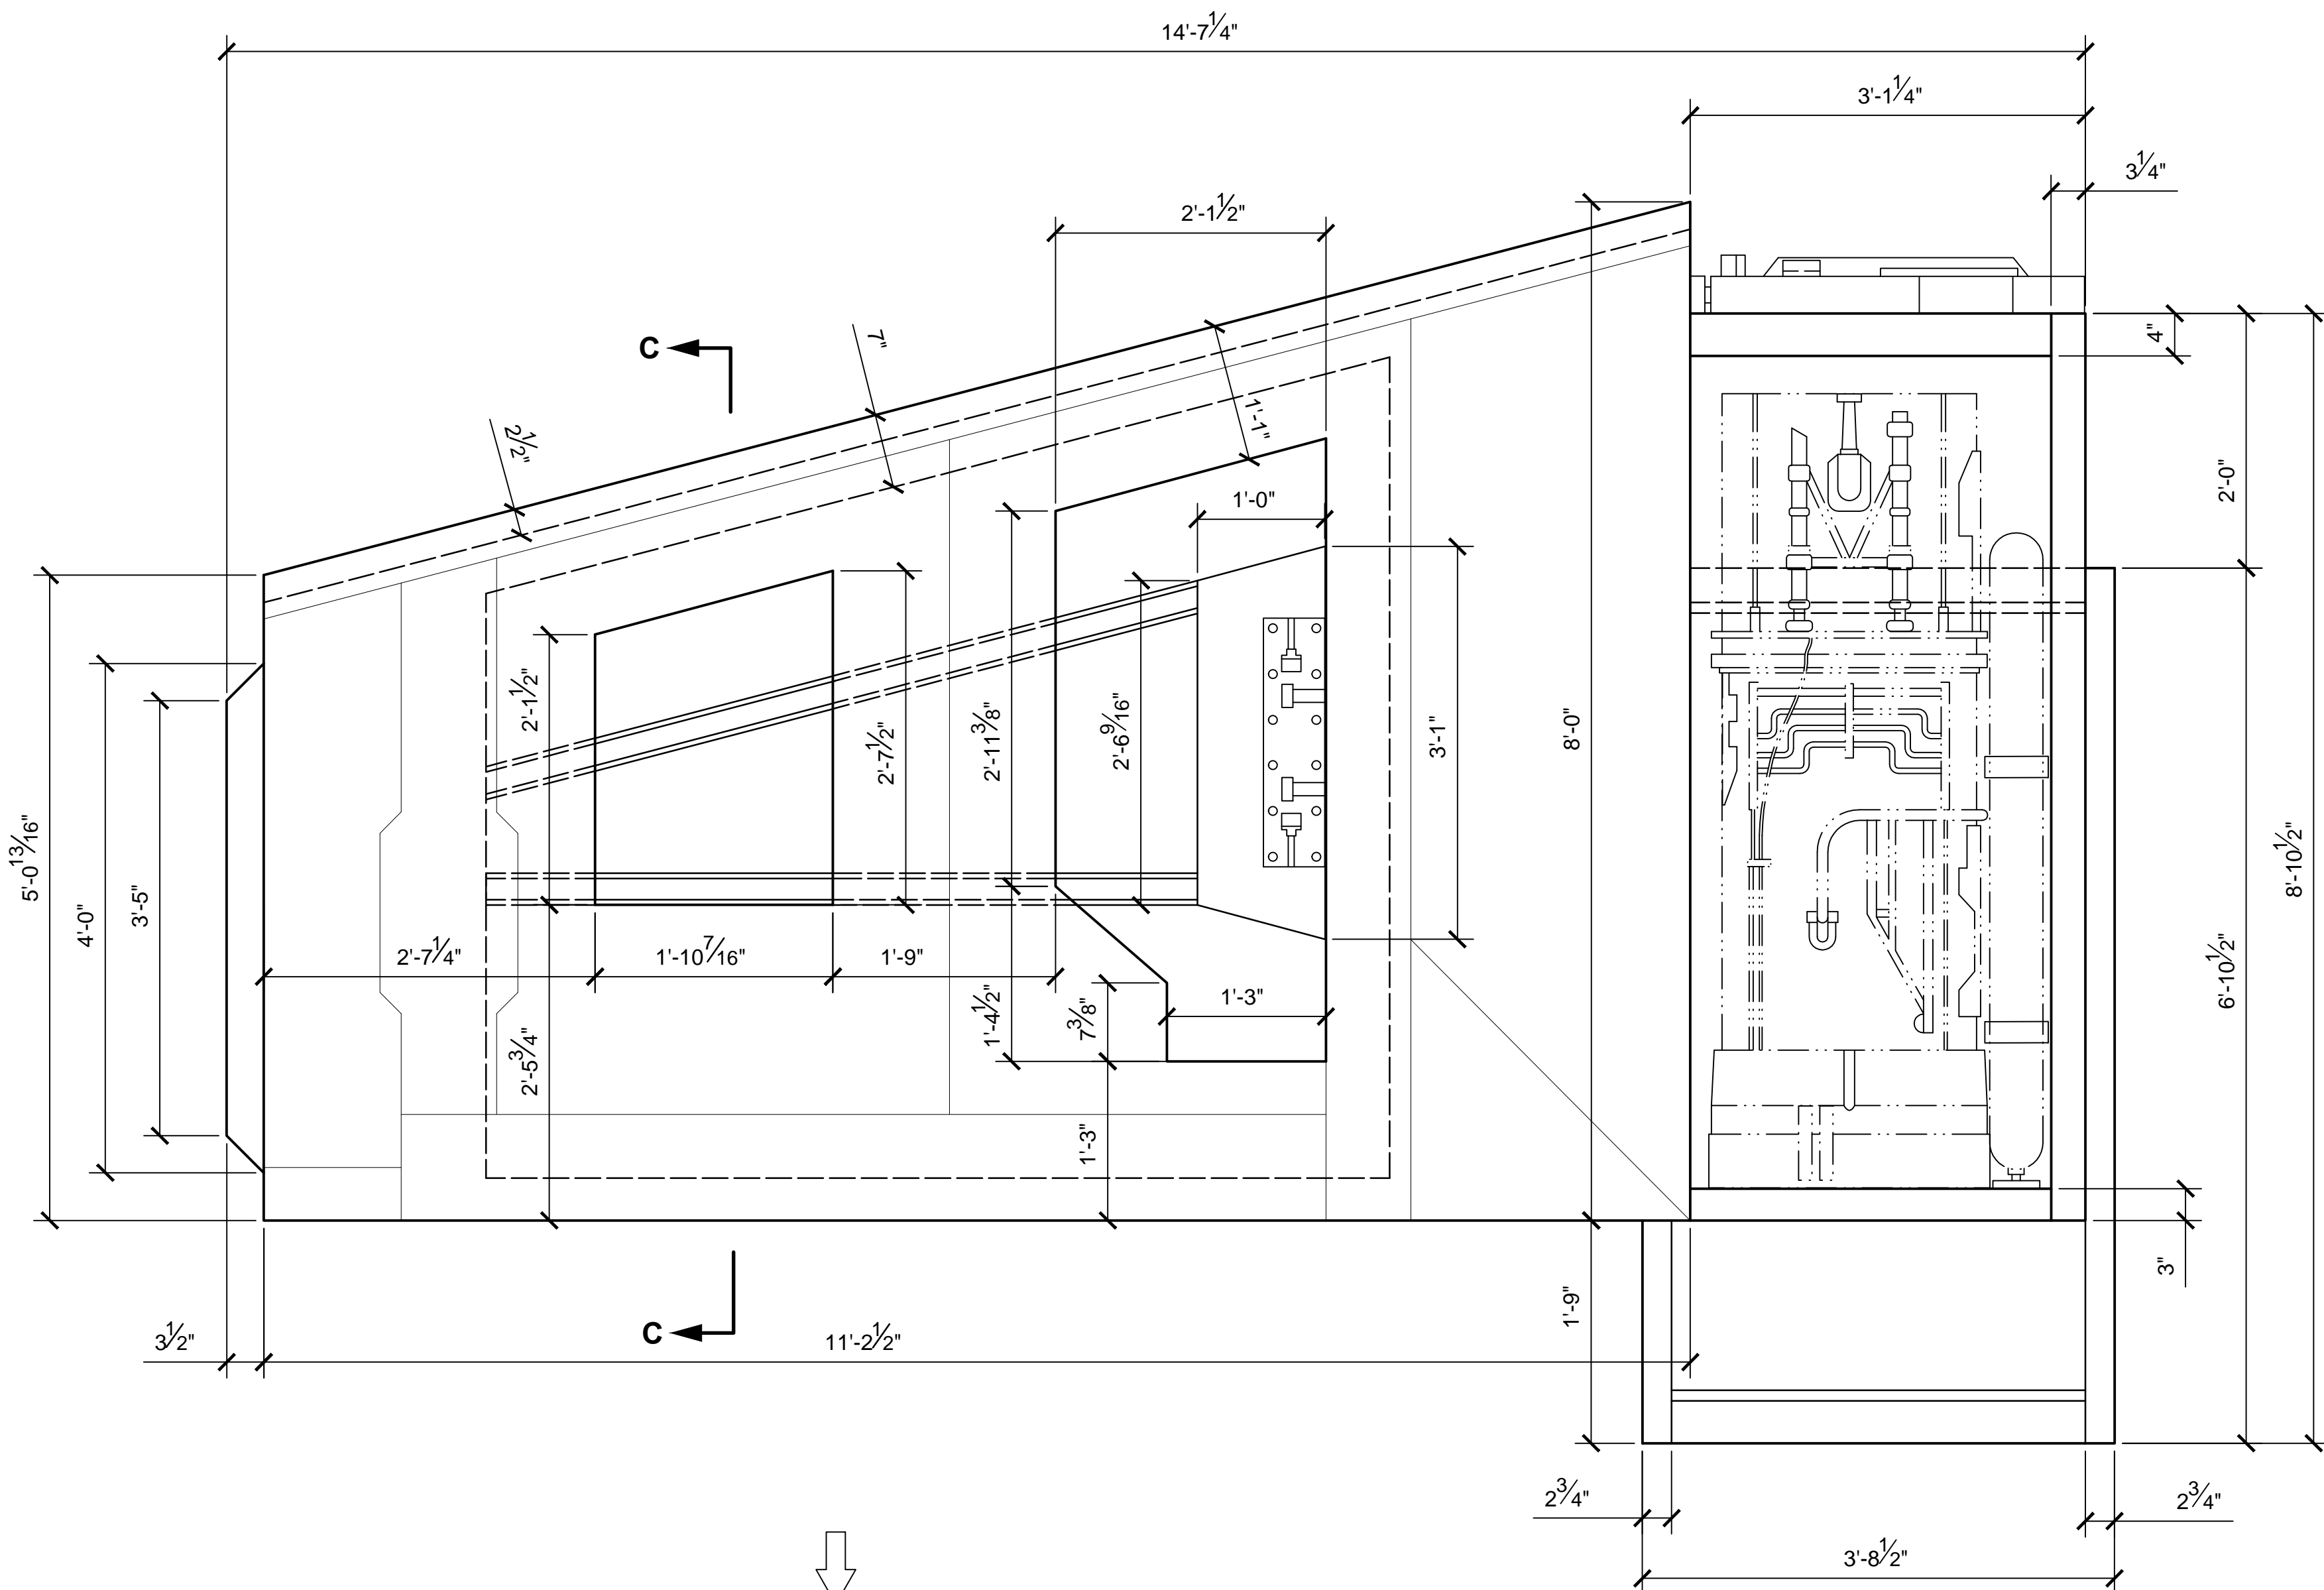

BOTTOM VIEW
SCALE 1:12

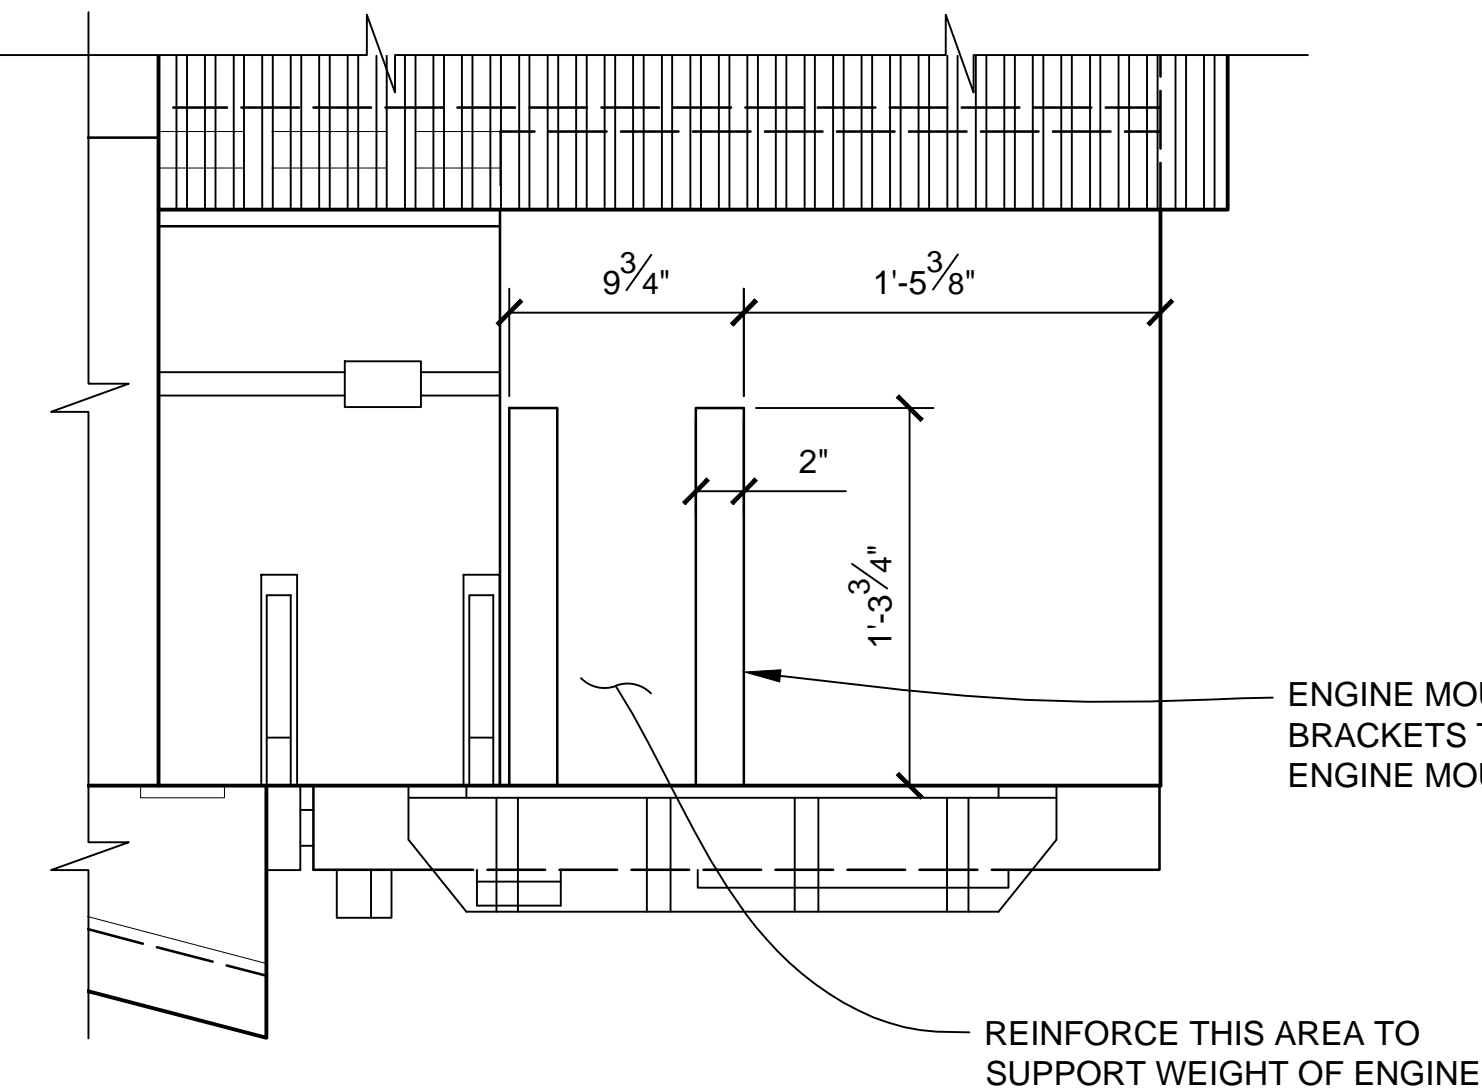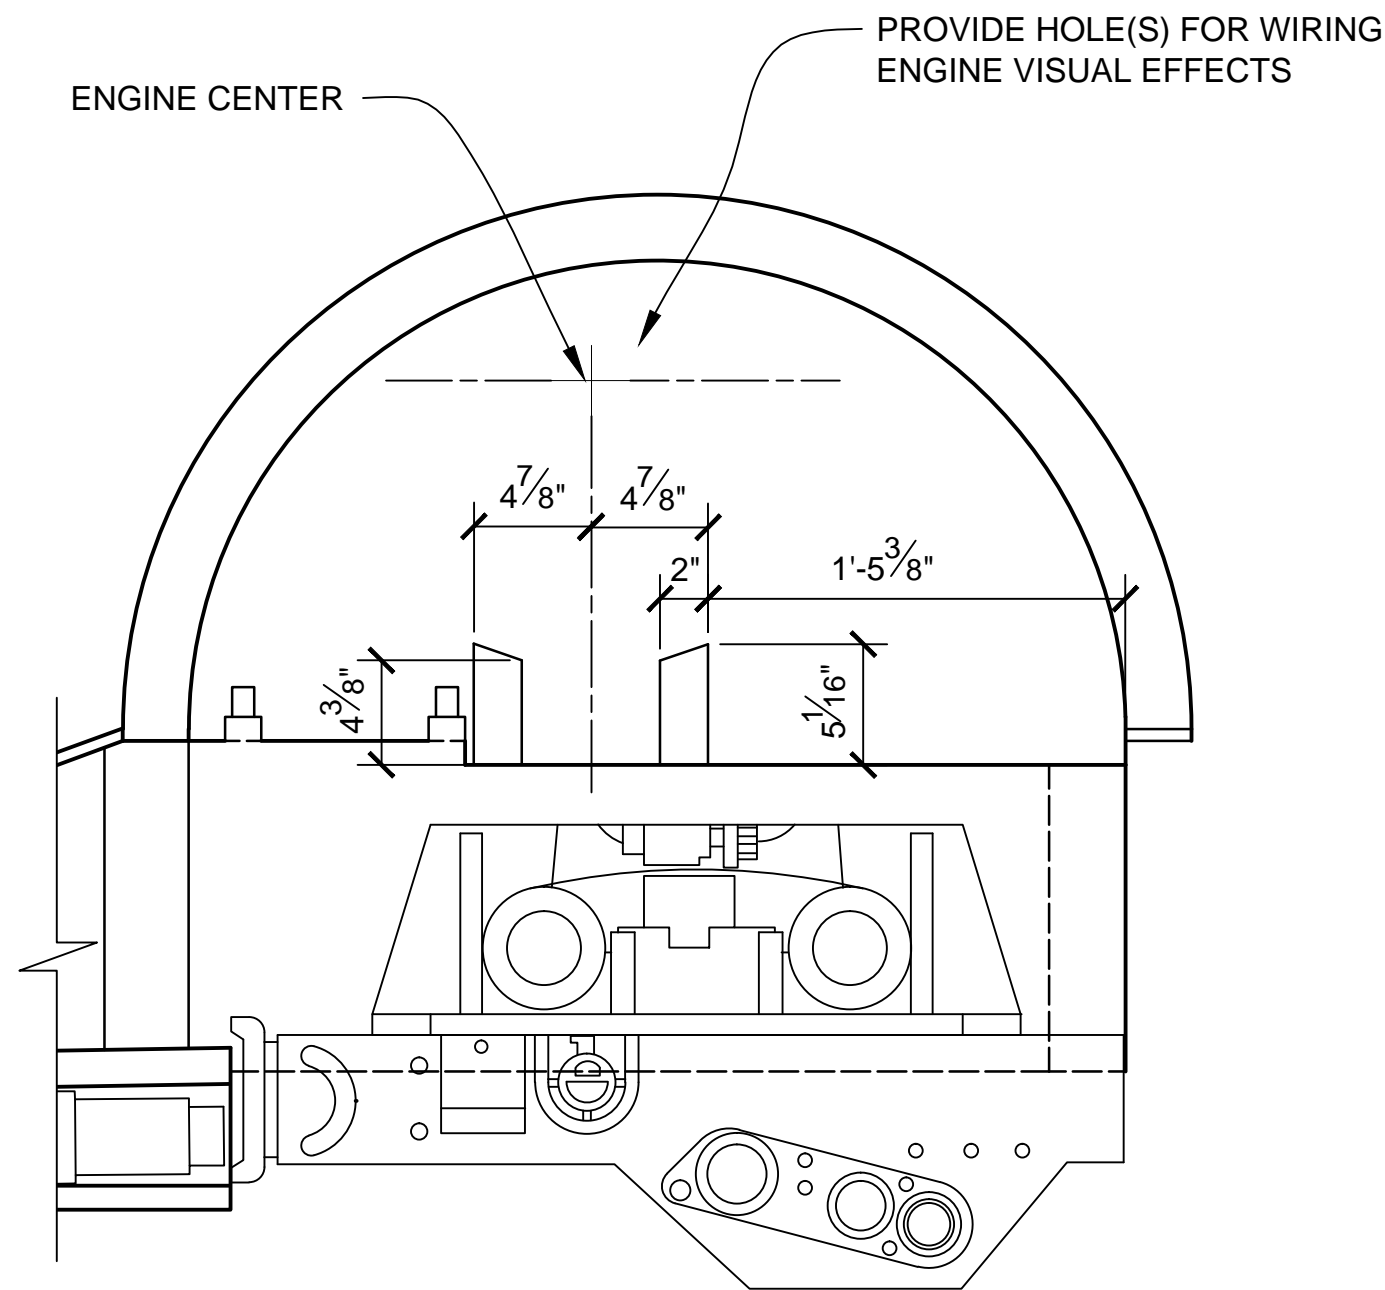



ENGINE MOUNT DETAIL
SCALE 1:8

- NOTES:**
1. PREEEXISTING MATERIAL COPYRIGHTED BY THE STAR WARS CORPORATION AND LUCASFILM LTD.
 2. LEFT S-FOIL IS SHOWN, RIGHT S-FOIL IS OPPOSITE HAND.
 3. ONE LEFT HAND AND ONE RIGHT HAND UPPER S-FOIL IS REQUIRED.
 4. CROSS SECTIONS SHOW OUTSIDE MOLDED SURFACE.

PRODUCTION	D.O.P.	ART DIRECTOR	CAMERA	
ART DEPT.	SET DESIGNER	SCULPTOR	GRAPHICS	
SET DEC.	DRAPES	PROPS	MODEL SHOP	
CONST. COORD.	CARPENTER	PLASTER	PAINT	
GREENS	SCENIC	METALS	SFX	
GRIP	ELECTRICAL	VFX	CGI	

PROJECT				
THE X-WING BUILD				
1:1 SCALE STAGE PROP				
SET				SET NO.
TITLE	S-FOILS PLANS & DETAILS UPPER S-FOILS			REV --
PROD DESIGNER				DATE DRAWN 3/SEP/2012
DRAWN BY B.J.S.	APPROVED BY			DATE ISSUED DD/MM/YYYY
STAGE	LOCATION			DWG NO.
FILE X-WING LINES_MASTER.DWG	SHEET 19 OF XX			3.02

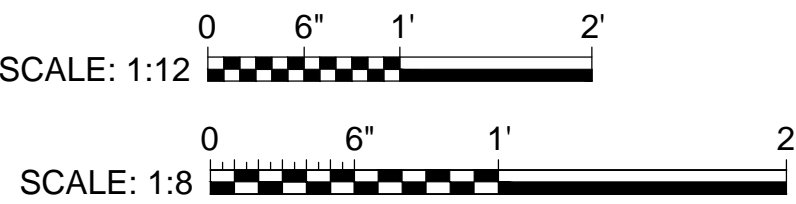

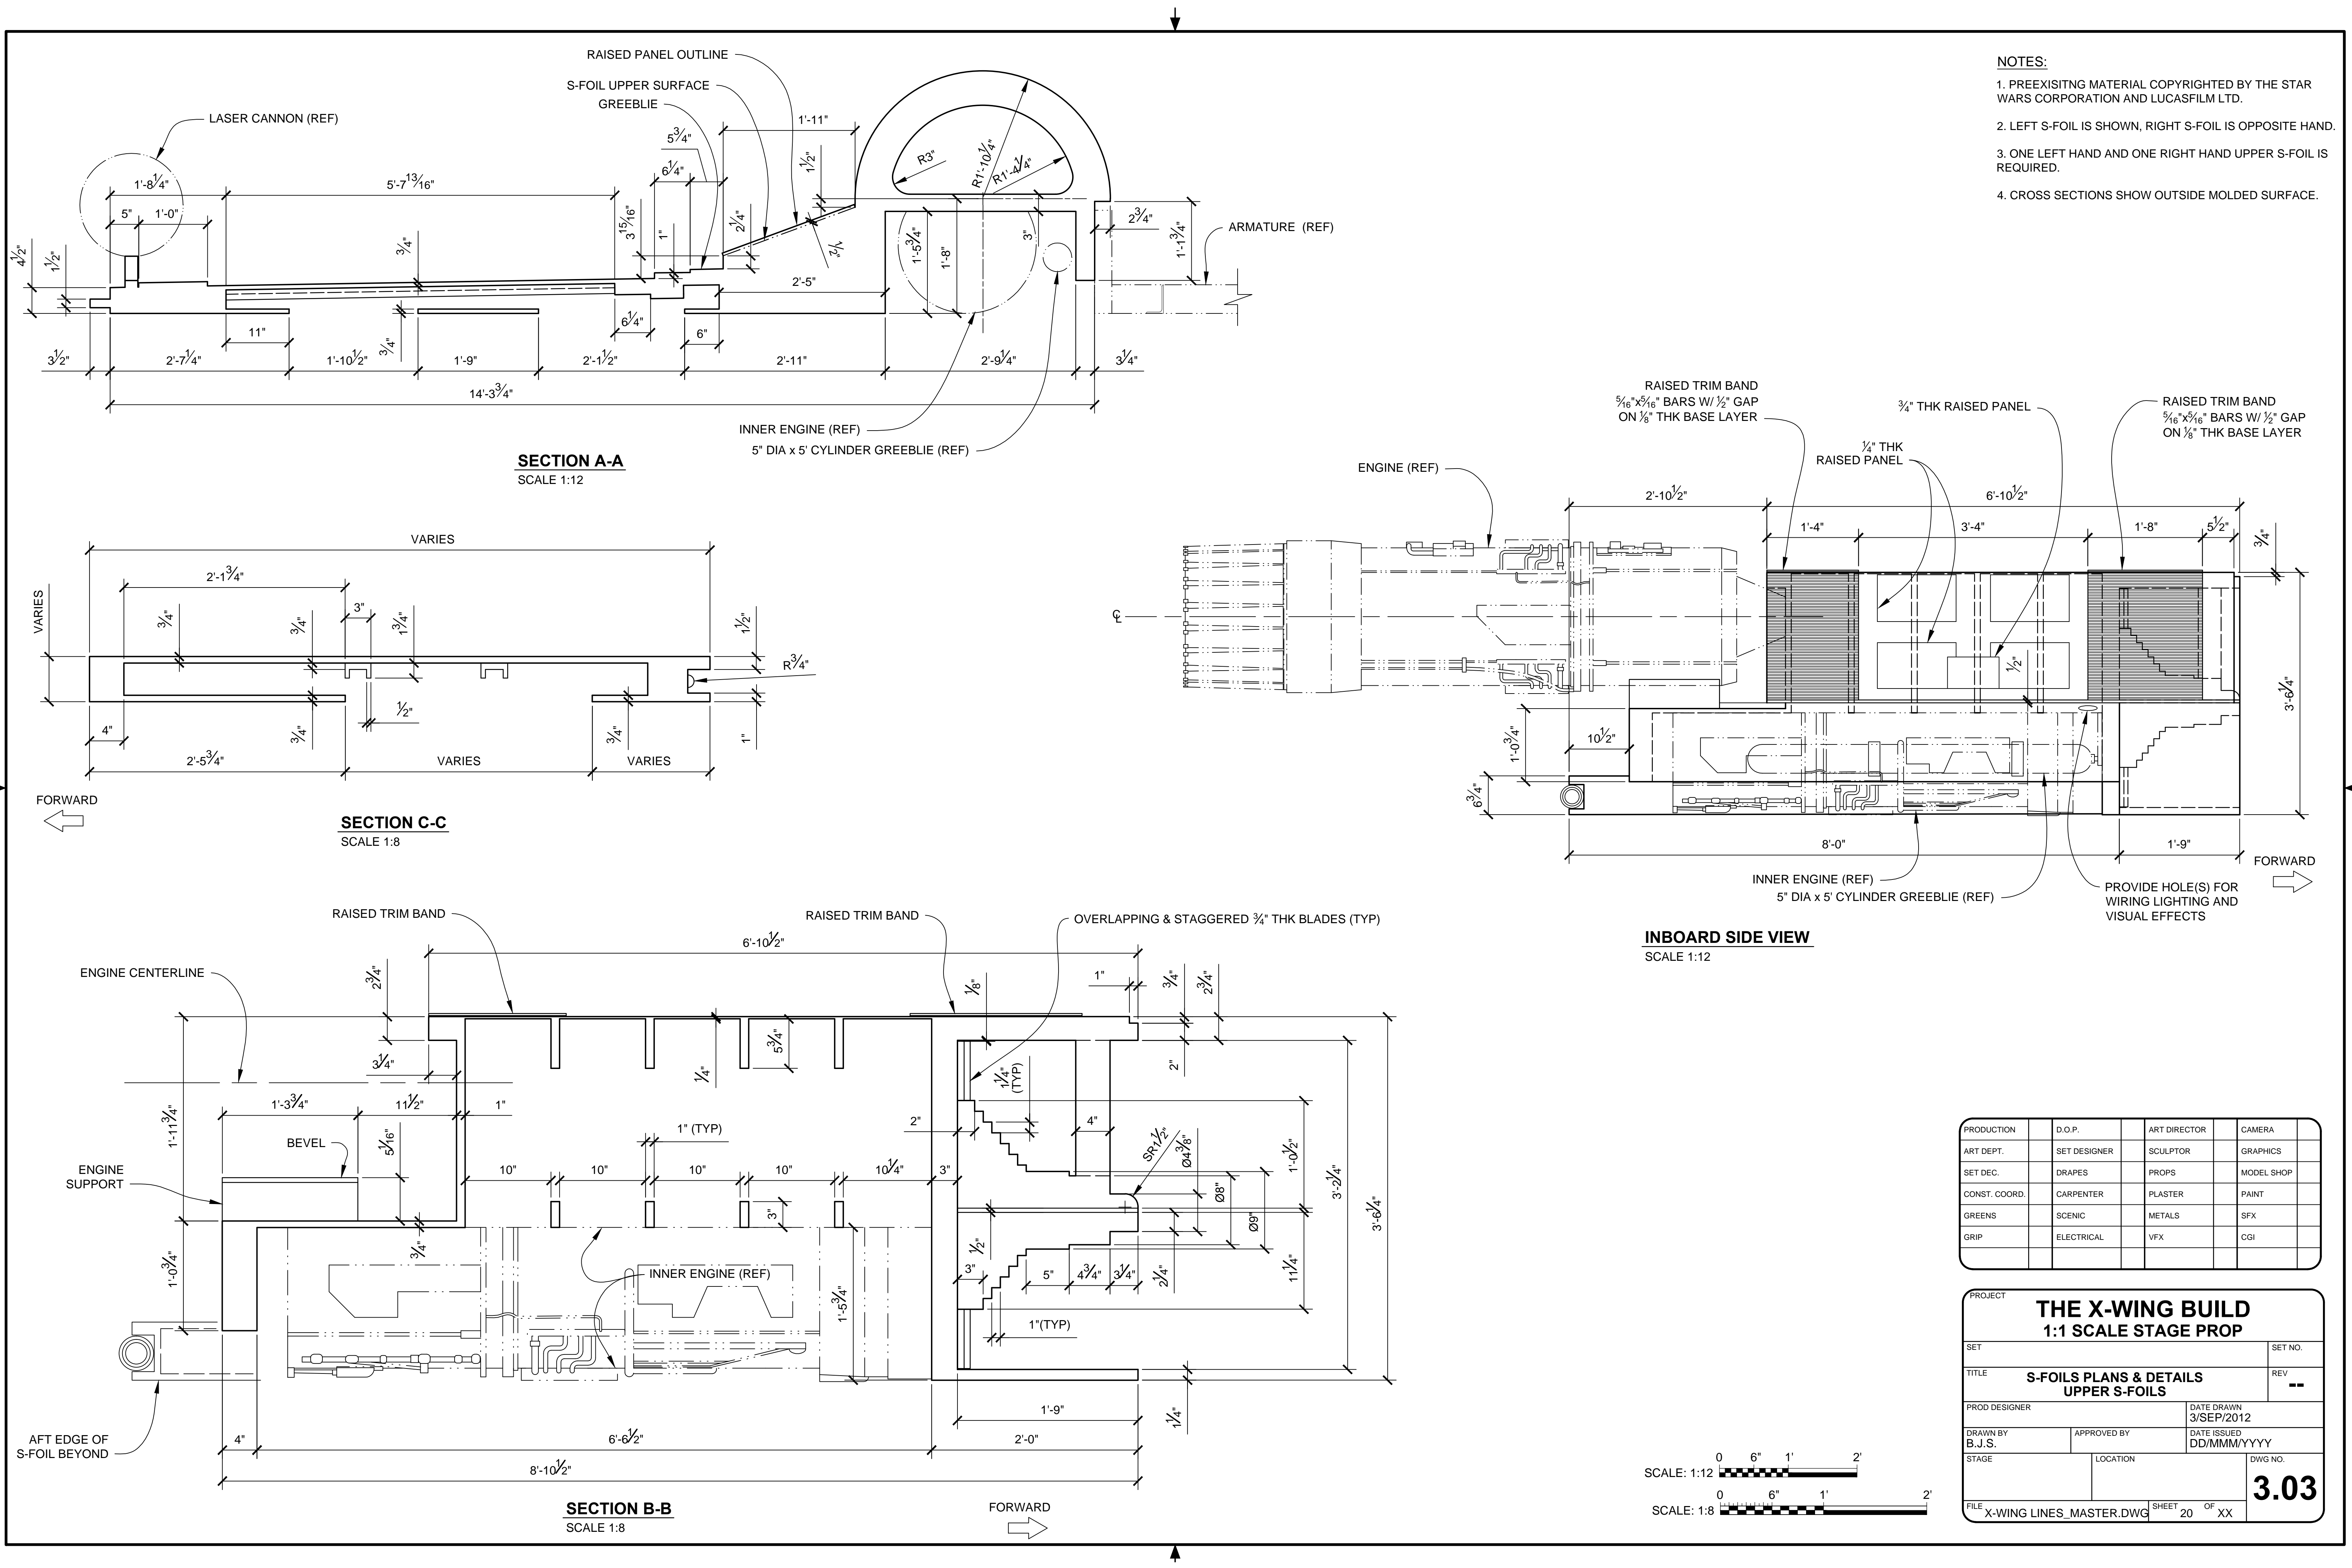

- NOTES:**
1. PREEXISTING MATERIAL COPYRIGHTED BY THE STAR WARS CORPORATION AND LUCASFILM LTD.
 2. LEFT S-FOIL IS SHOWN, RIGHT S-FOIL IS OPPOSITE HAND.
 3. ONE LEFT HAND AND ONE RIGHT HAND UPPER S-FOIL IS REQUIRED.
 4. CROSS SECTIONS SHOW OUTSIDE MOLDED SURFACE.

SECTION A-A
SCALE 1:12


SECTION C-C
SCALE 1:8


SECTION B-B
SCALE 1:8

INBOARD SIDE VIEW
SCALE 1:12


PRODUCTION	D.O.P.	ART DIRECTOR	CAMERA	
ART DEPT.	SET DESIGNER	SCULPTOR	GRAPHICS	
SET DEC.	DRAPES	PROPS	MODEL SHOP	
CONST. COORD.	CARPENTER	PLASTER	PAINT	
GREENS	SCENIC	METALS	SFX	
GRIP	ELECTRICAL	VFX	CGI	

PROJECT			
THE X-WING BUILD			
1:1 SCALE STAGE PROP			
SET			SET NO.
TITLE			REV
S-FOILS PLANS & DETAILS			--
UPPER S-FOILS			
PROD DESIGNER		DATE DRAWN	3/SEP/2012
DRAWN BY		DATE ISSUED	
B.J.S.		DD/MMM/YYYY	
STAGE	LOCATION		DWG NO.
FILE		SHEET	3.03
X-WING LINES_MASTER.DWG		20 OF XX	

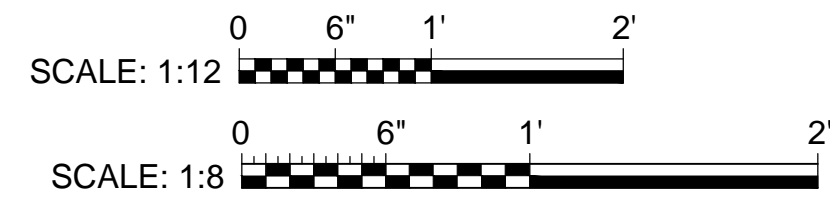


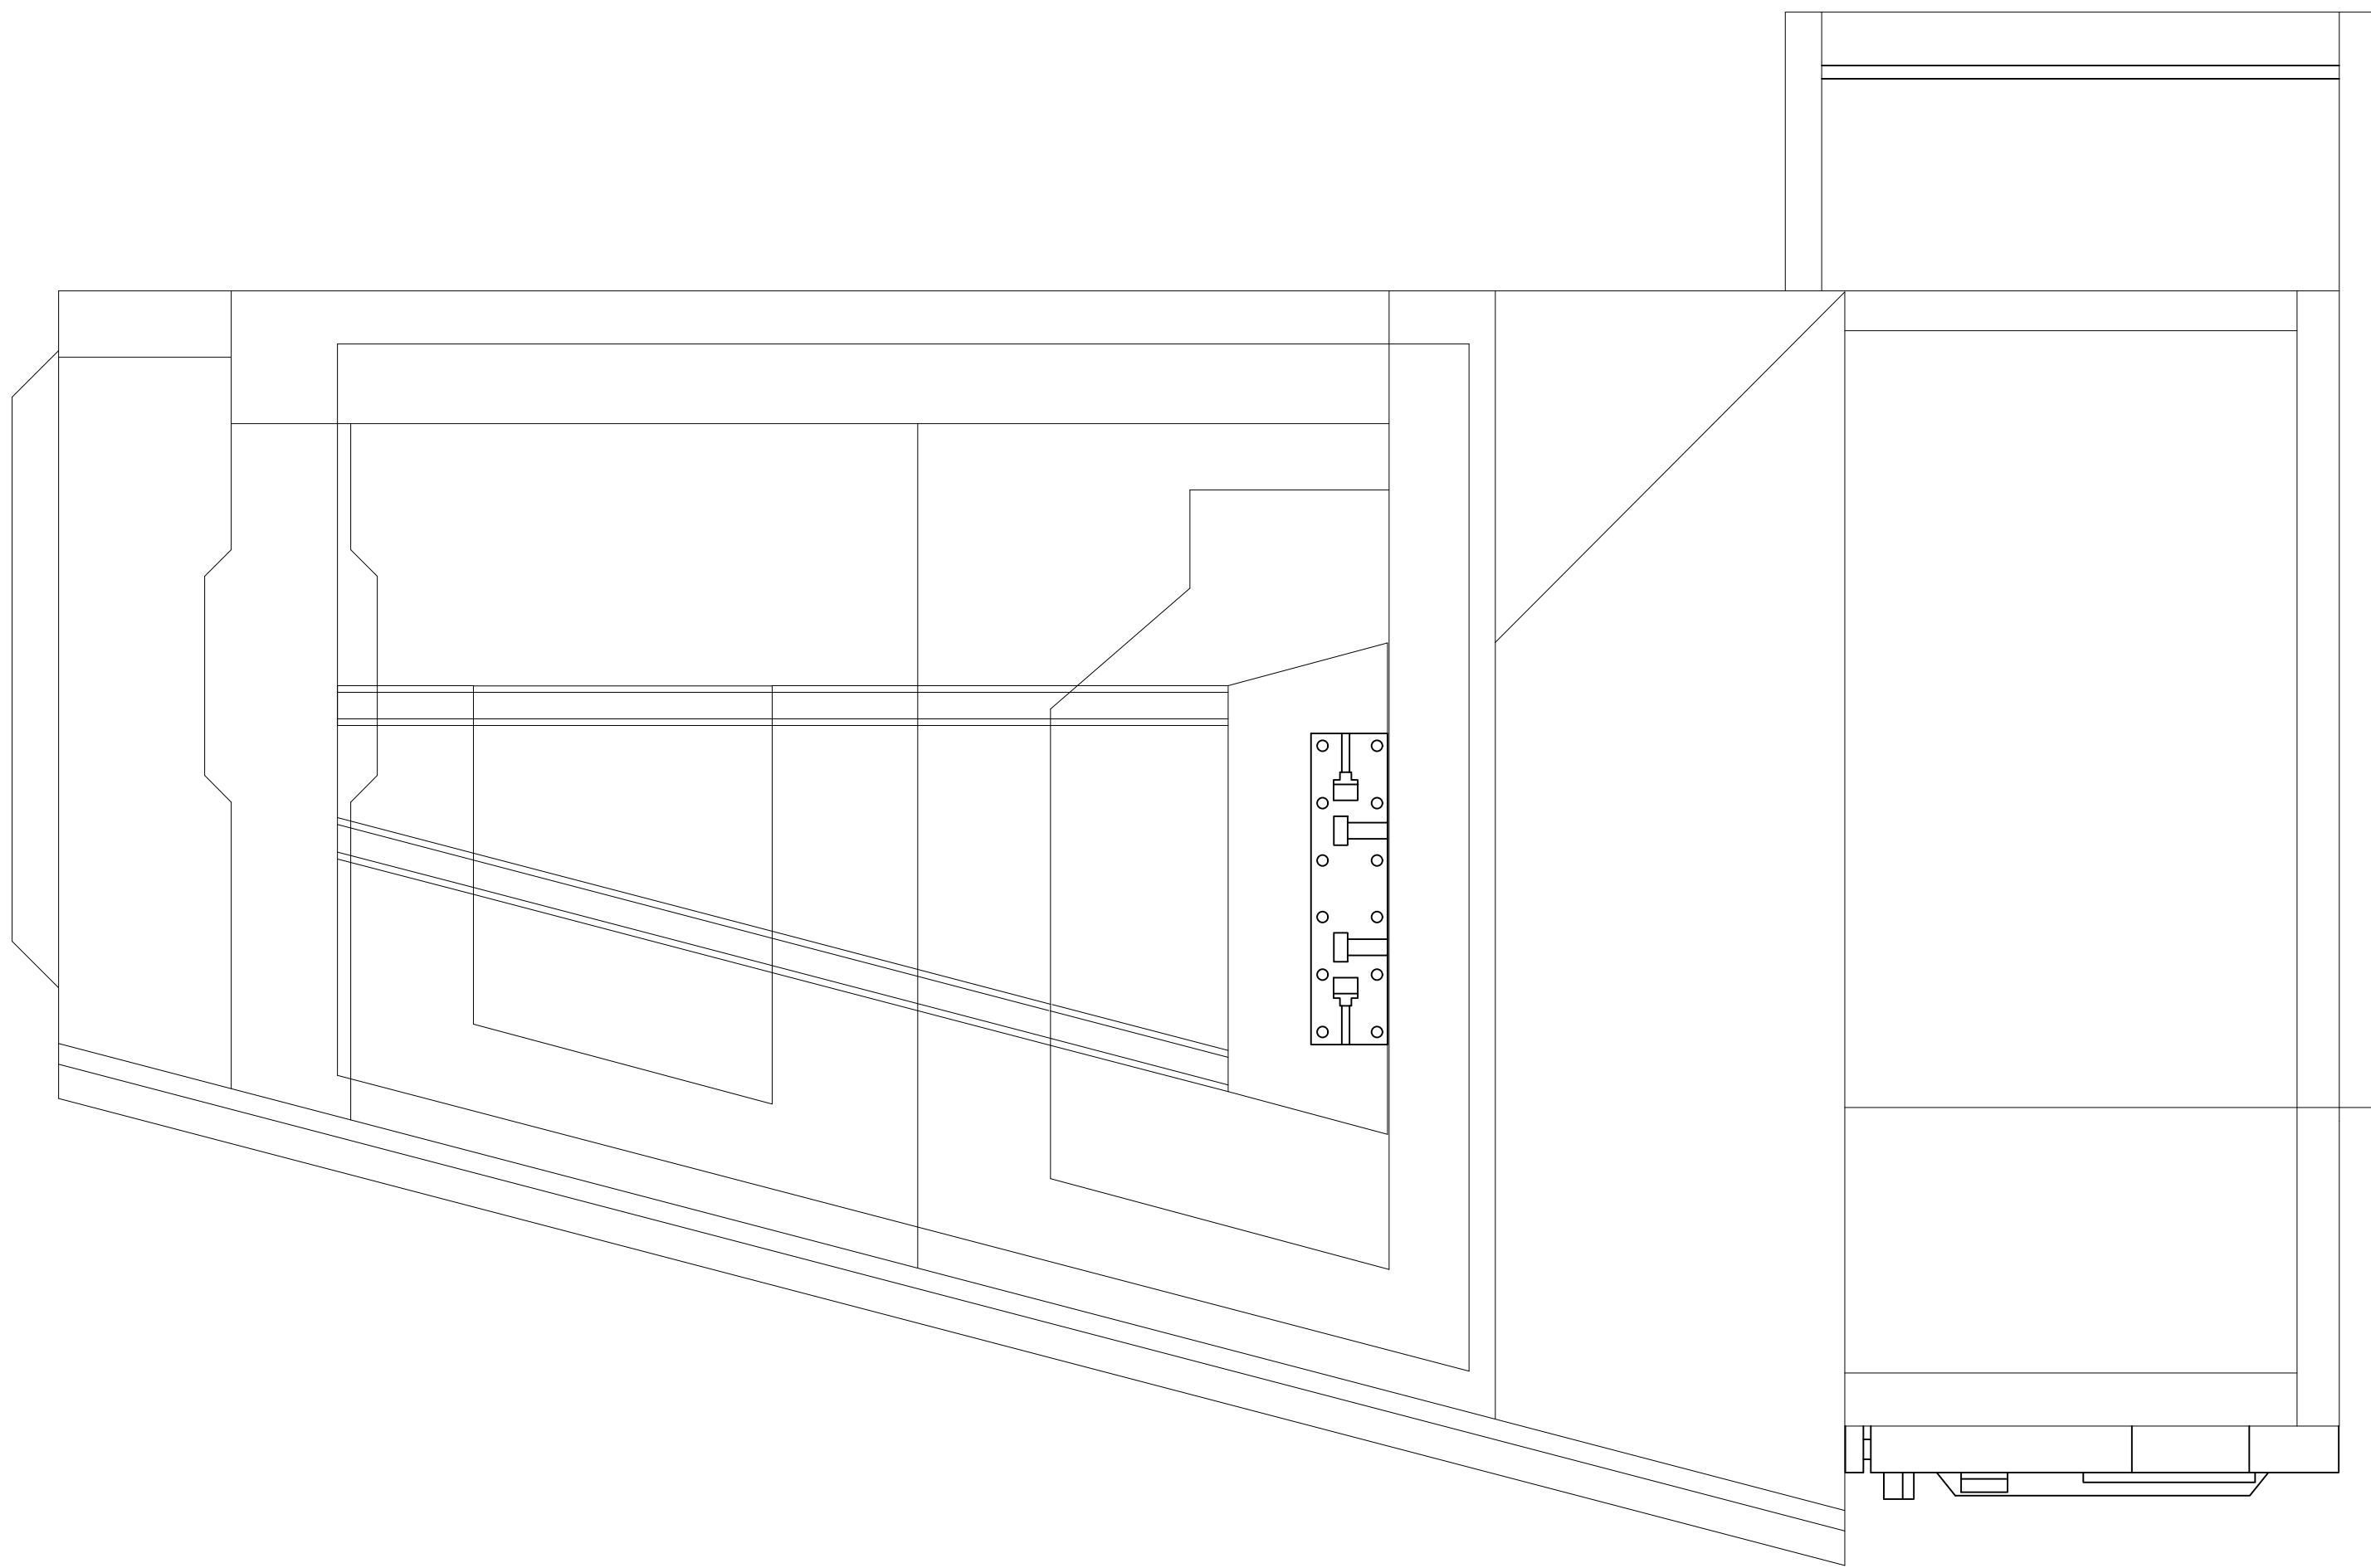

TOP VIEW
SCALE 1:12

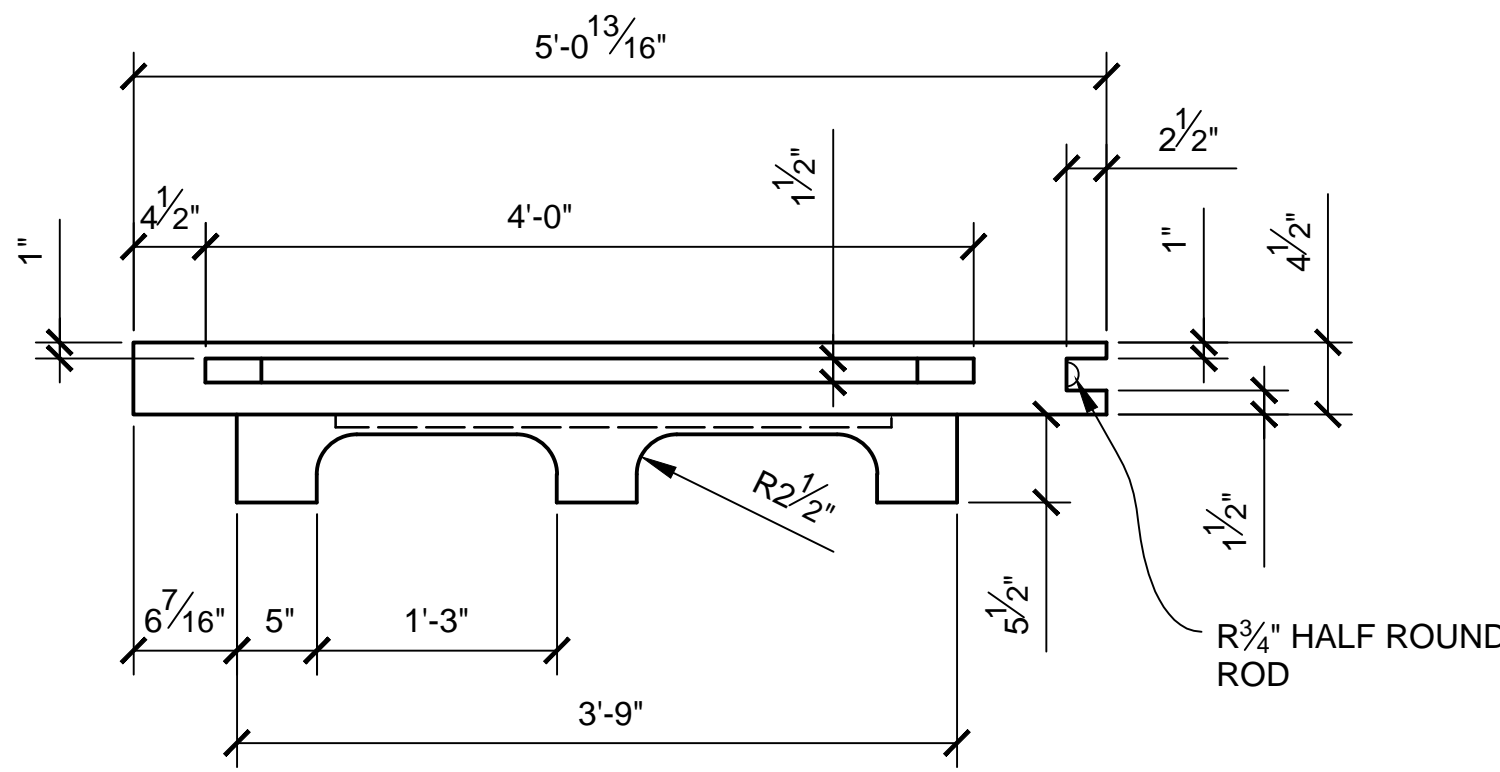

SIDE VIEW
SCALE 1:12

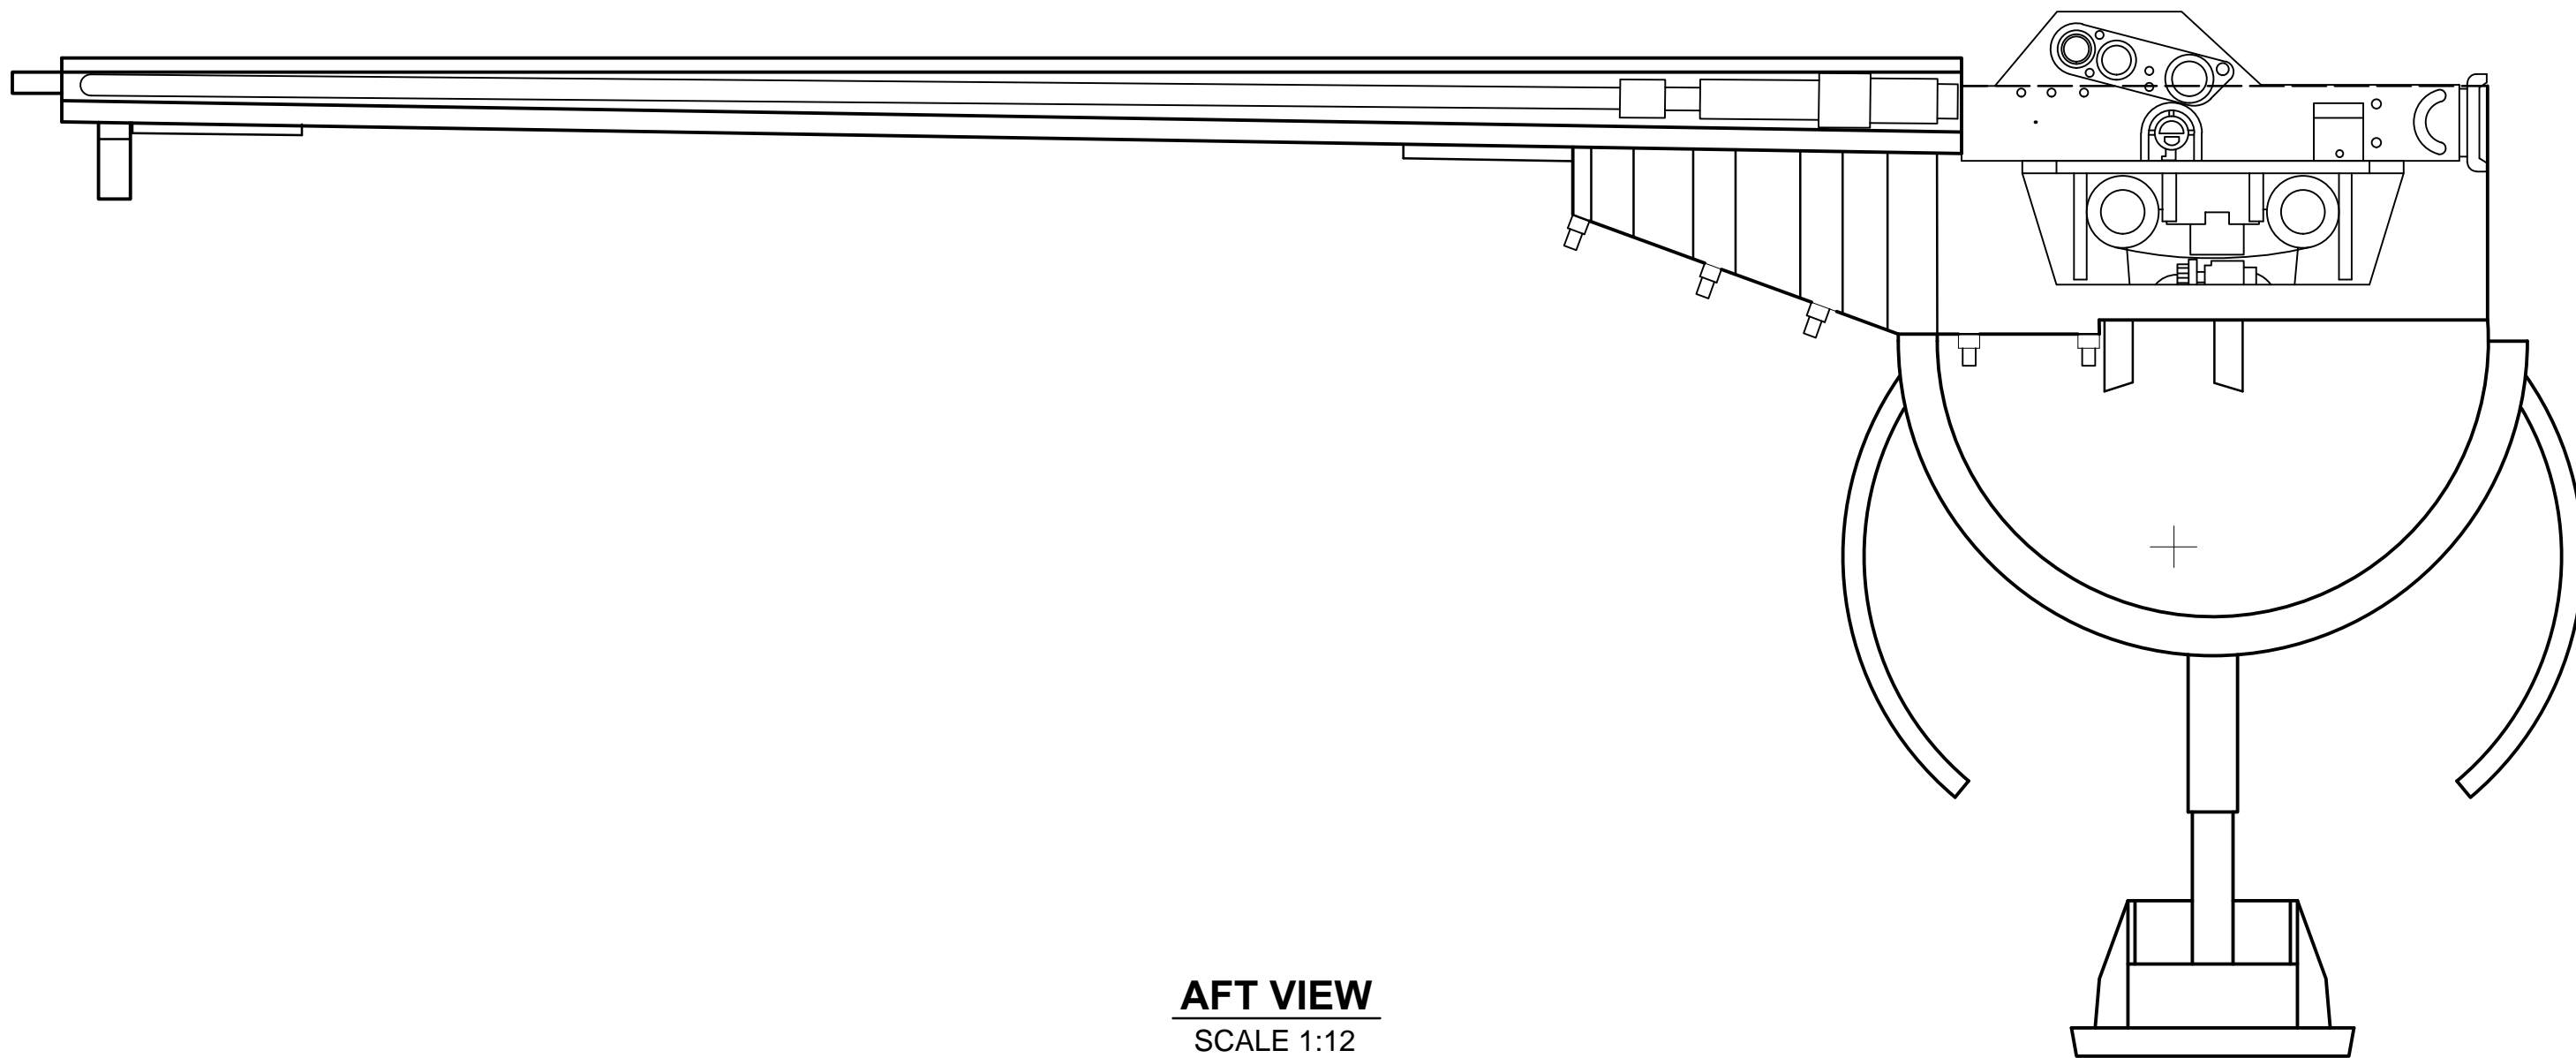

AFT VIEW
SCALE 1:12


NOTES:

1. PREEEXISTING MATERIAL COPYRIGHTED BY THE STAR WARS CORPORATION AND LUCASFILM LTD.
2. LEFT S-FOIL IS SHOWN, RIGHT S-FOIL IS OPPOSITE HAND.
3. ONE LEFT HAND AND ONE RIGHT HAND LOWER S-FOIL IS REQUIRED.


PRODUCTION	D.O.P.	ART DIRECTOR	CAMERA	
ART DEPT.	SET DESIGNER	SCULPTOR	GRAPHICS	
SET DEC.	DRAPES	PROPS	MODEL SHOP	
CONST. COORD.	CARPENTER	PLASTER	PAINT	
GREENS	SCENIC	METALS	SFX	
GRIP	ELECTRICAL	VFX	CGI	

PROJECT				
THE X-WING BUILD				
1:1 SCALE STAGE PROP				
SET N/A			SET NO. N/A	
TITLE S-FOILS PLANS & DETAILS LOWER S-FOILS			REV --	
PROD DESIGNER NONE		DATE DRAWN DD/MM/YYYY		
DRAWN BY B.J.S.	APPROVED BY I. NAME	DATE ISSUED DD/MM/YYYY		
STAGE N/A	LOCATION		DWG NO. 3.03	
FILE X-WING LINES_MASTER.DWG		SHEET 21	OF XX	


SCALE: 1:12 0 6" 1' 2'

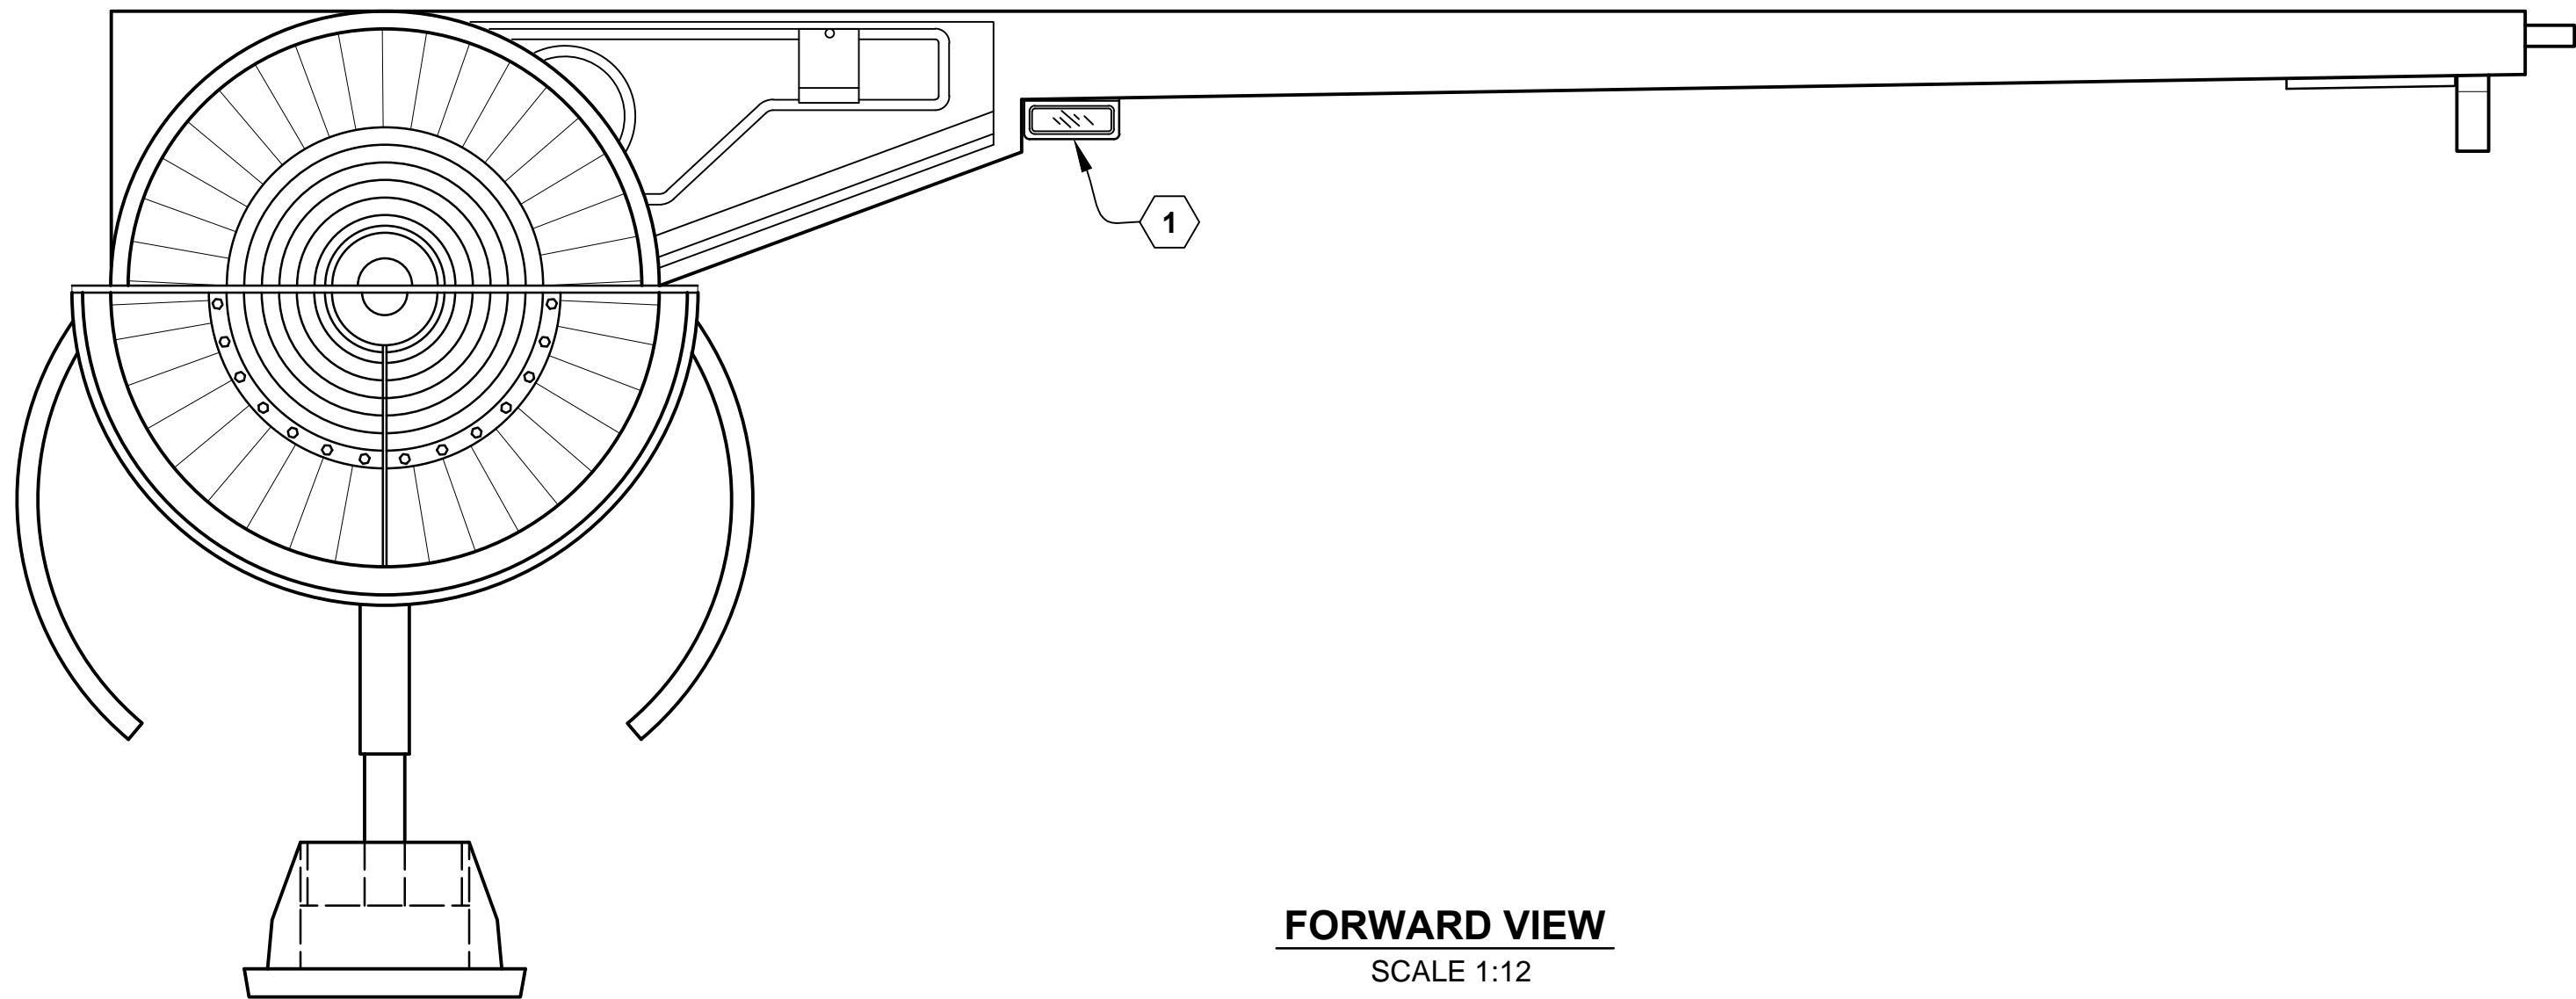

FORWARD VIEW
SCALE 1:12

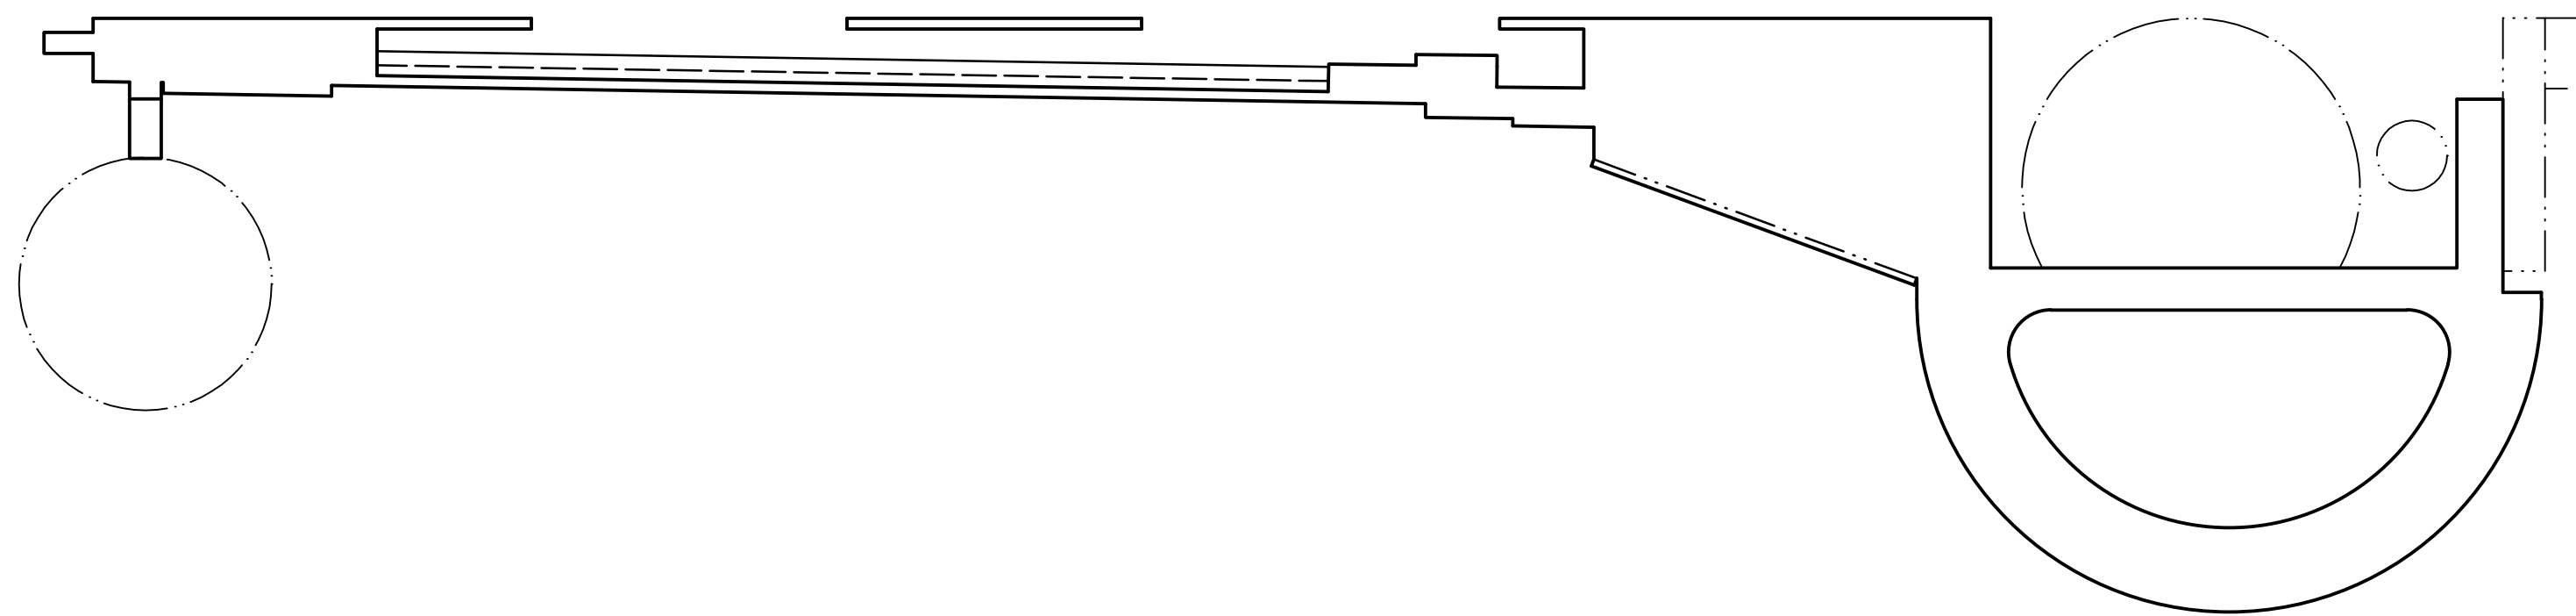

SECTION A-A
SCALE 1:12

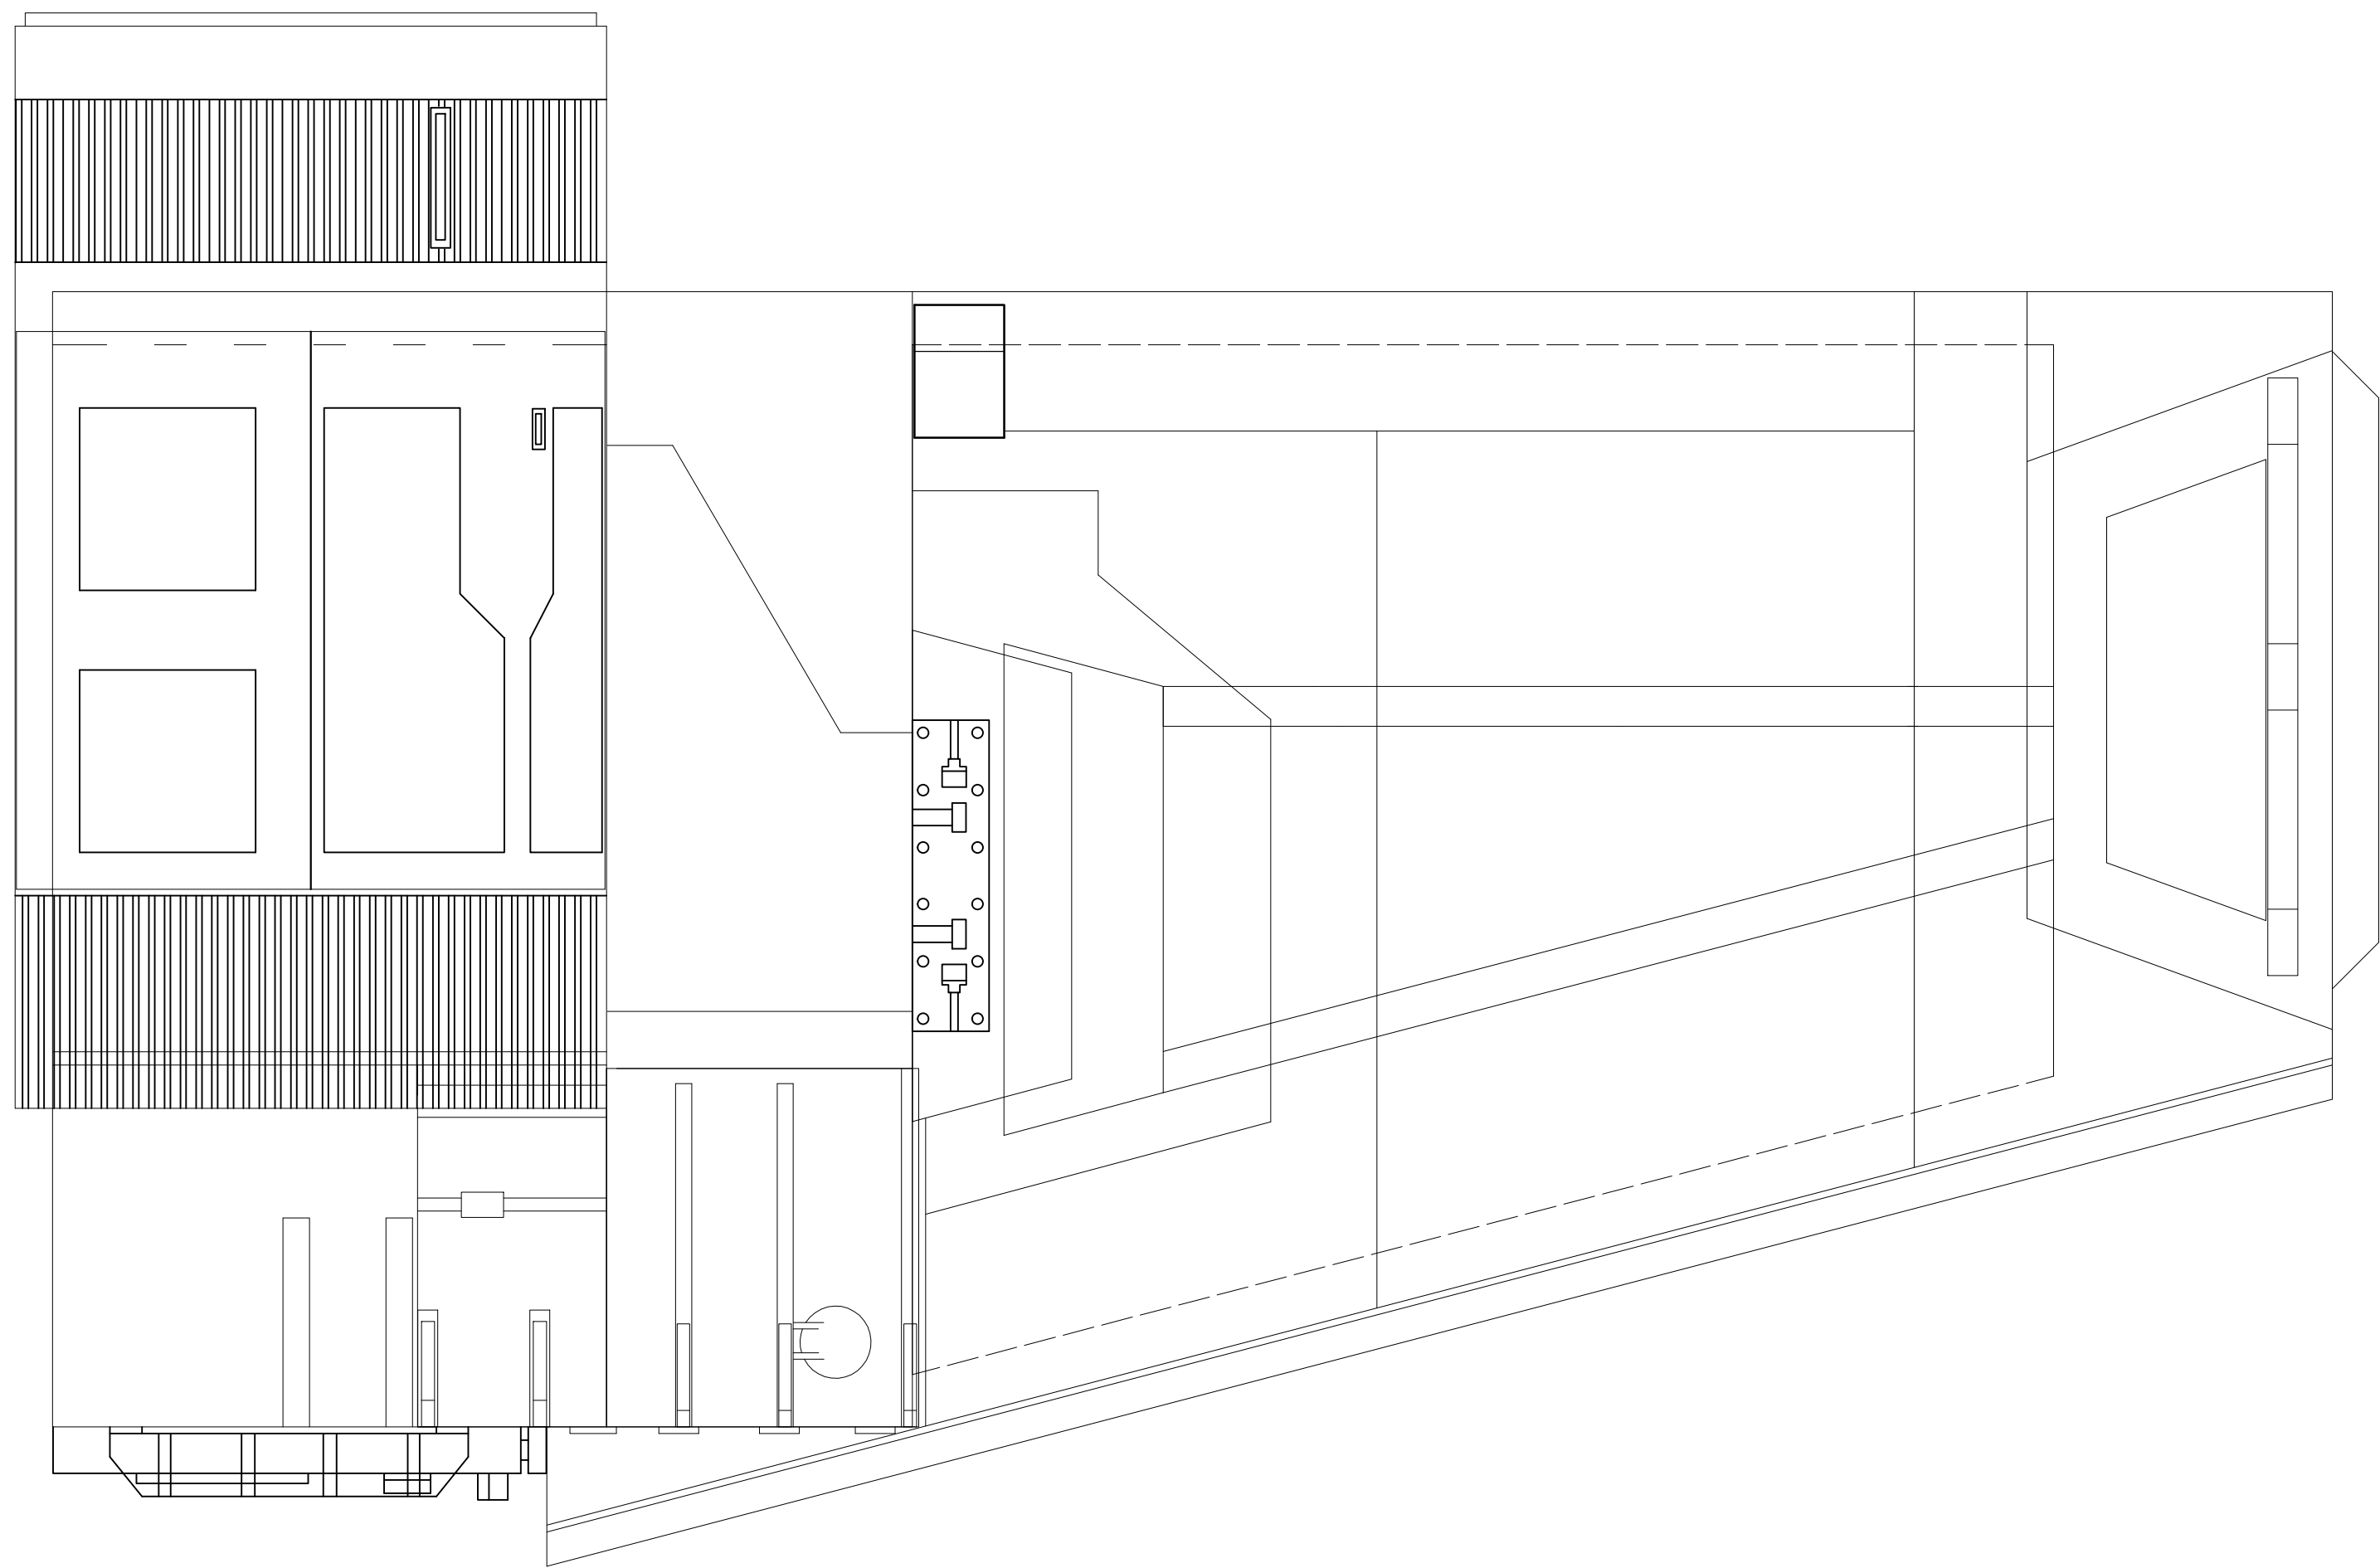

BOTTOM VIEW
SCALE 1:12

NOTES:

1. PREEXISTING MATERIAL COPYRIGHTED BY THE STAR WARS CORPORATION AND LUCASFILM LTD.
2. LEFT S-FOIL IS SHOWN, RIGHT S-FOIL IS OPPOSITE HAND.
3. ONE LEFT HAND AND ONE RIGHT HAND LOWER S-FOIL IS REQUIRED.

KEY NOTES:


1. EPISODE V LANDING LIGHT, NOT SHOWN IN EPISODE IV.

PRODUCTION	D.O.P.	ART DIRECTOR	CAMERA	
ART DEPT.	SET DESIGNER	SCULPTOR	GRAPHICS	
SET DEC.	DRAPES	PROPS	MODEL SHOP	
CONST. COORD.	CARPENTER	PLASTER	PAINT	
GREENS	SCENIC	METALS	SFX	
GRIP	ELECTRICAL	VFX	CGI	


PROJECT THE X-WING BUILD 1:1 SCALE STAGE PROP				
SET	N/A			SET NO. N/A
TITLE	S-FOILS PLANS & DETAILS LOWER S-FOILS			REV --
PROD DESIGNER NONE			DATE DRAWN DD/MM/YYYY	
DRAWN BY B.J.S.	APPROVED BY I. NAME		DATE ISSUED DD/MM/YYYY	
STAGE	LOCATION			DWG NO.
N/A			3.04	
FILE X-WING LINES_MASTER.DWG			SHEET 4	OF XX

SCALE: 1:12 0 6" 1' 2'


NOTES:
1. PREEIXITNG MATERIAL COPYRIGHTED BY THE STAR
WARS CORPORATION AND LUCASFILM LTD.

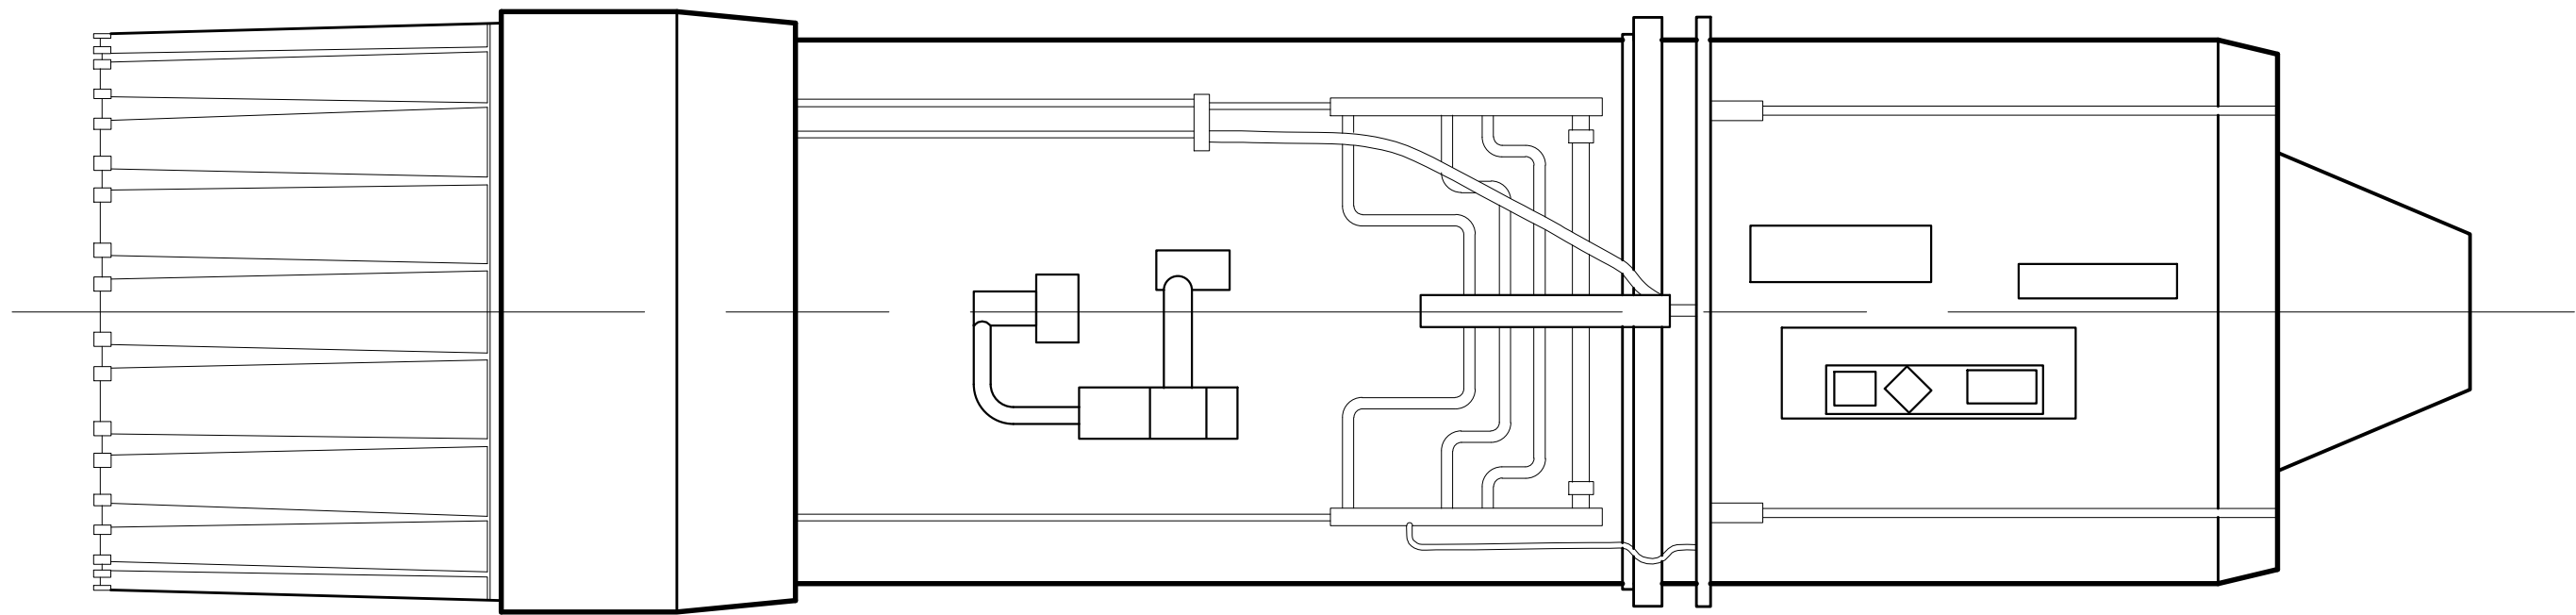


TOP VIEW
SCALE 1:8

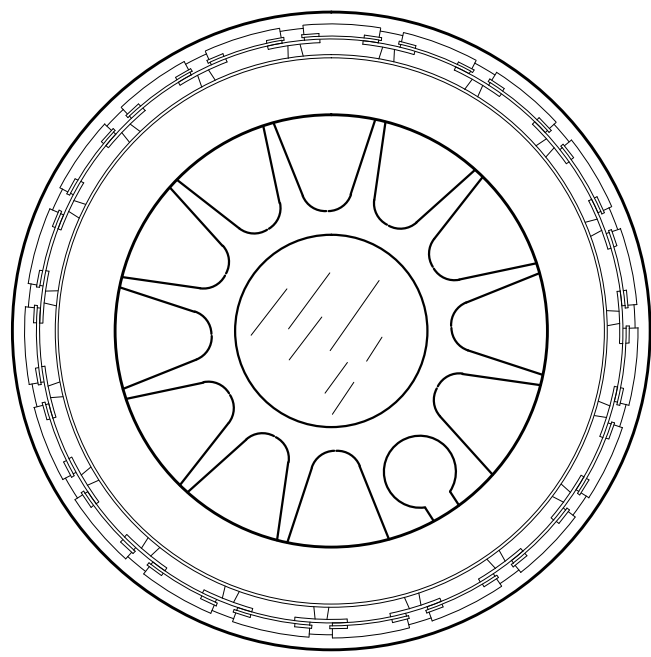

REAR VIEW
SCALE 1:8

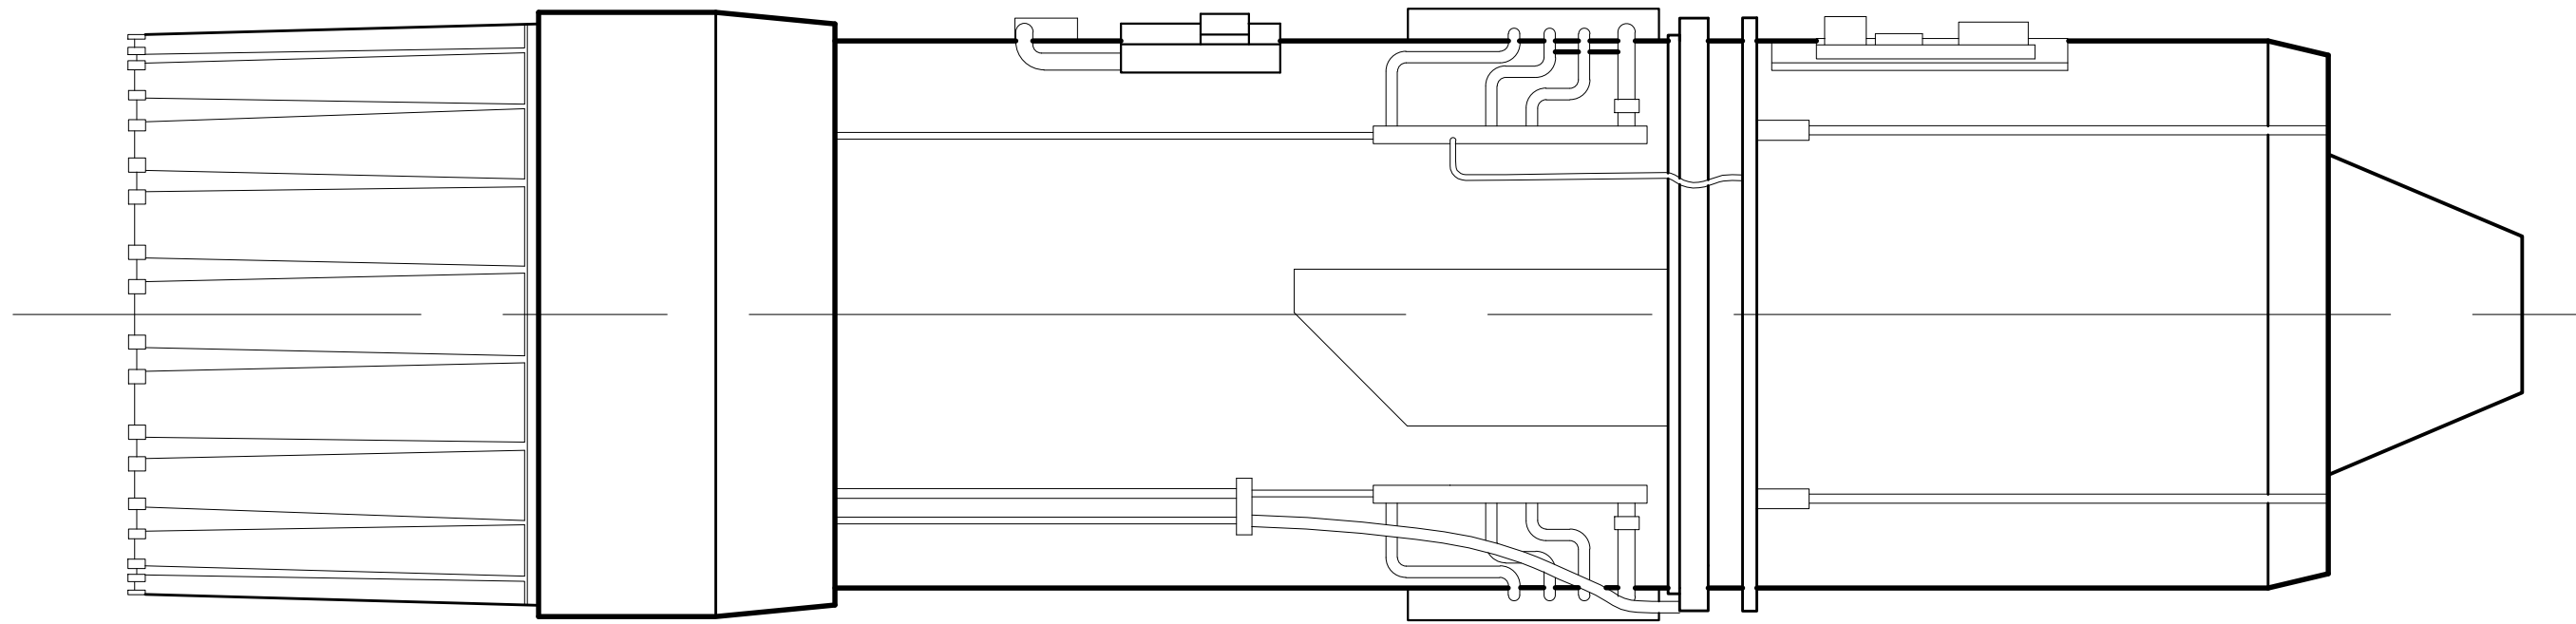


RIGHT SIDE VIEW
SCALE 1:8

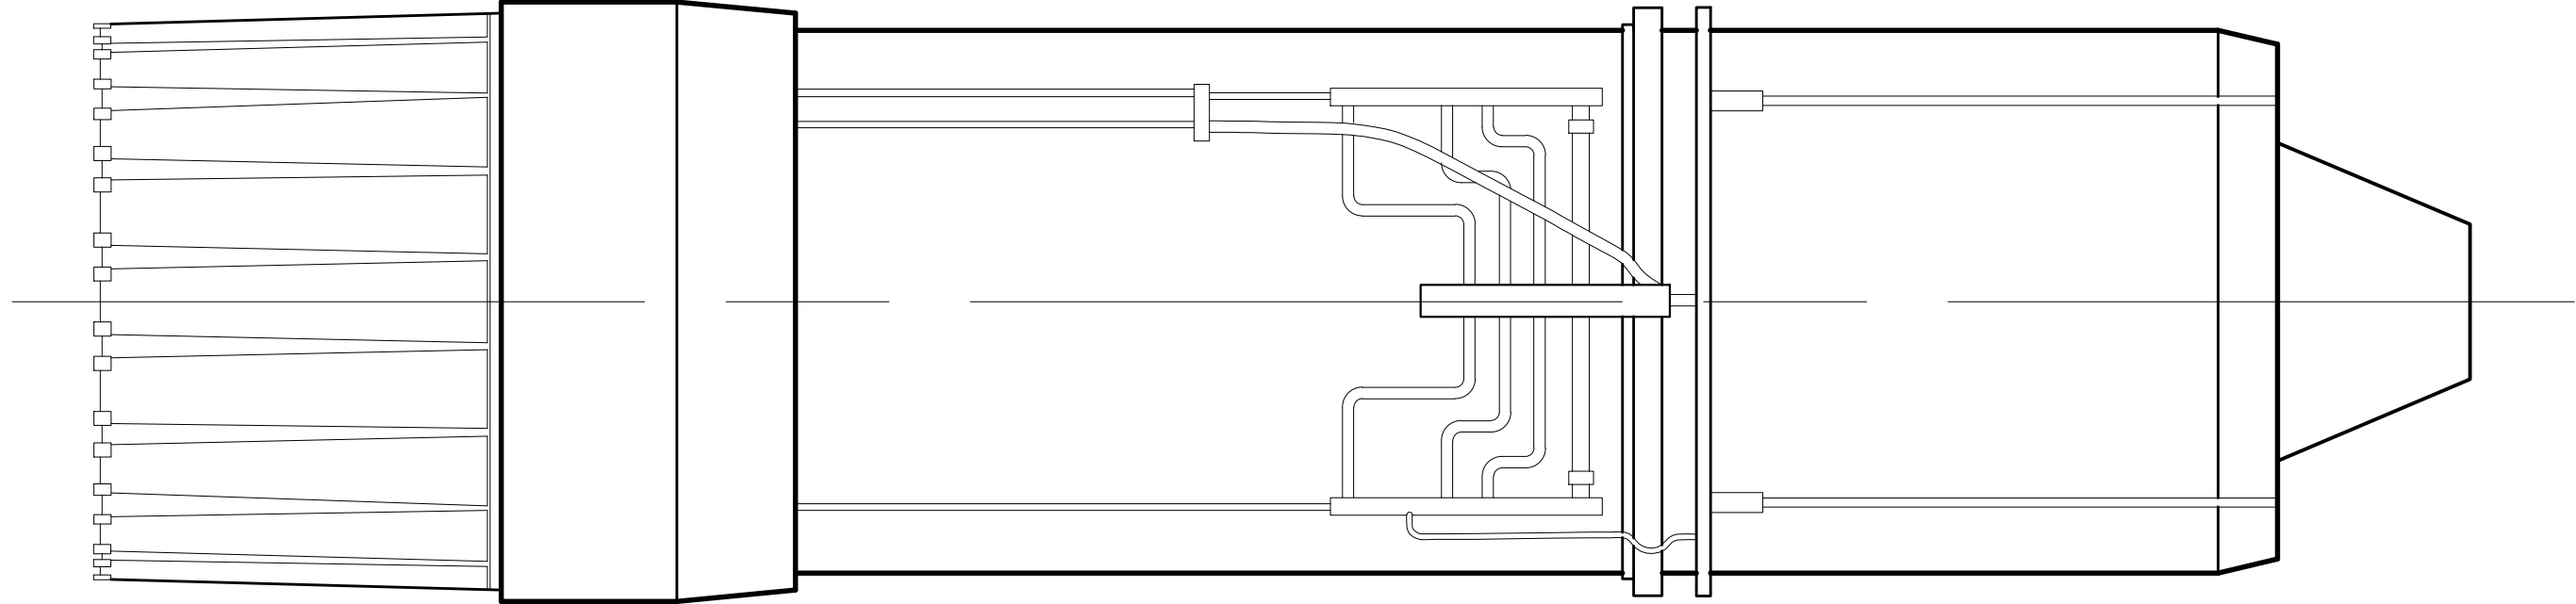

BOTTOM VIEW
SCALE 1:8


PRODUCTION	D.O.P.	ART DIRECTOR	CAMERA	
ART DEPT.	SET DESIGNER	SCULPTOR	GRAPHICS	
SET DEC.	DRAPES	PROPS	MODEL SHOP	
CONST. COORD.	CARPENTER	PLASTER	PAINT	
GREENS	SCENIC	METALS	SFX	
GRIP	ELECTRICAL	VFX	CGI	

PROJECT				
THE X-WING BUILD				
1:1 SCALE STAGE PROP				
SET	N/A			SET NO. N/A
TITLE	ENGINES			REV --
PROD DESIGNER NONE			DATE DRAWN DD/MM/YYYY	
DRAWN BY B.J.S.	APPROVED BY I. NAME		DATE ISSUED DD/MM/YYYY	
STAGE	N/A			DWG NO.
			4.01	
FILE X-WING LINES_MASTER.DWG	SHEET 4	OF XX		

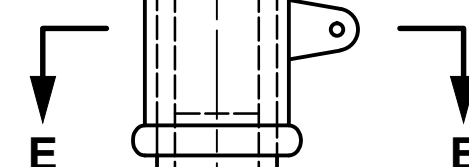[illegible]

PRODUCTION	D.O.P.	ART DIRECTOR	CAMERA
ART DEPT.	SET DESIGNER	SCULPTOR	GRAPHICS
SET DEC.	DRAPES	PROPS	MODEL SHOP
CONST. COORD.	CARPENTER	PLASTER	PAINT
GREENS	SCENIC	METALS	SFX
GRIP	ELECTRICAL	VFX	CGI

PROJECT		<h1>THE X-WING BUILD</h1> <h2>1:1 SCALE STAGE PROP</h2>	
SET		N/A	
TITLE		<h3>MECHANICAL DETAILS</h3> <h3>NOSE LANDING GEAR STRUT</h3>	
PROD DESIGNER		DATE DRAWN	
NONE		11/NOV/2012	
DRAWN BY		DATE ISSUED	
B.J.S.		DD/MMM/YYYY	
STAGE		DWG NO.	
N/A		5.1	
LOCATION		SHEET	
FILE		4 OF XX	
X-WING LINES		MASTER.DWG	

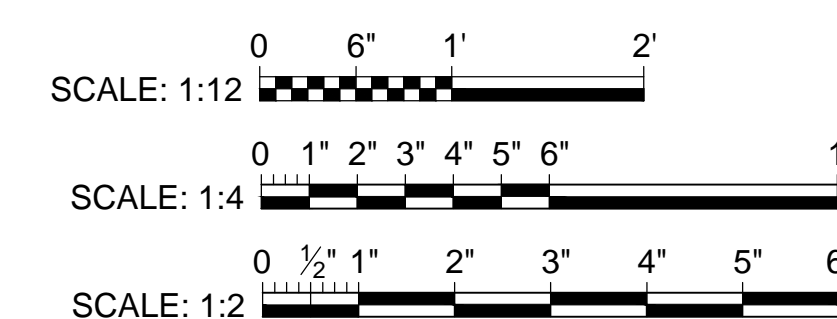




PRODUCTION	D.O.P.	ART DIRECTOR	CAMERA
ART DEPT.	SET DESIGNER	SCULPTOR	GRAPHICS
SET DEC.	DRAPES	PROPS	MODEL SHOP
CONST. COORD.	CARPENTER	PLASTER	PAINT
GREENS	SCENIC	METALS	SFX
GRIP	ELECTRICAL	VFX	CGI



PROJECT		<h1 style="margin: 0;">THE X-WING BUILD</h1> <h2 style="margin: 0;">1:1 SCALE STAGE PROP</h2>	
SET	N/A	SET NO.	N/A
TITLE	MECHANICAL DETAILS HOISTING ADAPTERS	REV	--
PROD DESIGNER NONE		DATE DRAWN DD/MMM/YYYY	
DRAWN BY B.J.S.	APPROVED BY I. NAME	DATE ISSUED DD/MMM/YYYY	
STAGE	LOCATION	DWG NO.	
<h1 style="font-size: 48px; margin: 0;">N/A</h1>		<h1 style="font-size: 48px; margin: 0;">X.X</h1>	
FILE X-WING LINES_MASTER.DWG		SHEET 4	OF XX

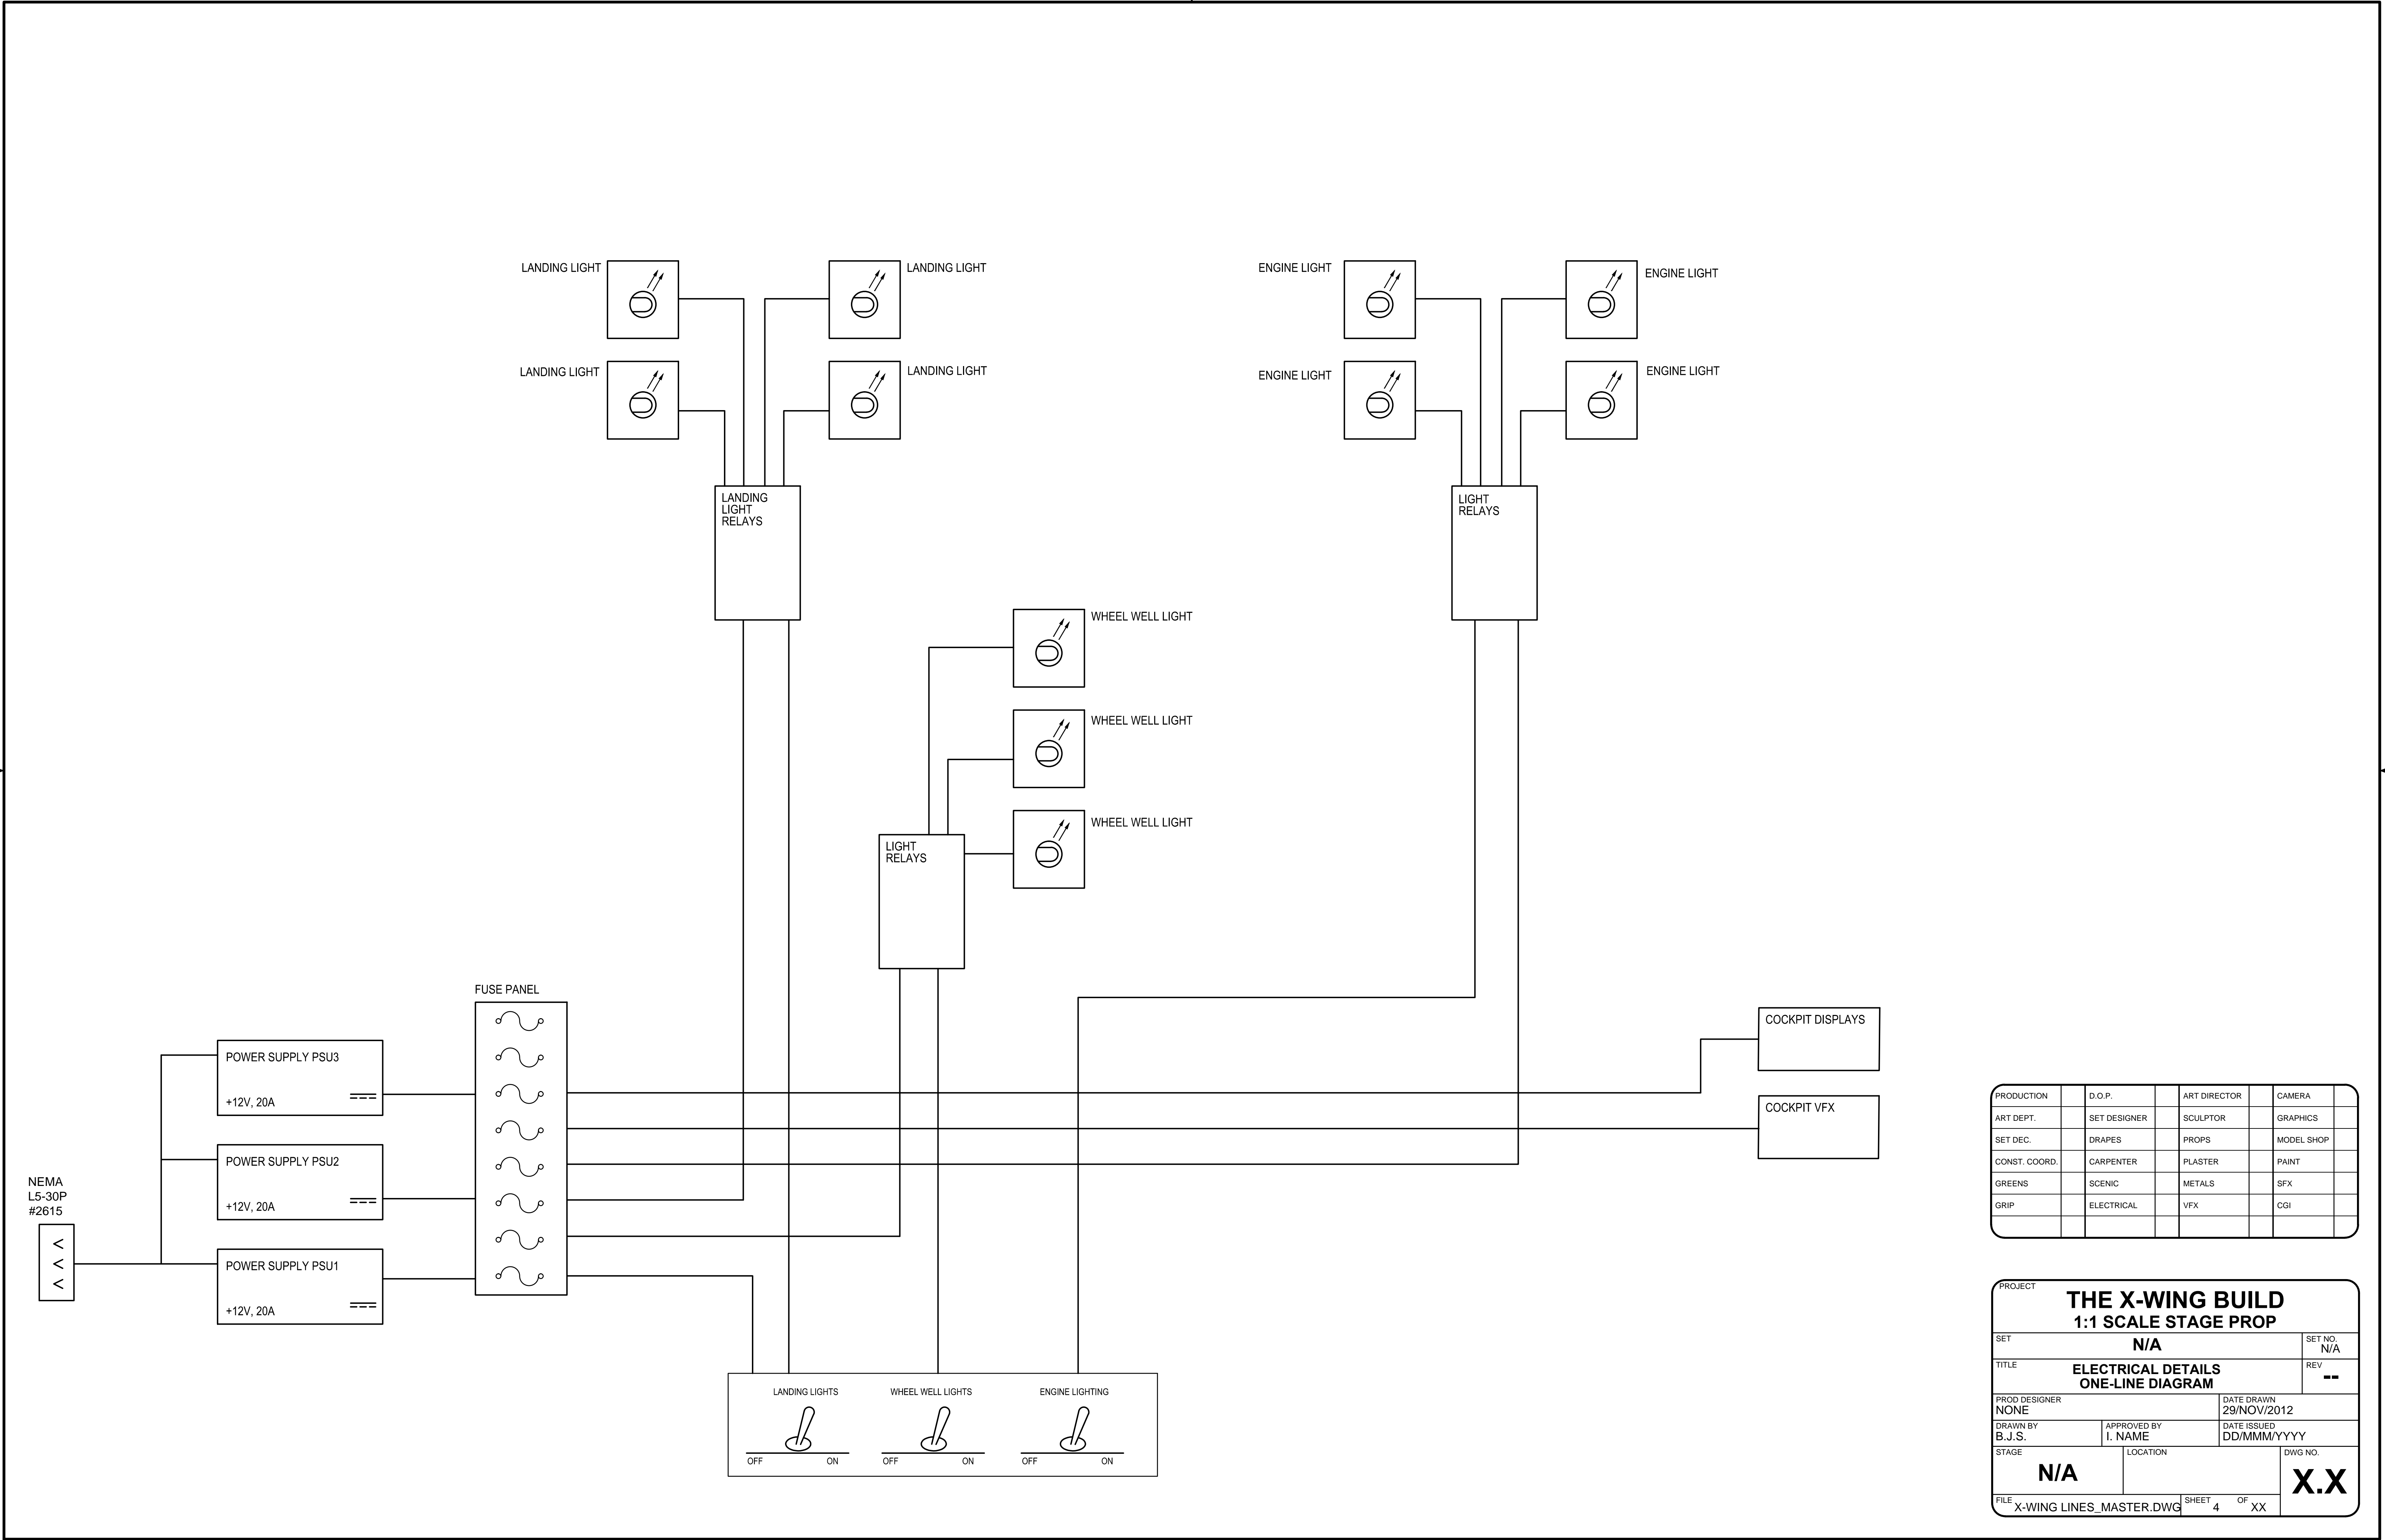

PRODUCTION	D.O.P.	ART DIRECTOR	CAMERA	
ART DEPT.	SET DESIGNER	SCULPTOR	GRAPHICS	
SET DEC.	DRAPES	PROPS	MODEL SHOP	
CONST. COORD.	CARPENTER	PLASTER	PAINT	
GREENS	SCENIC	METALS	SFX	
GRIP	ELECTRICAL	VFX	CGI	

PROJECT THE X-WING BUILD 1:1 SCALE STAGE PROP				
SET	N/A			SET NO. N/A
TITLE	ELECTRICAL DETAILS ONE-LINE DIAGRAM			REV --
PROD DESIGNER NONE			DATE DRAWN 29/NOV/2012	
DRAWN BY B.J.S.	APPROVED BY I. NAME		DATE ISSUED DD/MMM/YYYY	
STAGE N/A	LOCATION			DWG NO. X.X
FILE X-WING LINES_MASTER.DWG			SHEET 4	OF XX